

CAELAN MCKENZIE

INTERIOR DESIGN PORTFOLIO

CAELAN MCKENZIE
INTERIORS



CONTENTS

01

hill
residence

02

brown
residence

03

trammel
designs

04

jones
residence

05

hand drawn
renderings

06

professional
work

HILL RESIDENCE



Designed a single level
1,665 square foot home
for a special needs client
located in Athens, GA


- Revit 2022
- Universal Design
- Renderings
- FF & E Selections
- Lighting & Electrical Plans with Legends



HILL RESIDENCE



HAND RENDERING

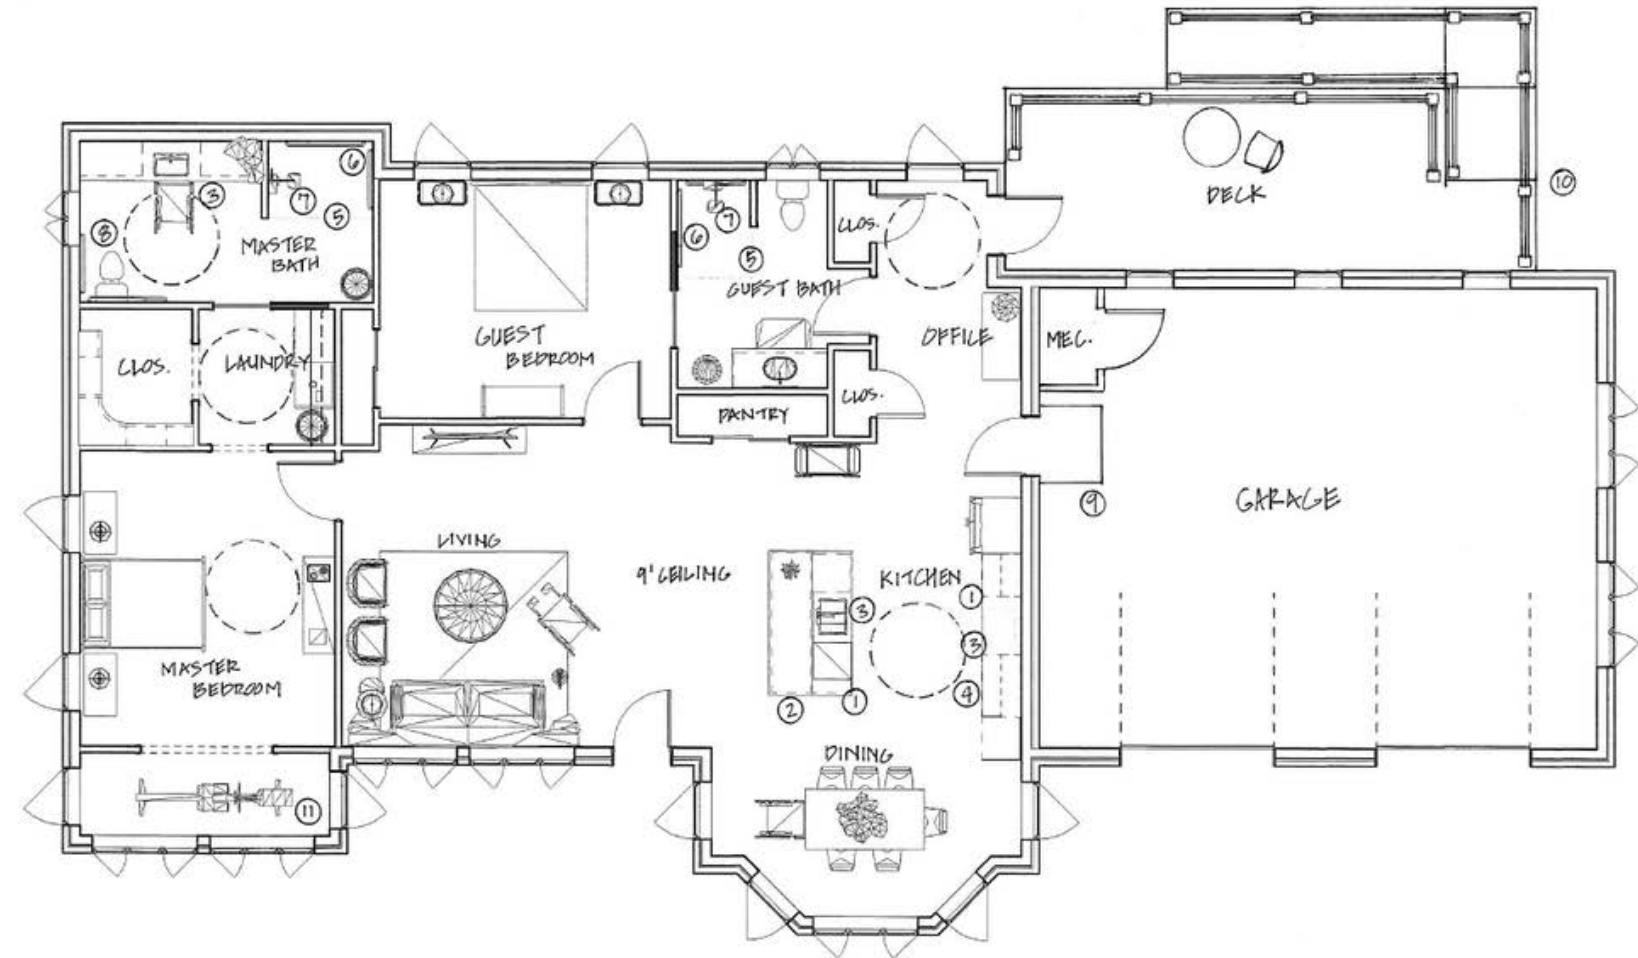

ACCESSIBLE FLOOR PLAN

RENDERINGS



BROWN RESIDENCE



Designed a two-story, 3,400 square feet home in Duluth, Minnesota



SW 7757
High Reflective
White

Revit 2022 • CD Set • Site Plan • Schedules and Legends • FF&E Selections • Elevations • Renderings


MAIN & UPPER LEVELS

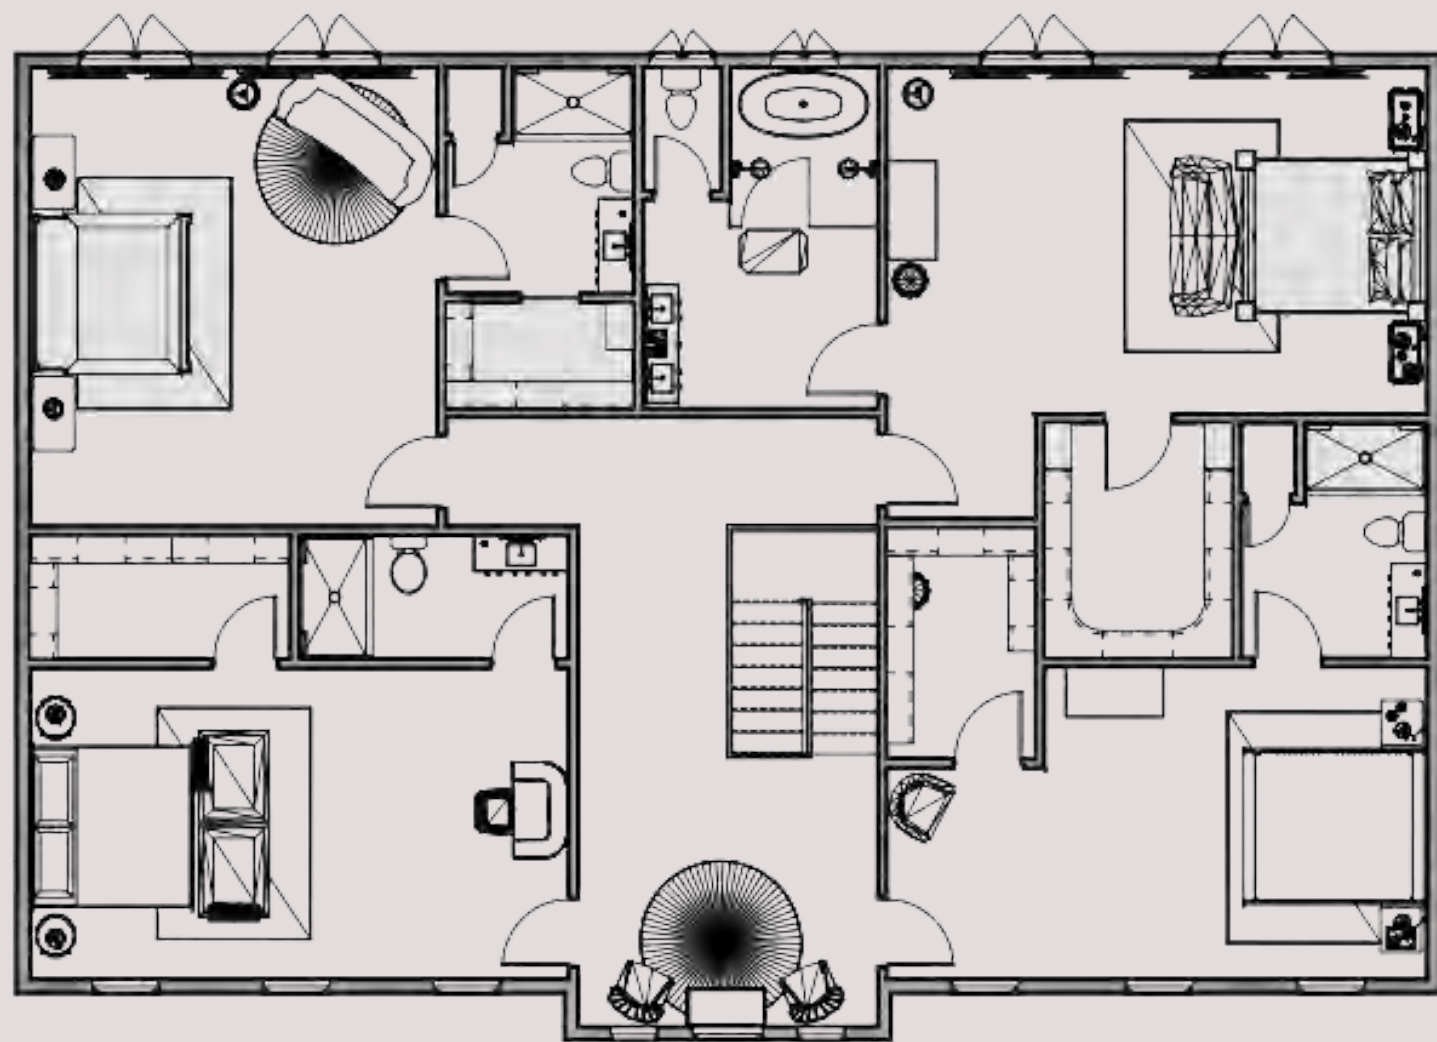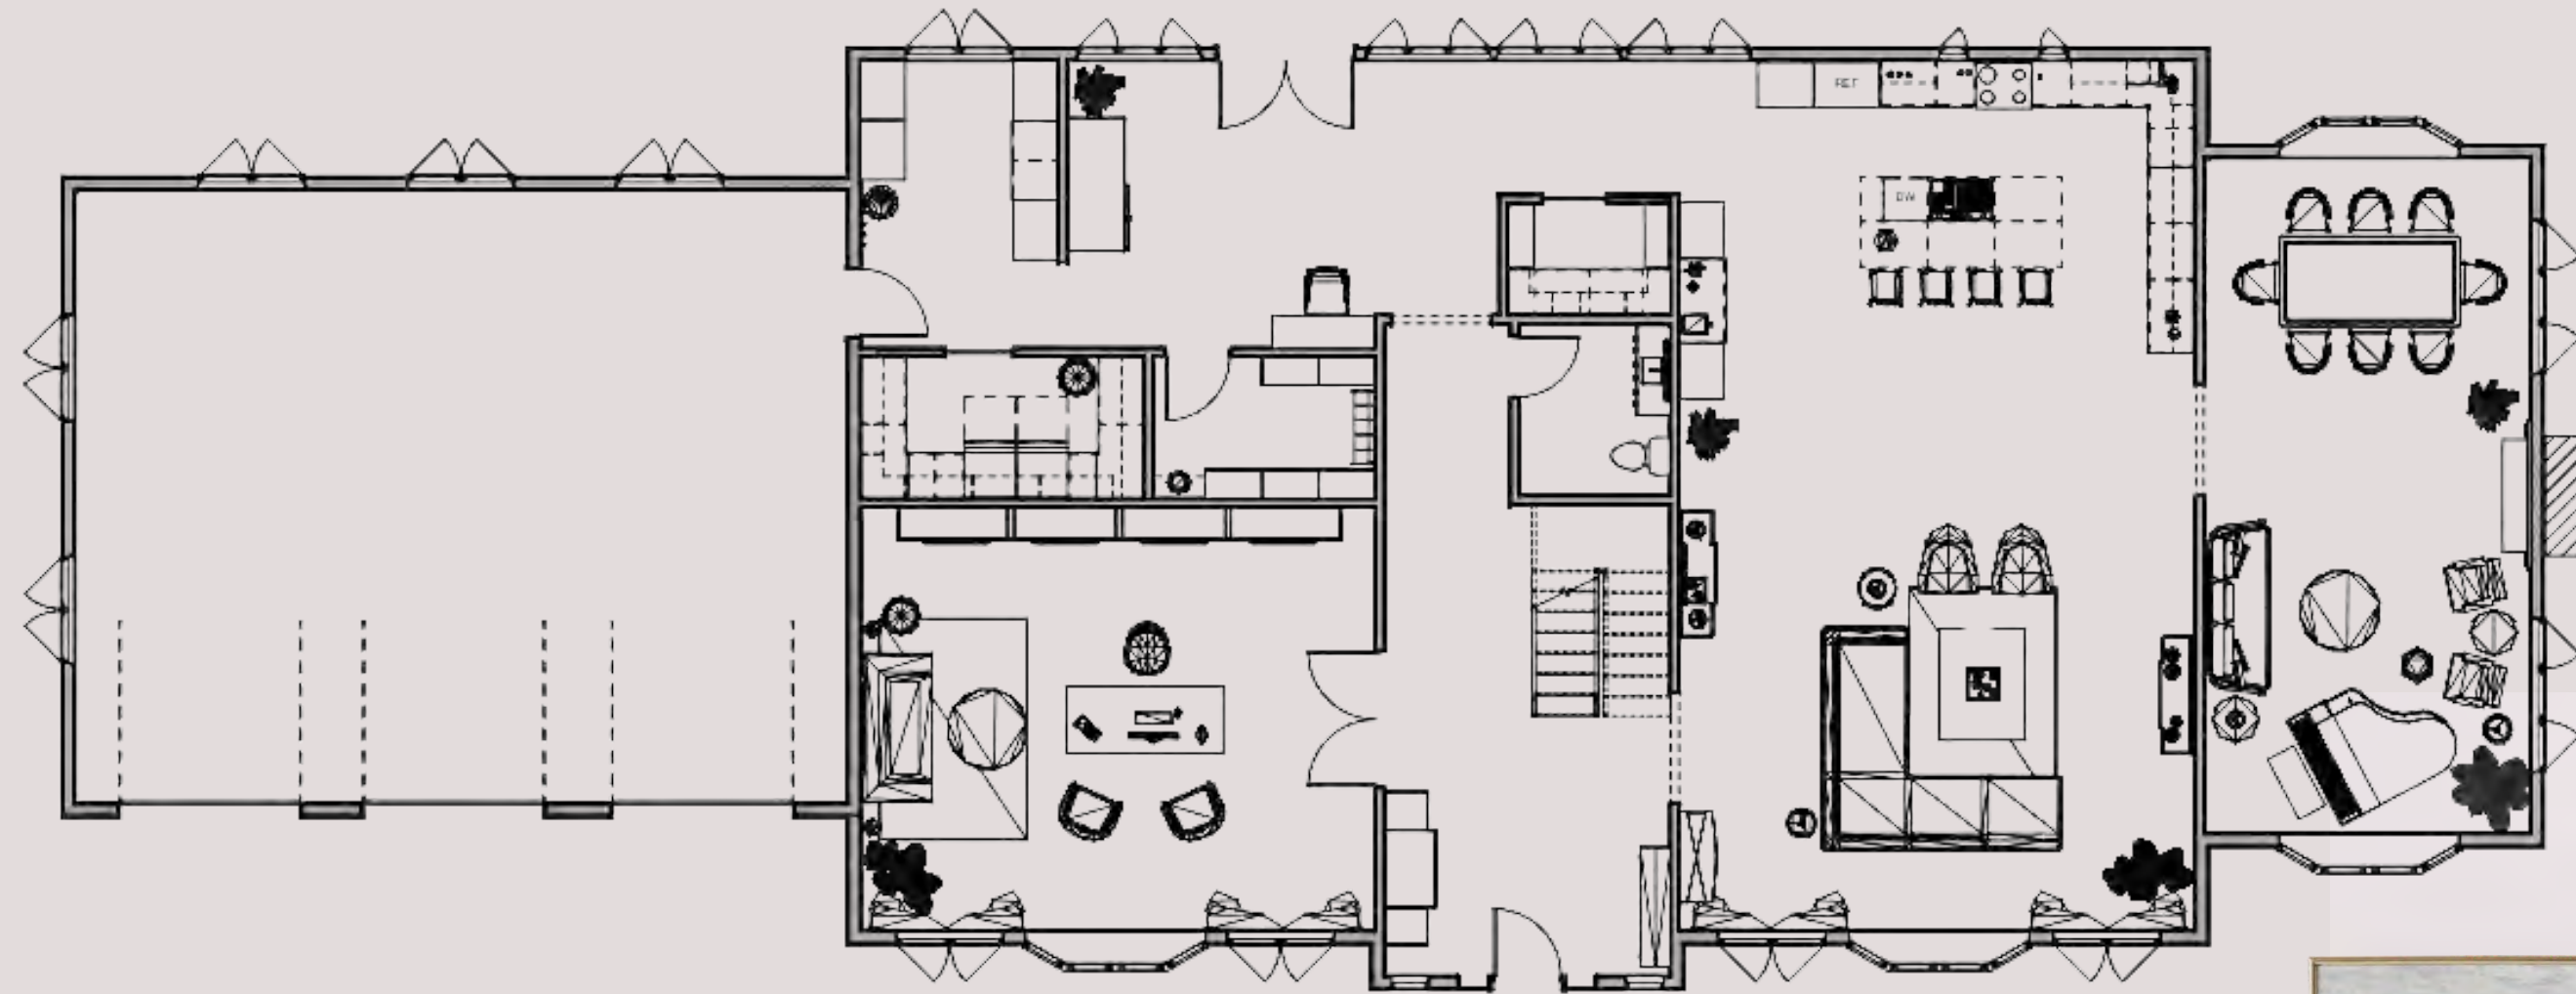

INSPIRATION



PERSPECTIVES

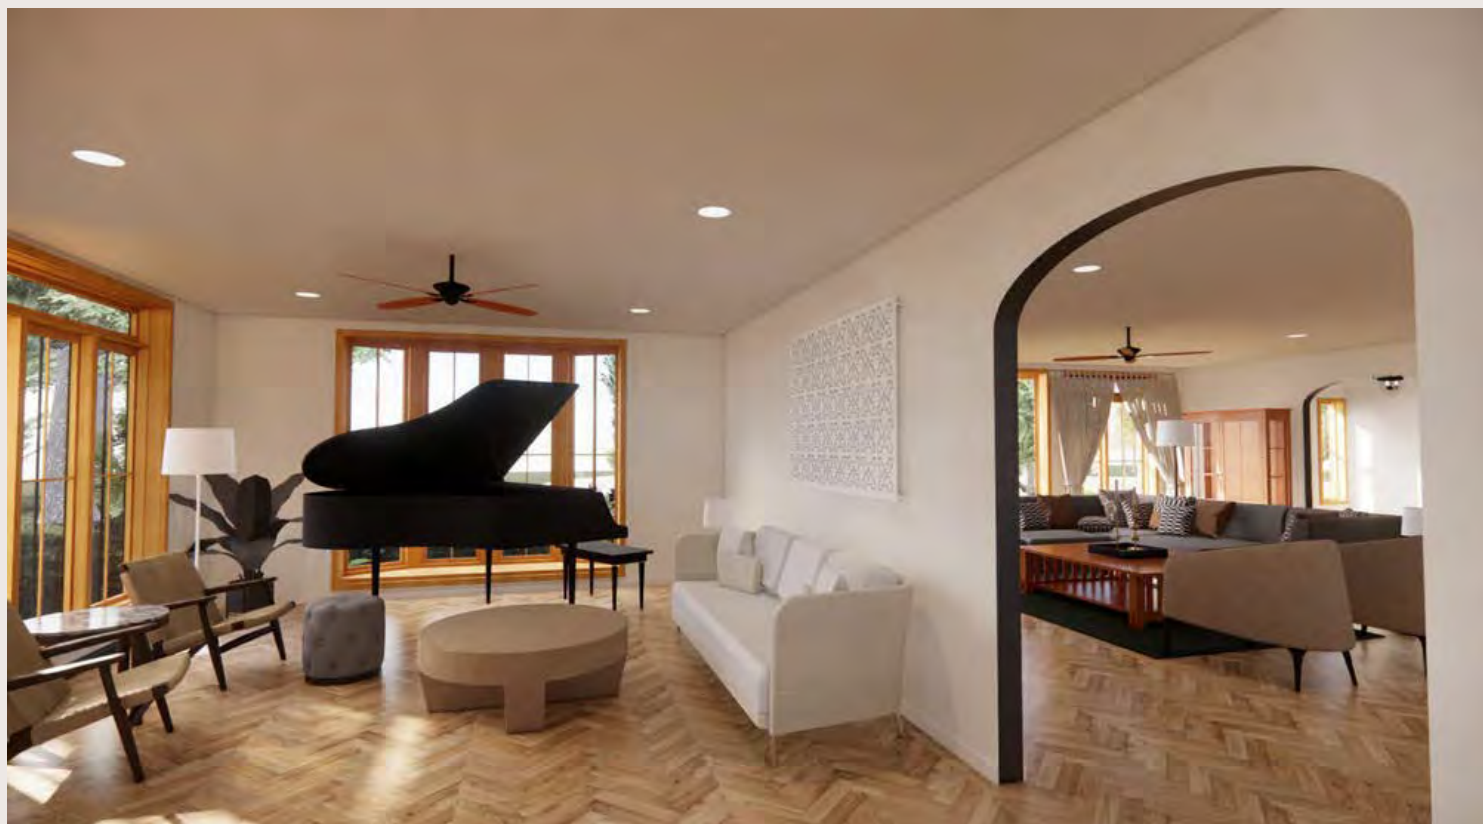

SUPPORTS

SW 7008
Alabaster
 Interior / Exterior
 Location Number: 255-C2





SW 7014
Eider White
 Interior / Exterior
 Location Number: 256-C5



SW 6468
Hunt Club
 Interior / Exterior
 Location Number: 160-C7



SW 6994
Greenblack
 Interior / Exterior
 Location Number: 251-C6

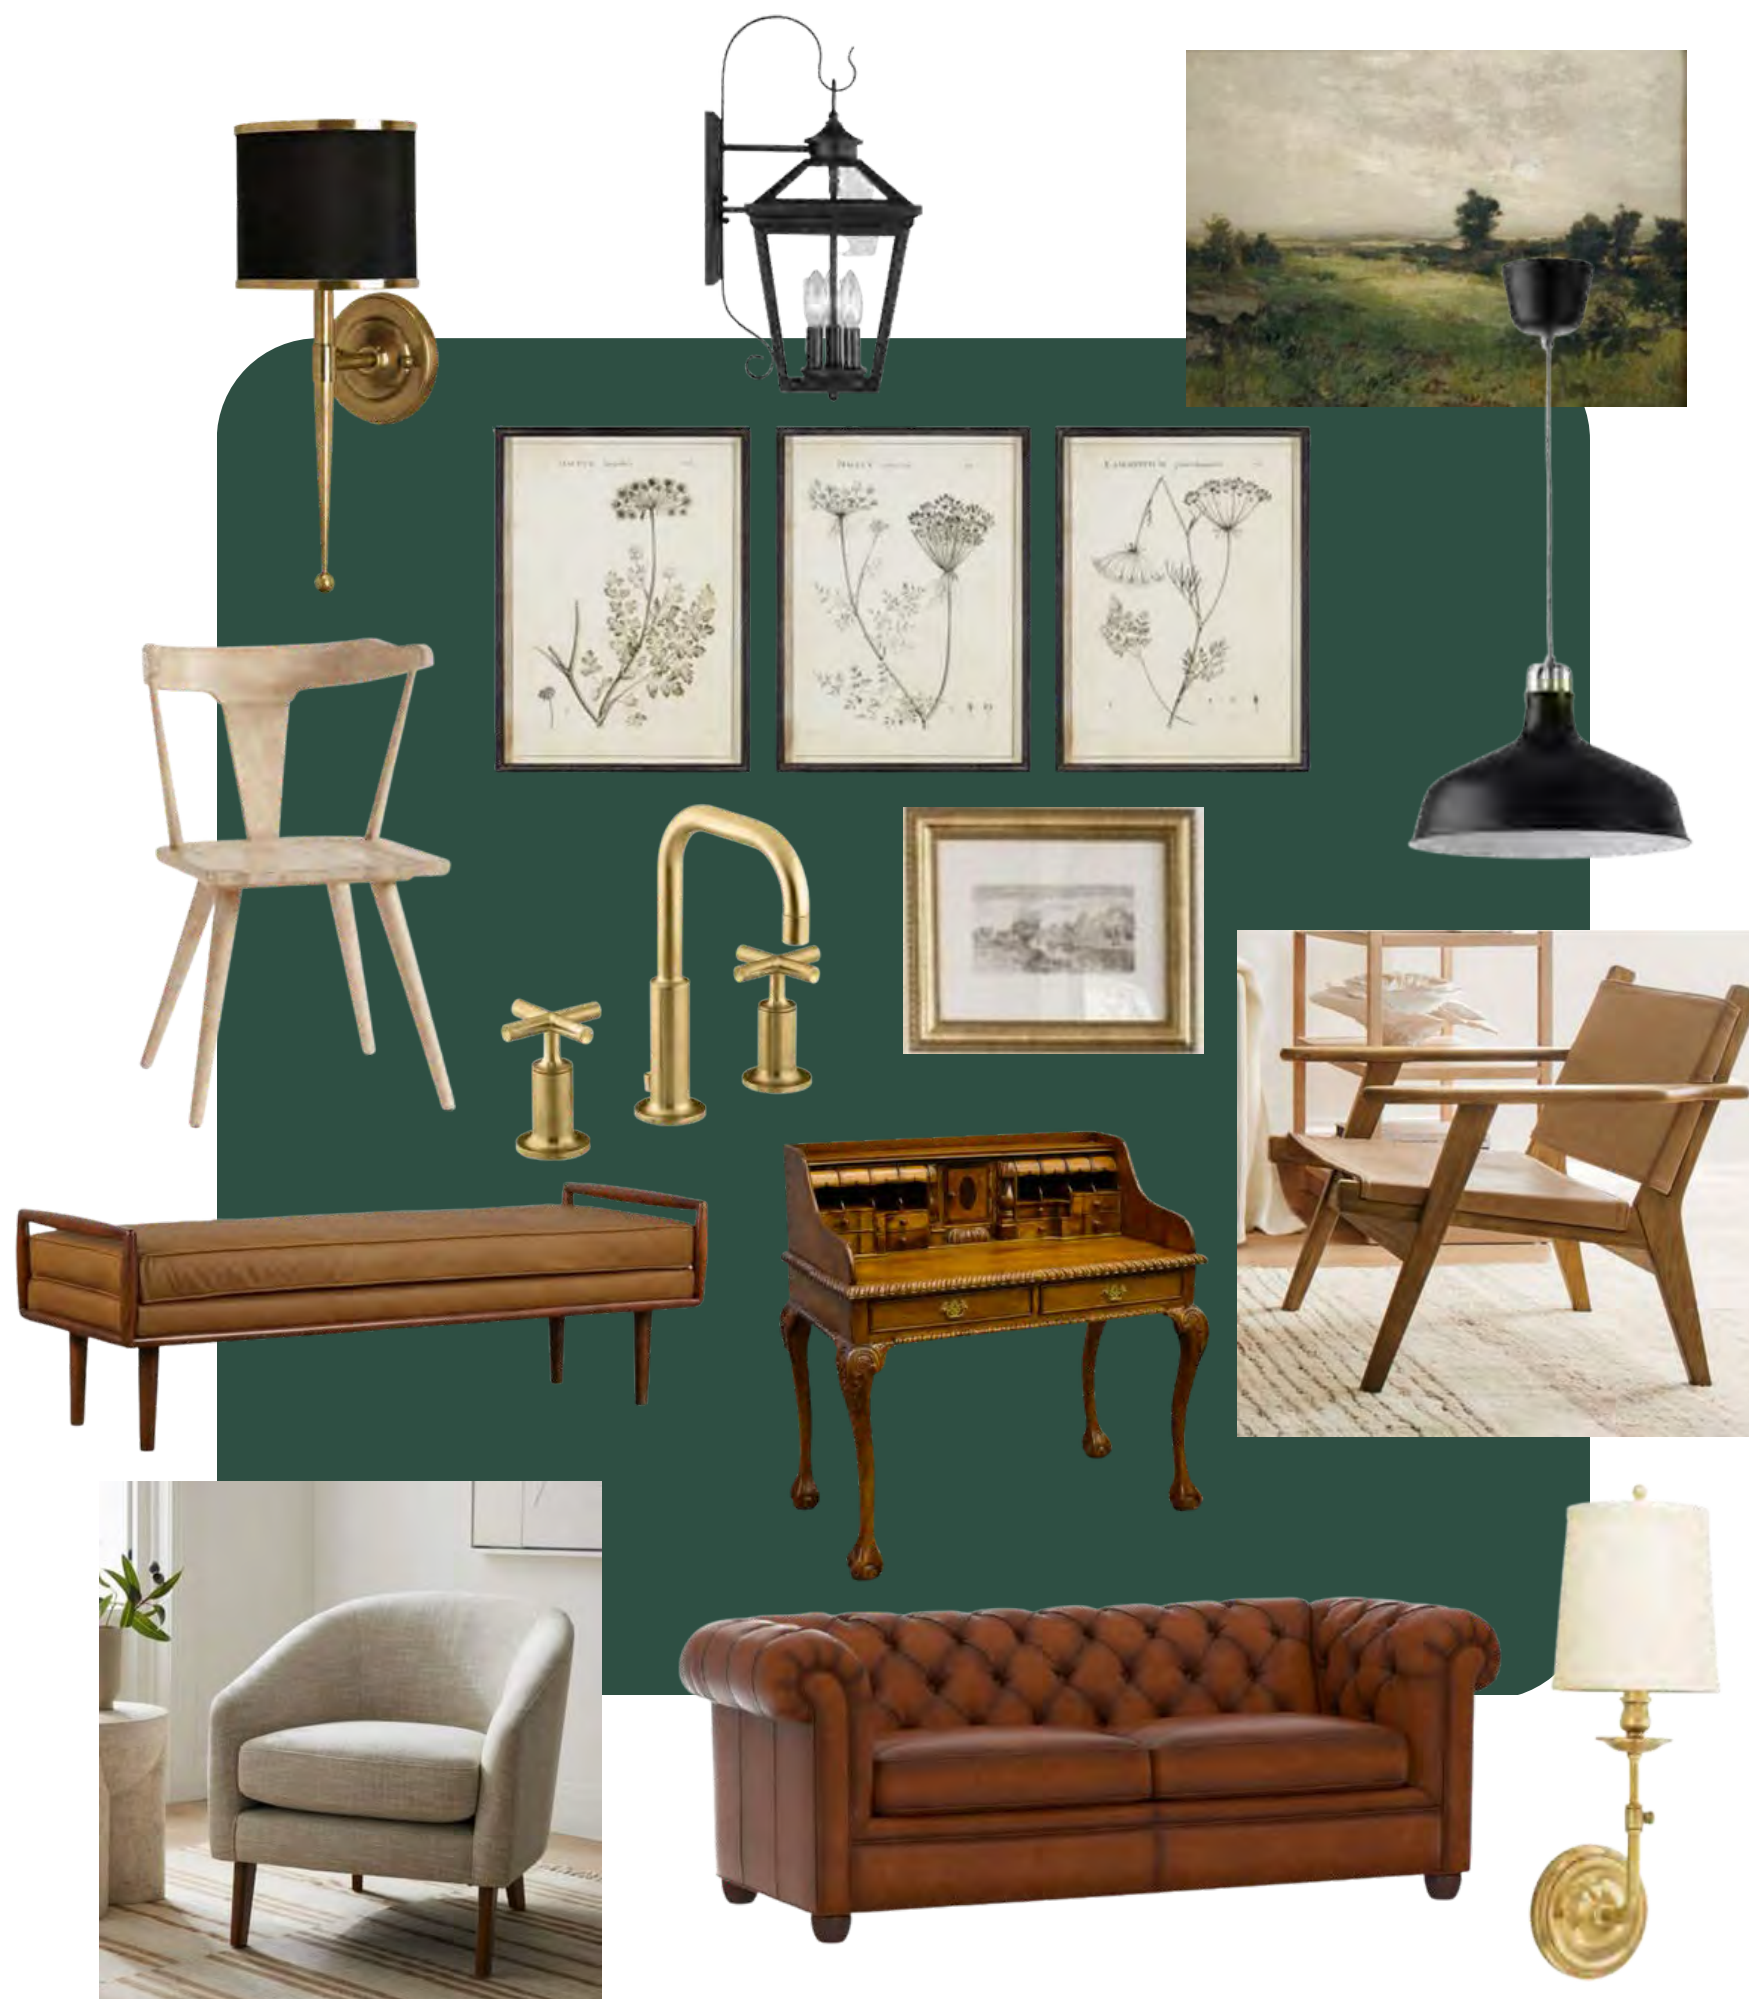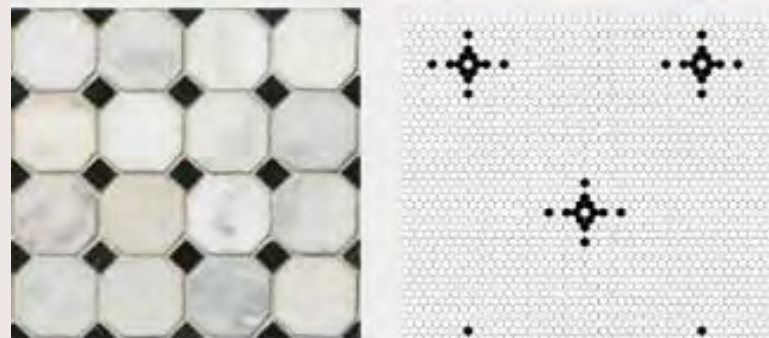


TRAMMEL DESIGNS

Designed a tenant improvement space of 5300 square feet for an advertising firm located in Dallas, TX



- AutoCad 2022
- CD Set
- Space planning
- Specifications
- Elevations
- Wall sections



INSPIRATION

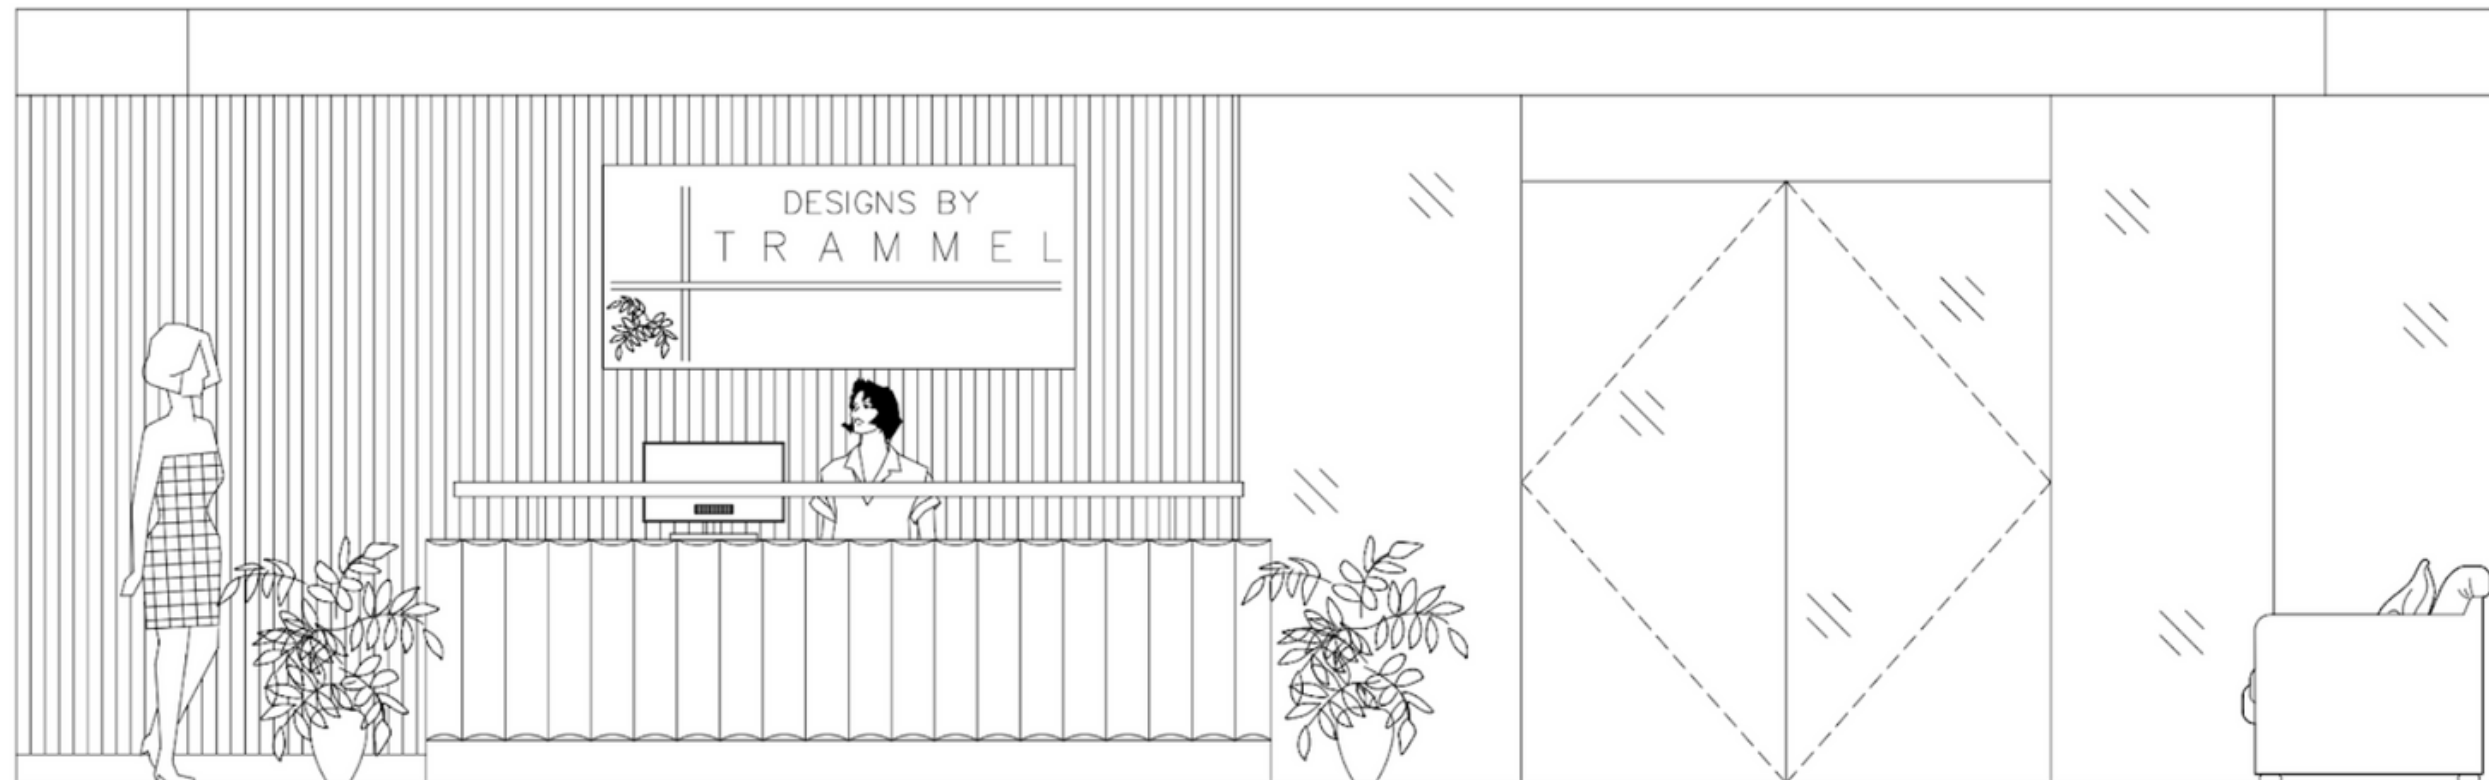


FLOOR PLAN & SPECIFICATIONS

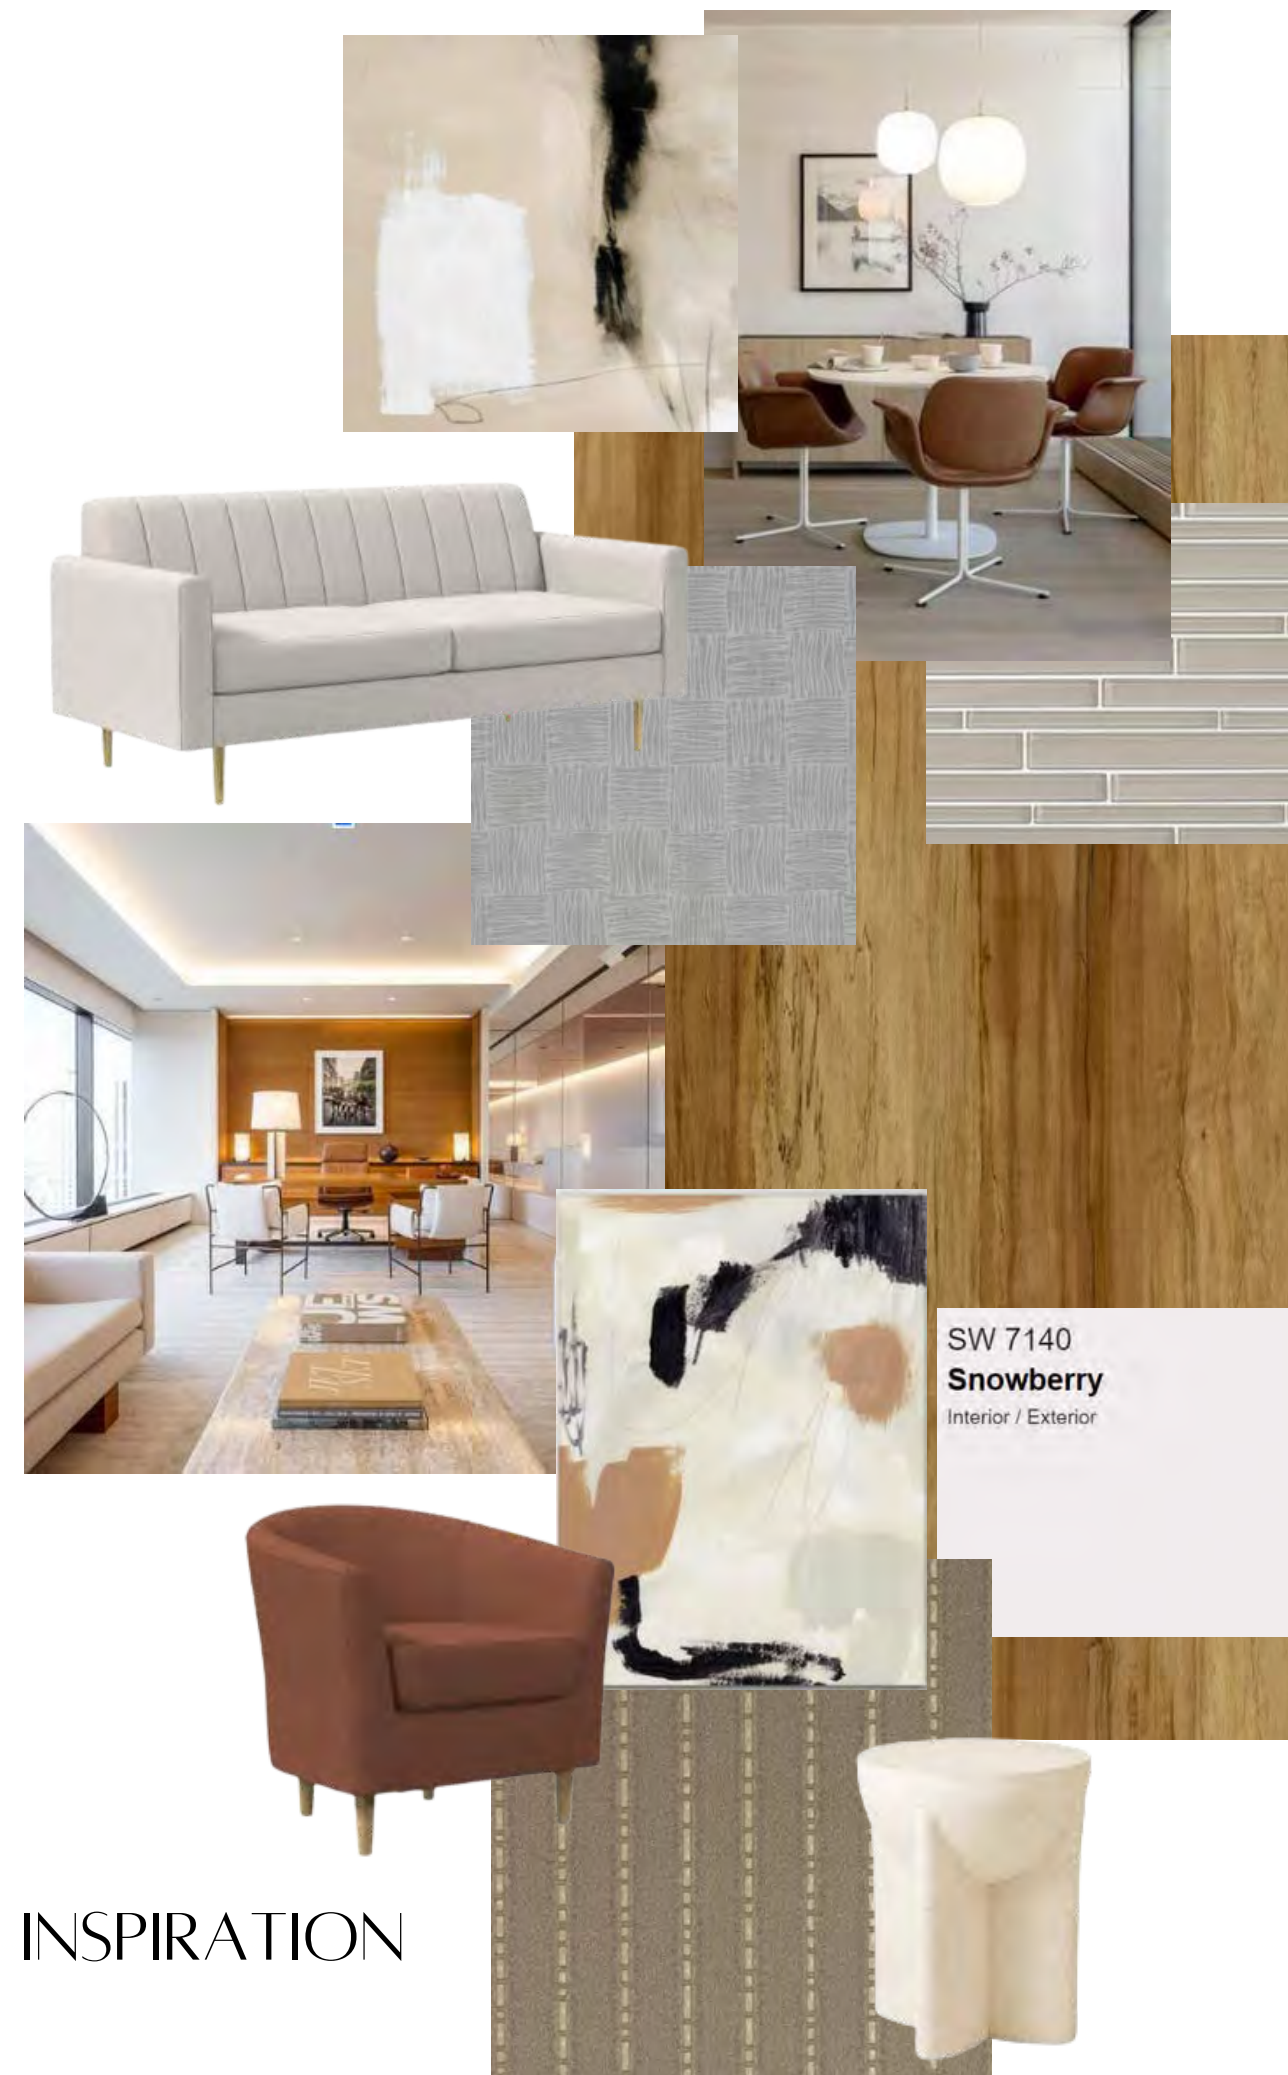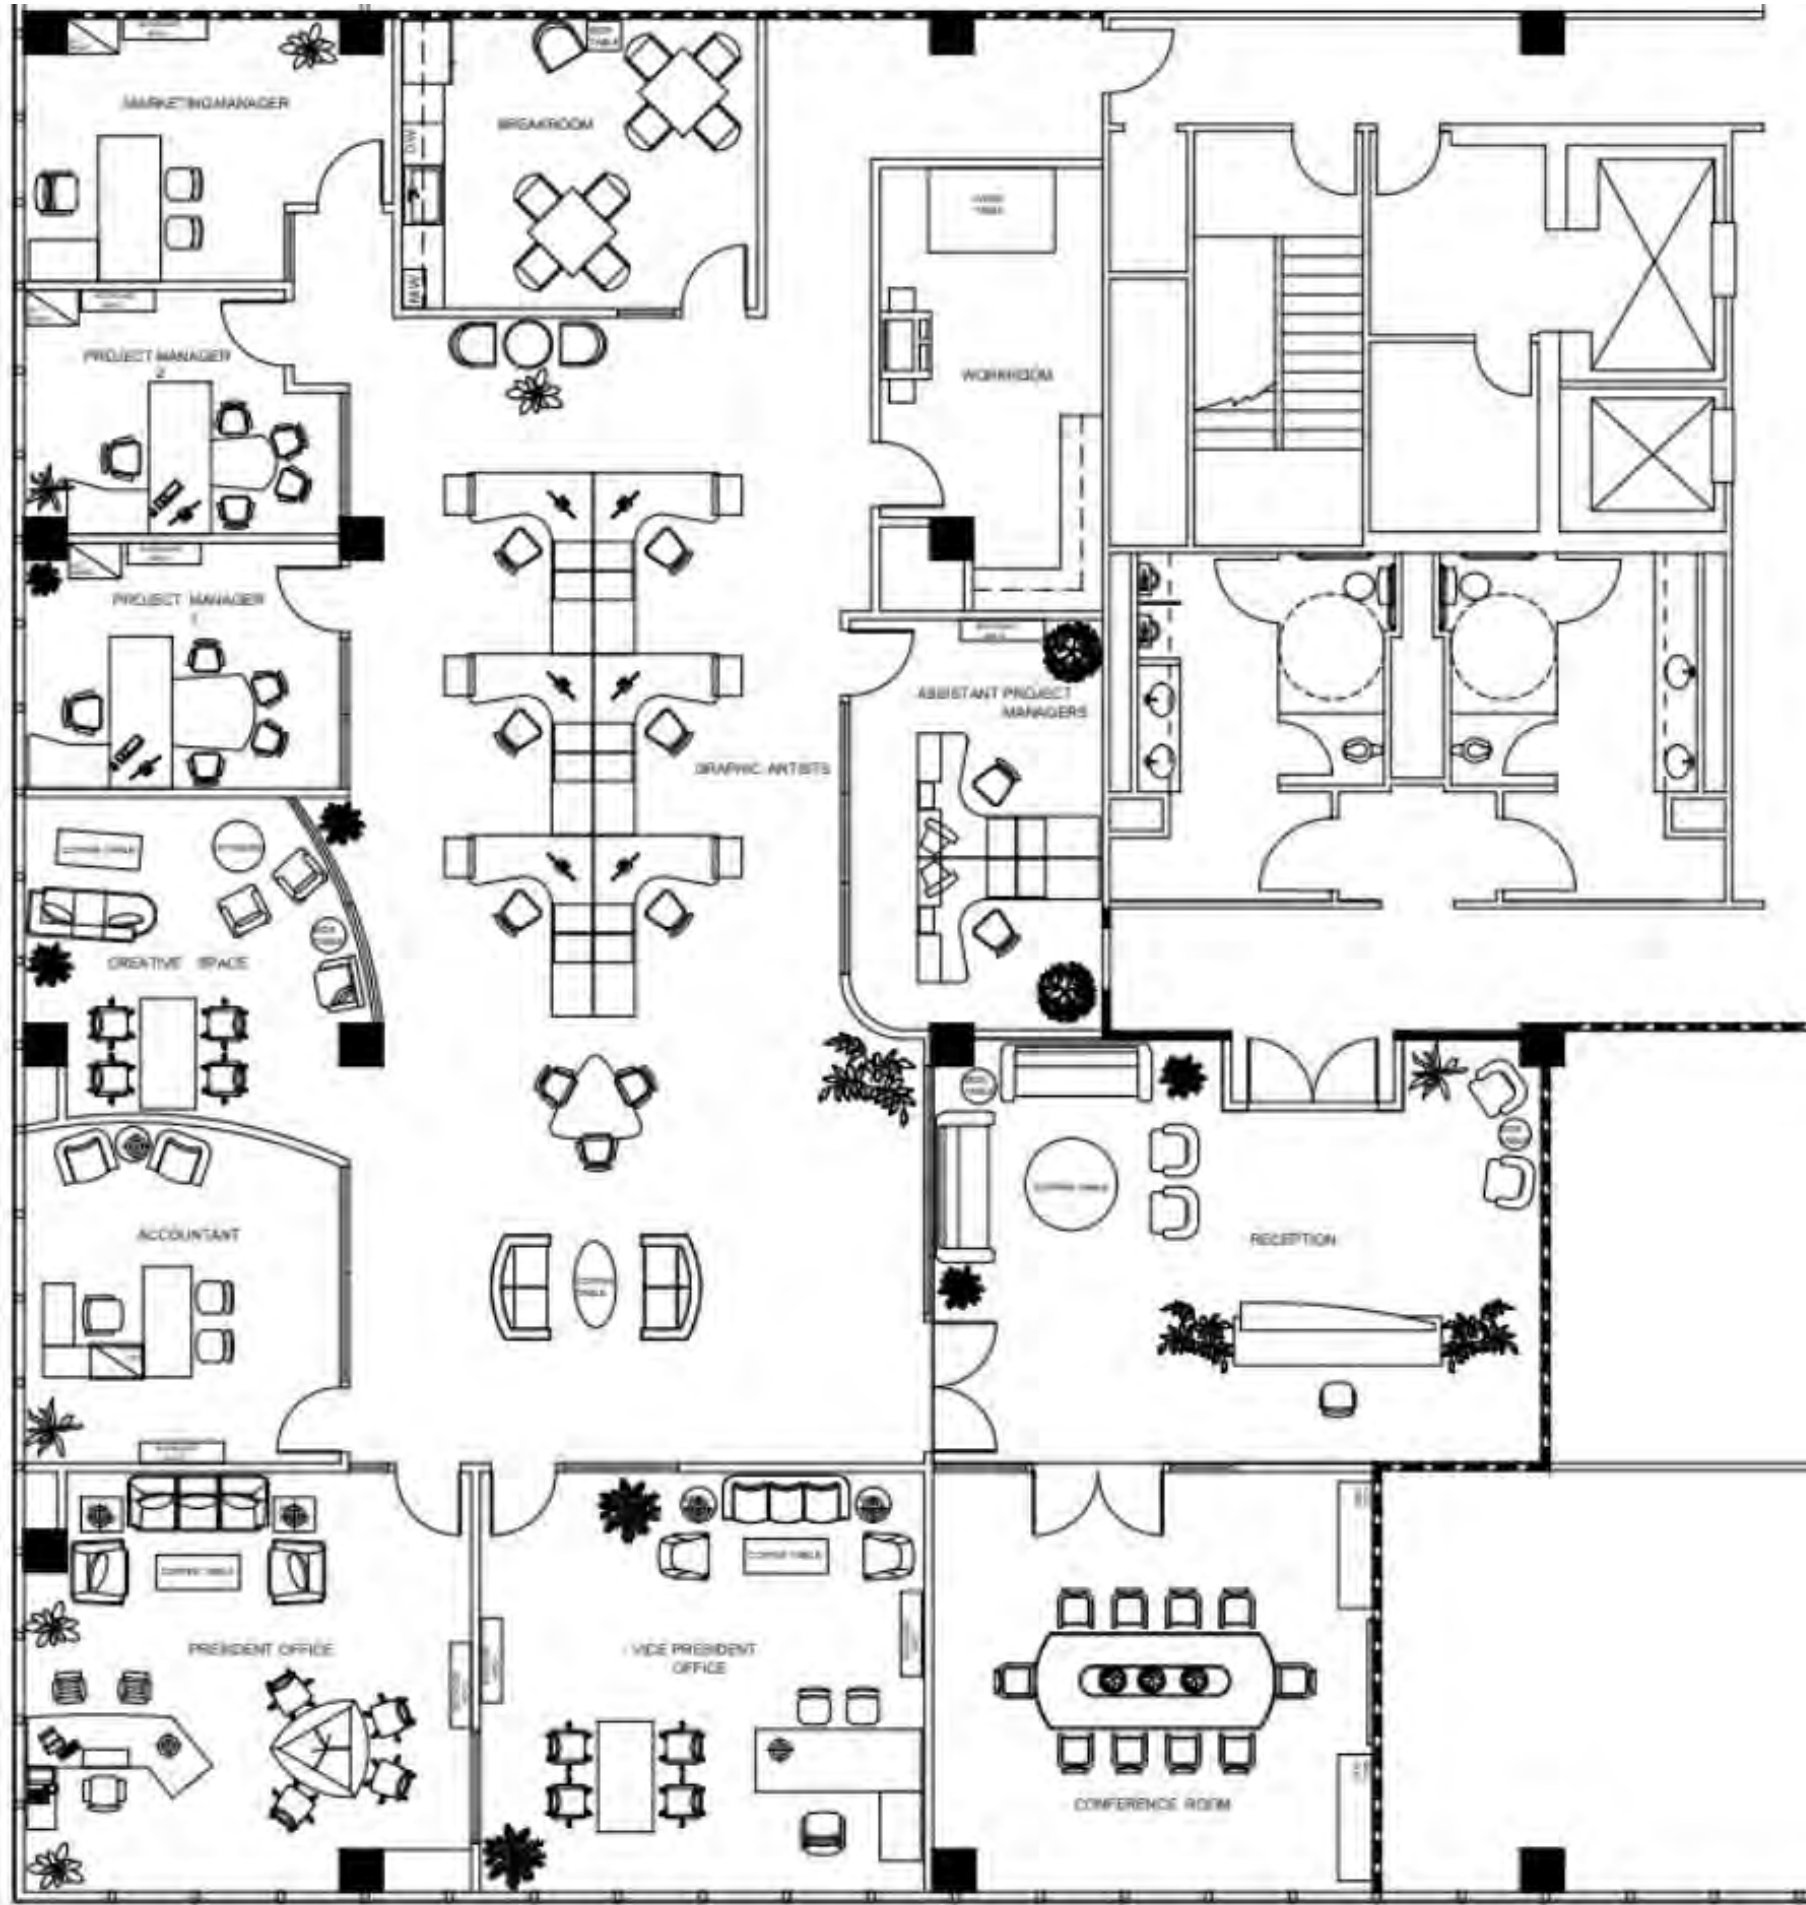


SW 7140
Snowberry
Interior / Exterior


FINISH PLAN

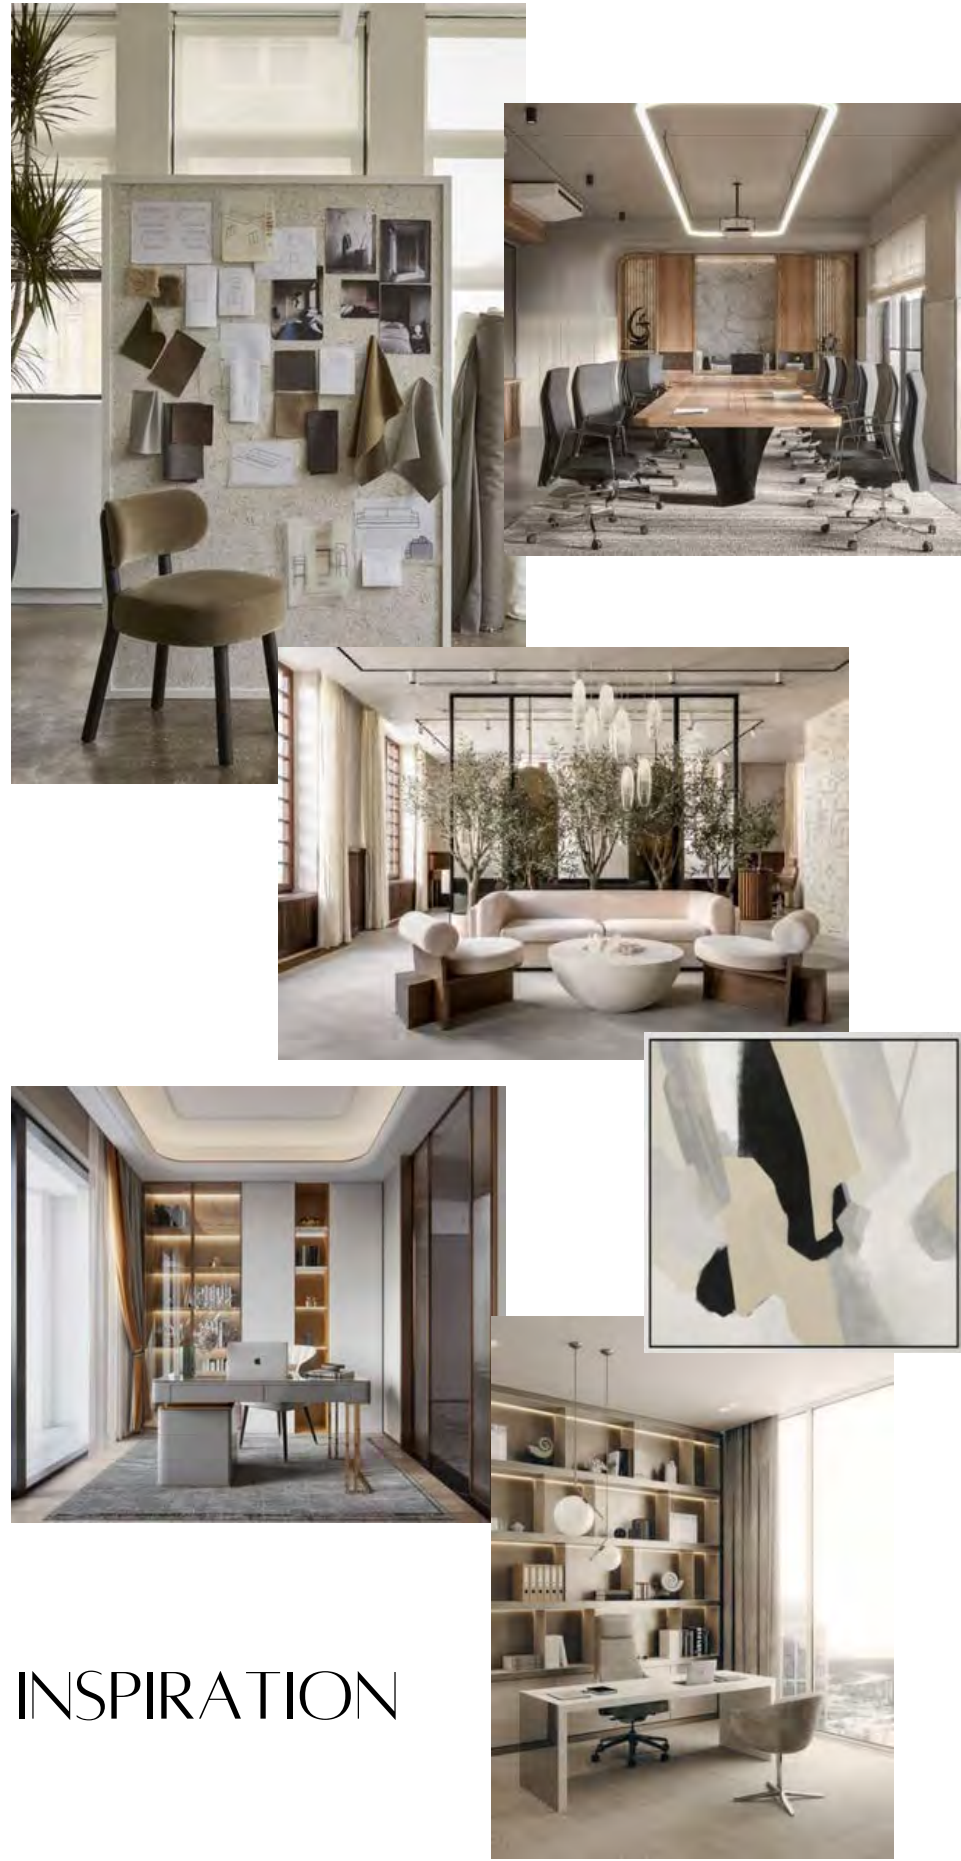


INSPIRATION

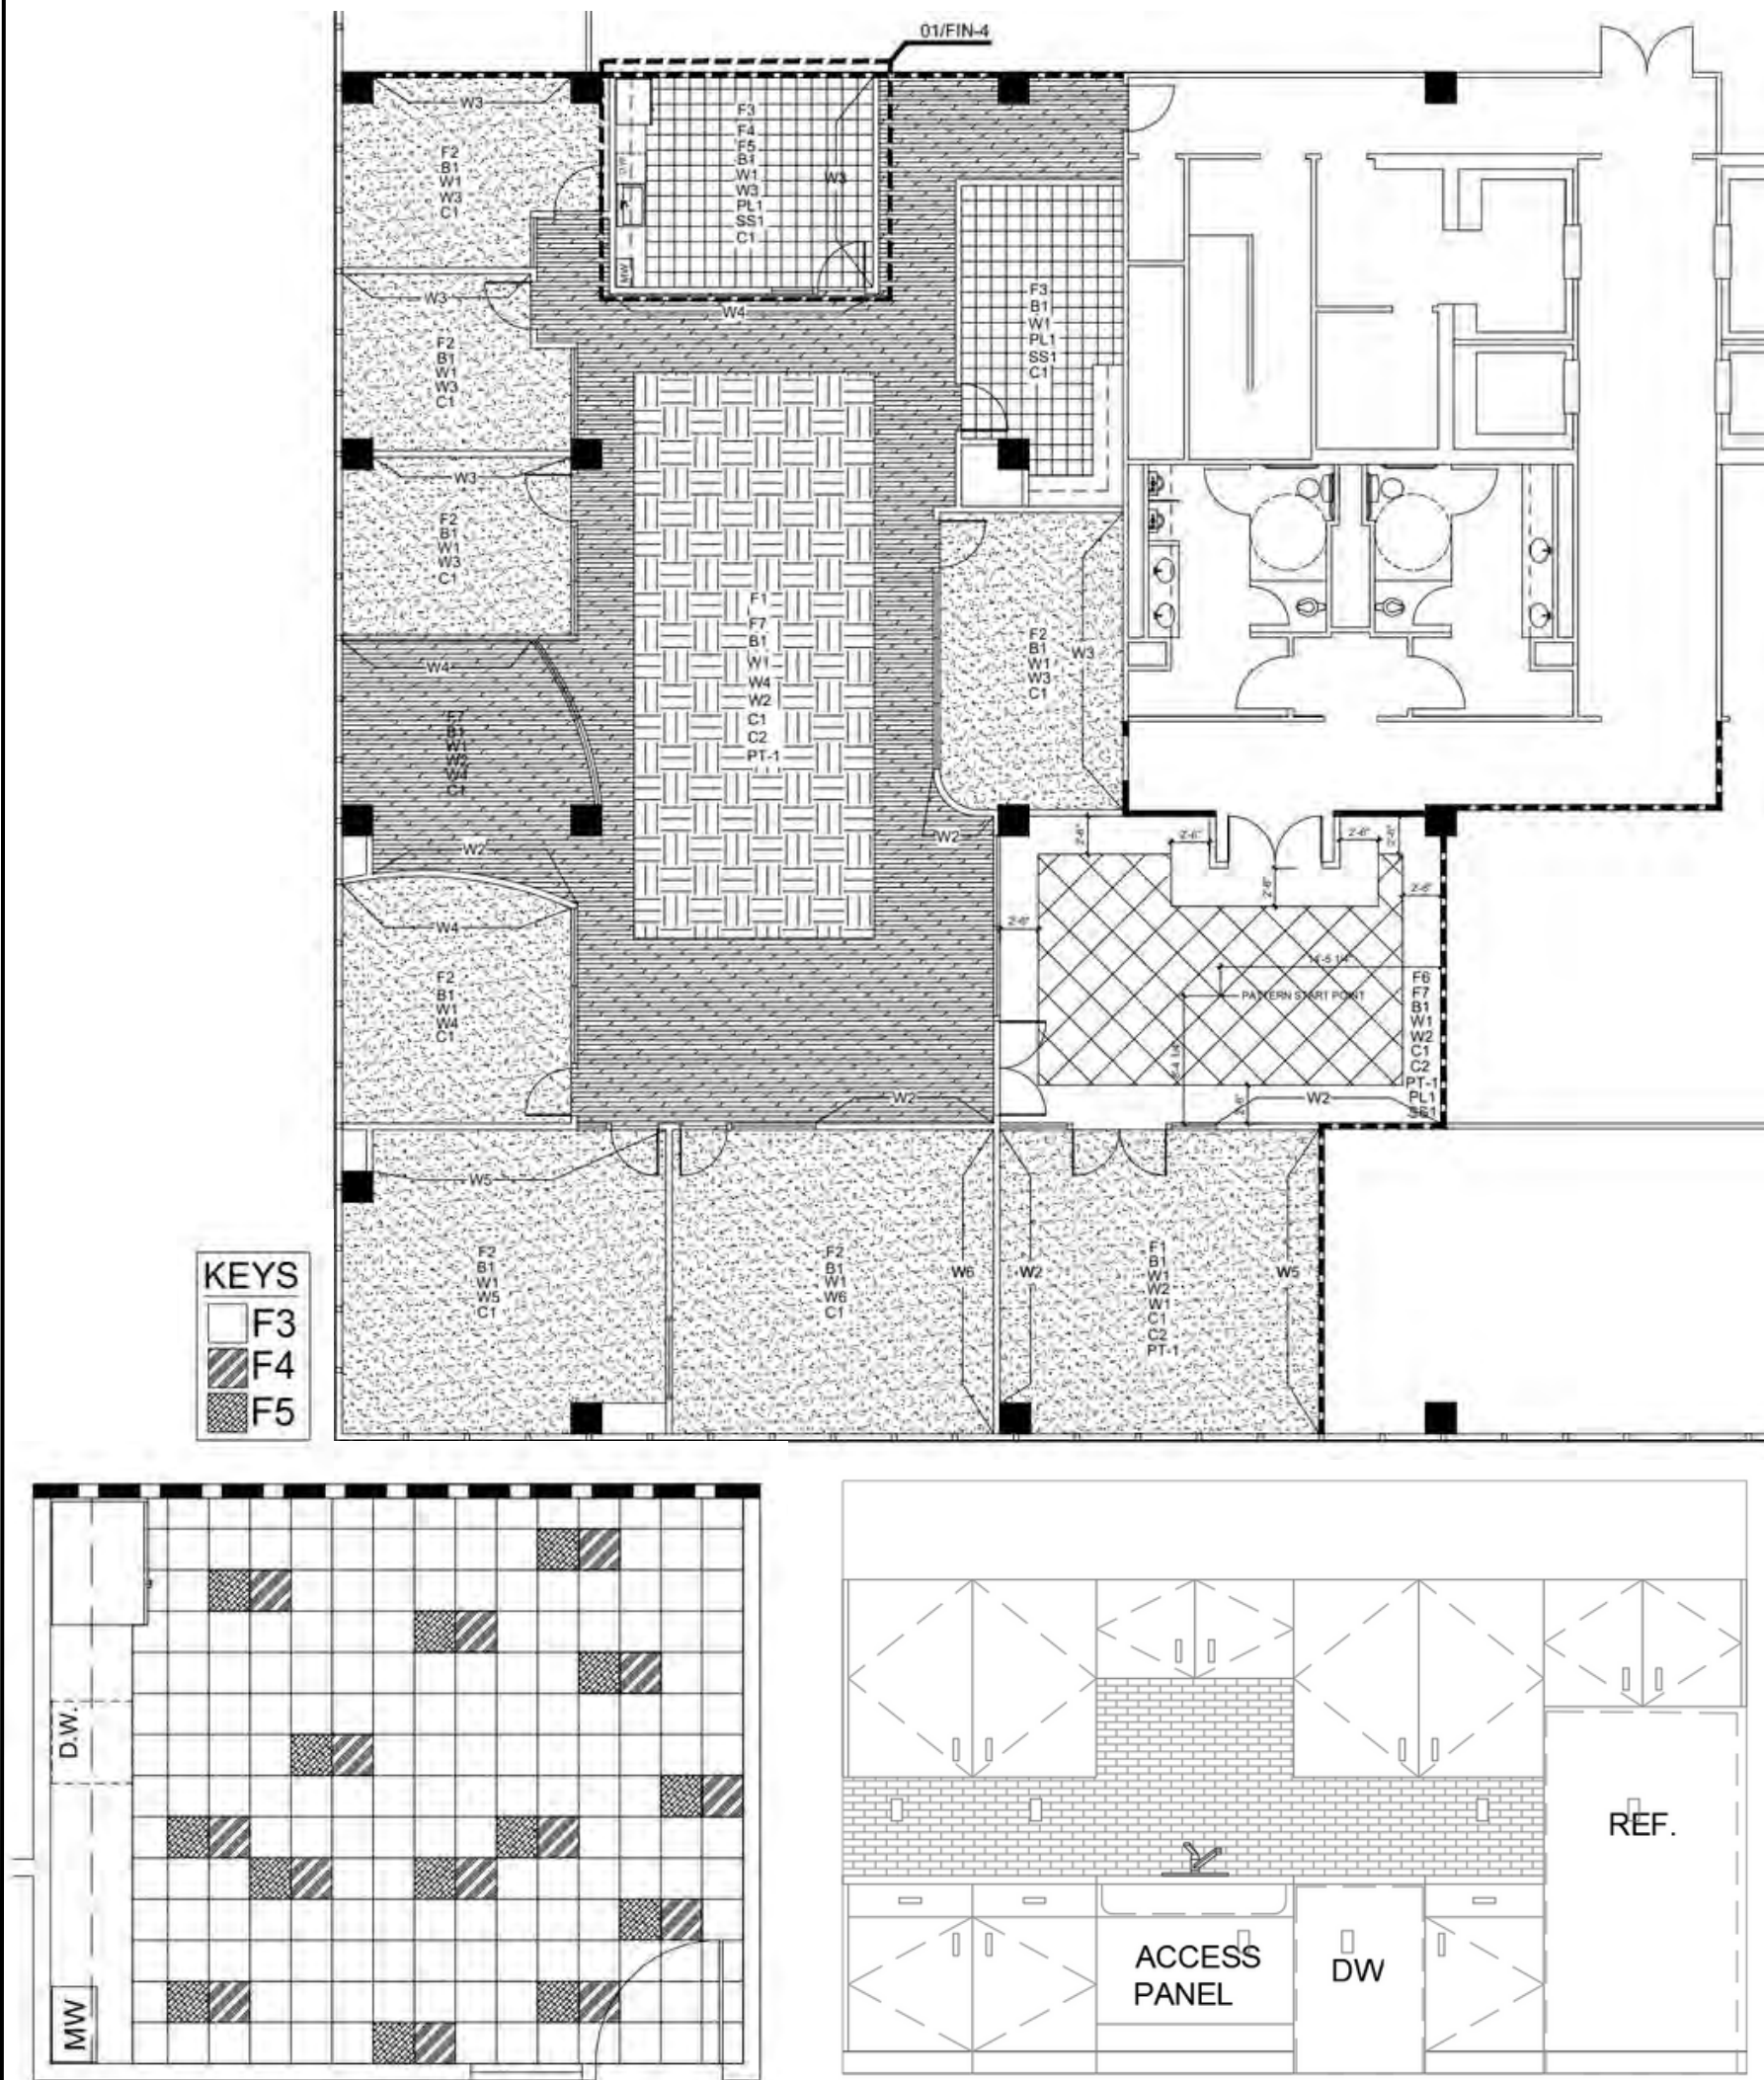


WALL SECTIONS

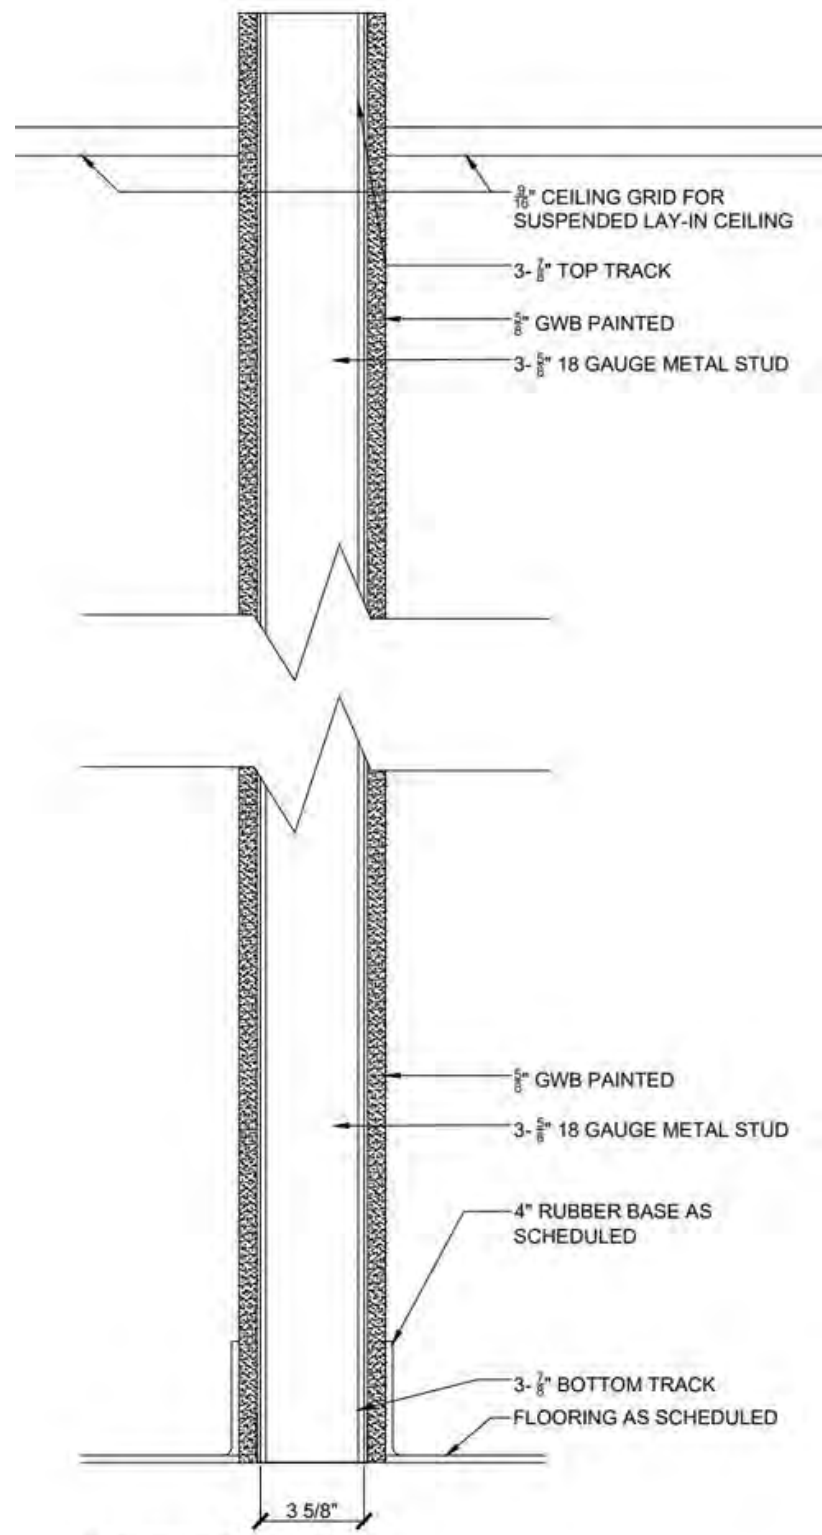

STANDARD WALL SECTION

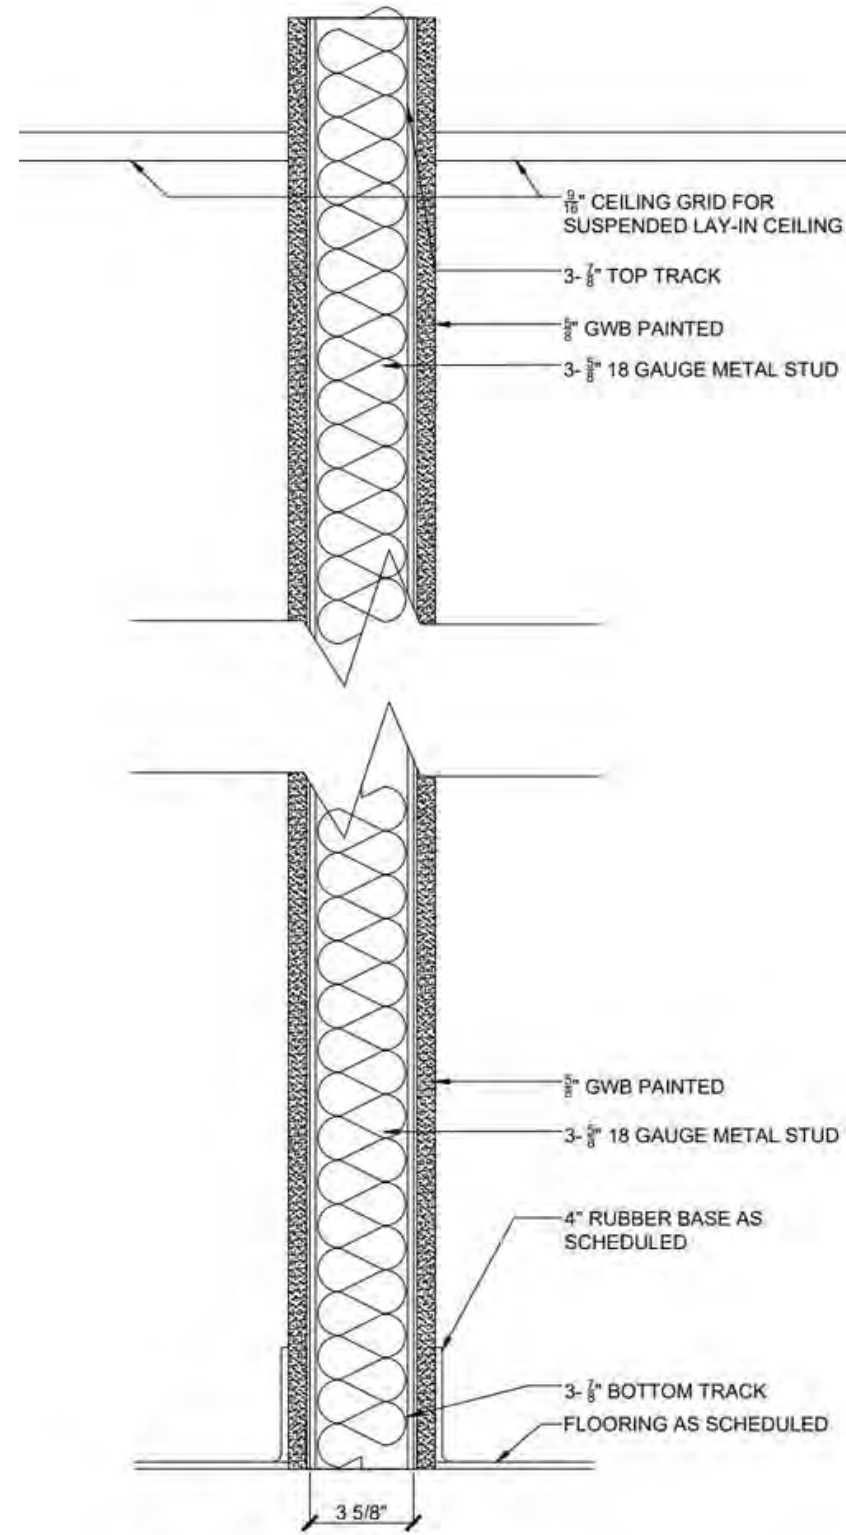

INSULATED WALL SECTION

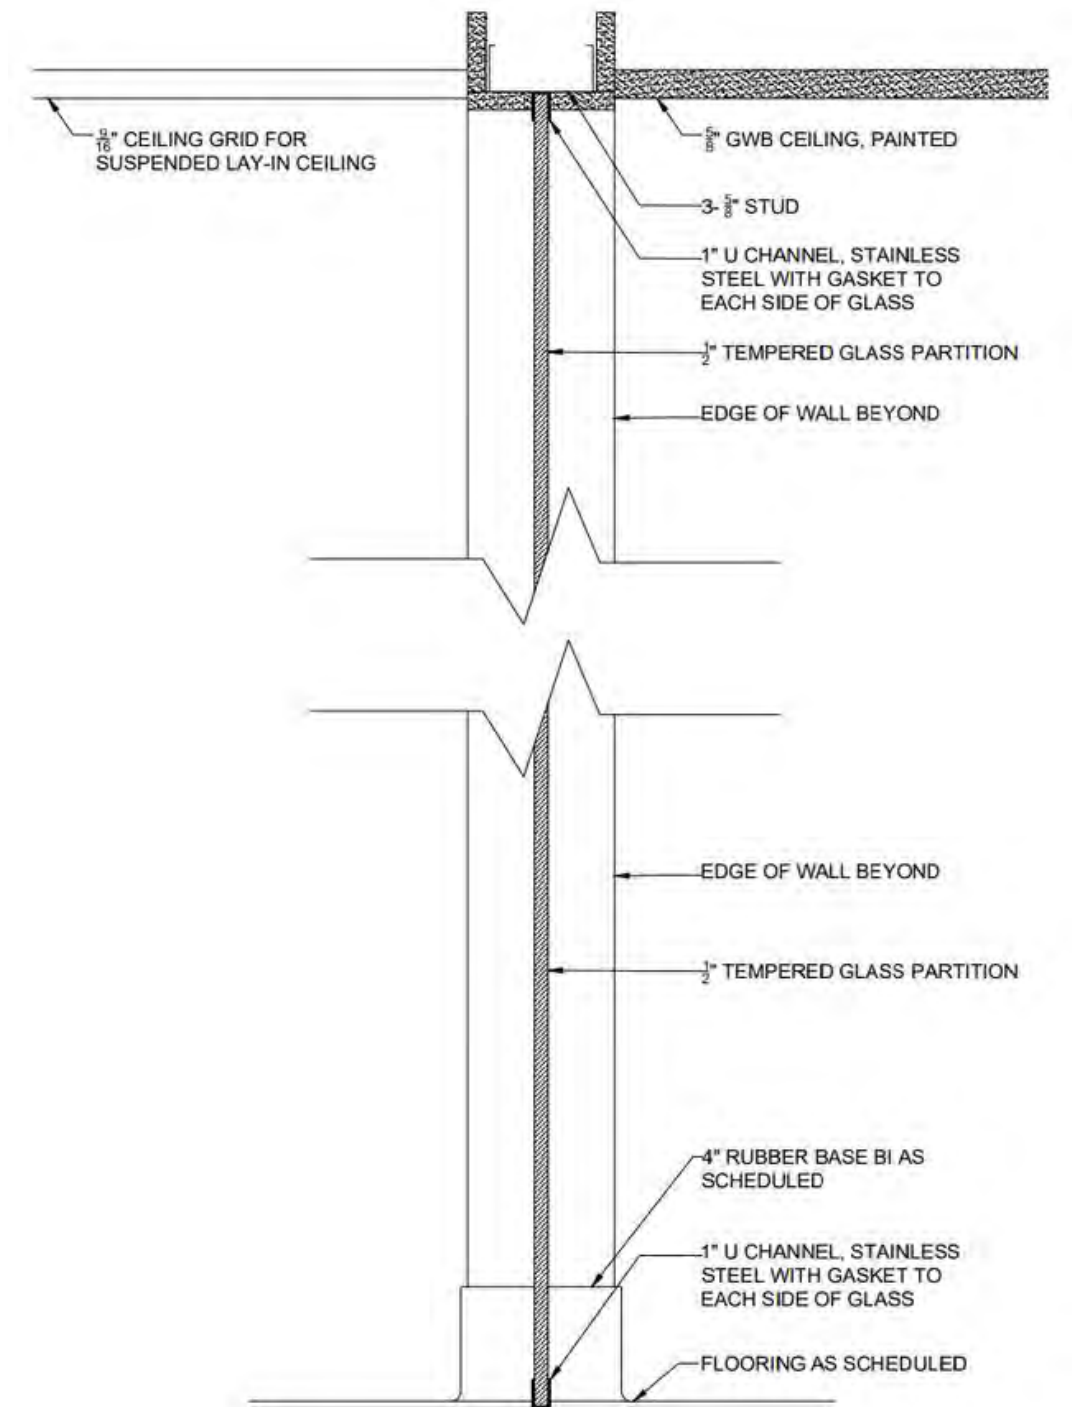


GLASS PARTITION SECTION


JONES RESIDENCE

Designed a single level
1,800 square foot home
located in Atlanta, GA


- AutoCad 2020
- CD Set
- Dimensions
- Roof Plan
- Finish Plan
- Details
- Interior and Exterior Elevations
- Furniture Plan
- FF & E Selections
- Lighting & Electrical Plans with Legends

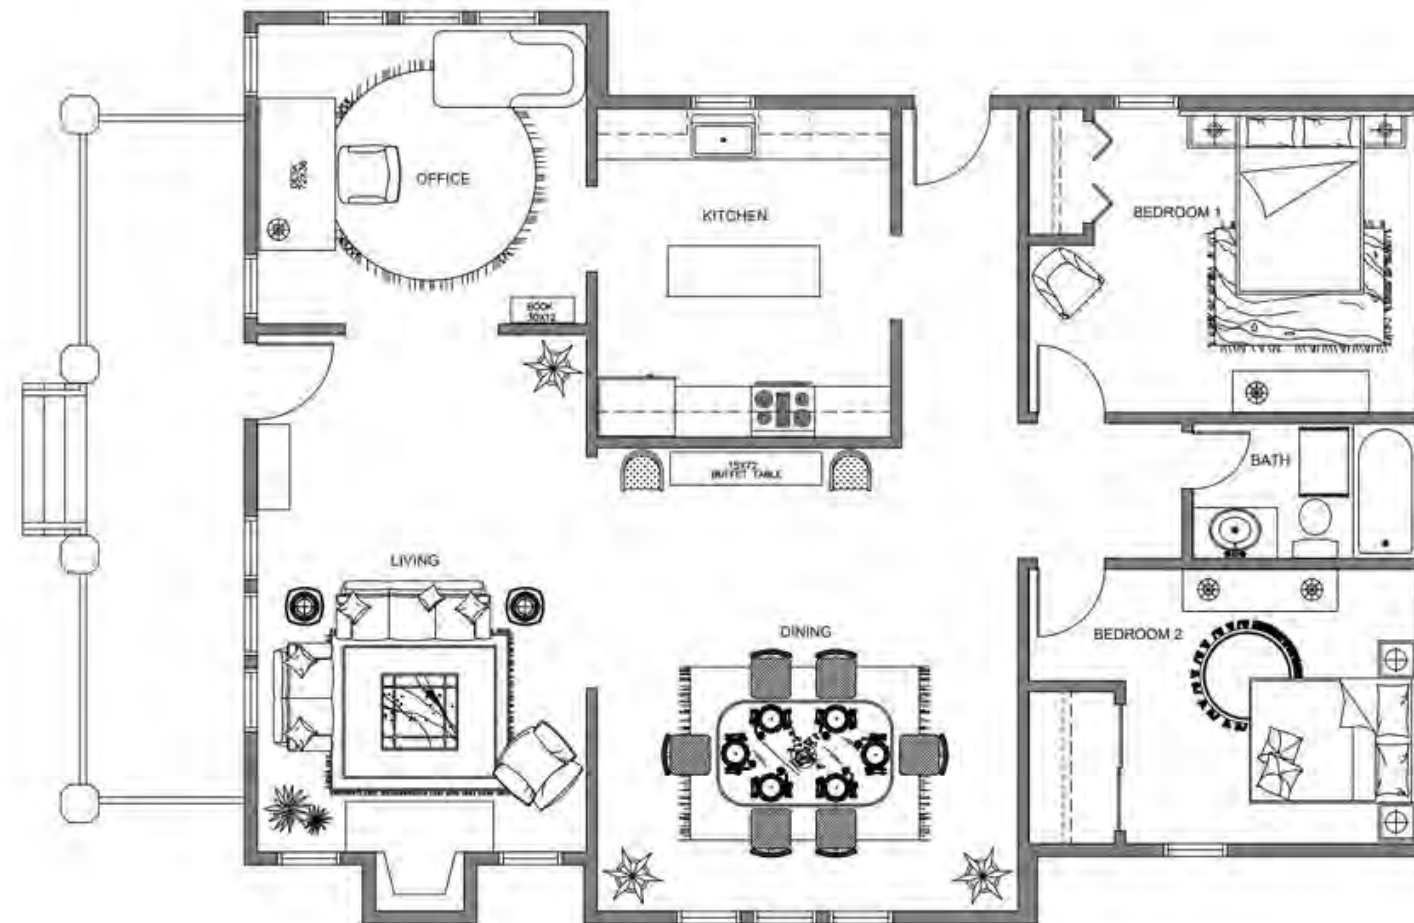


ELEVATIONS

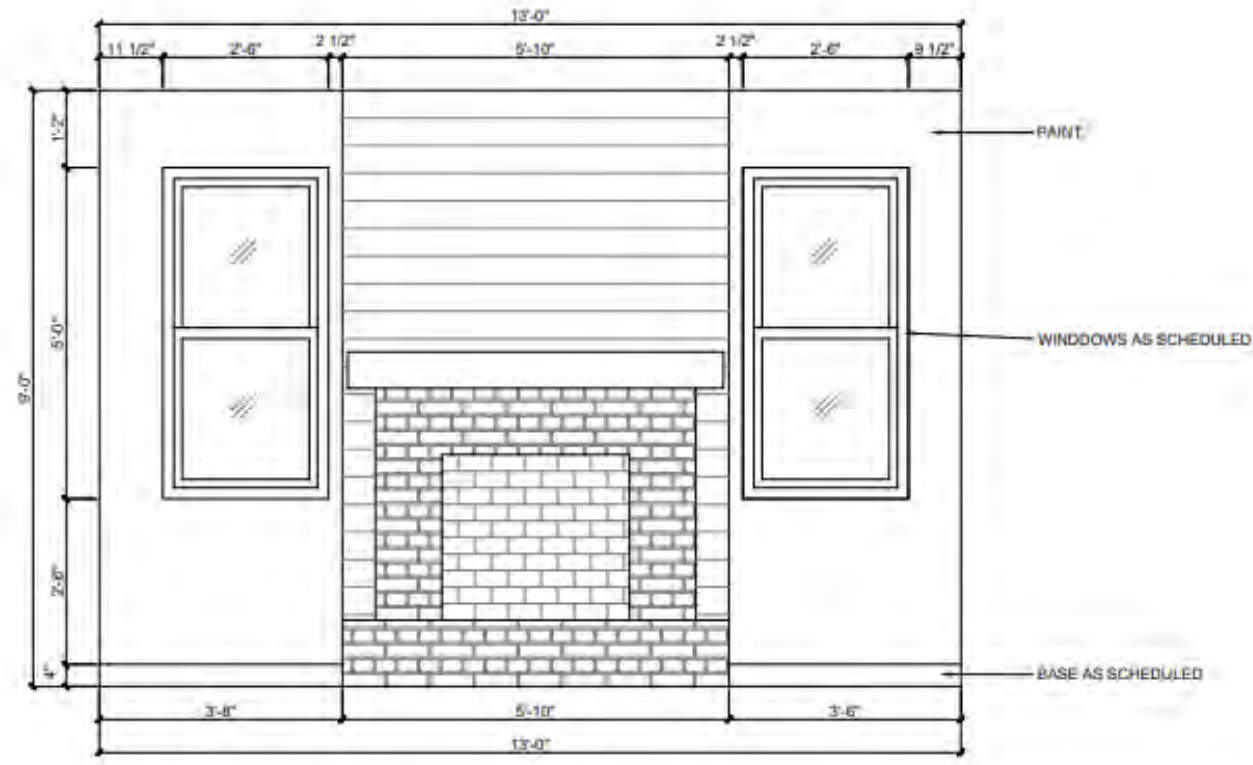

C FIREPLACE ELEVATION
SCALE: 3/8" = 1'-0"

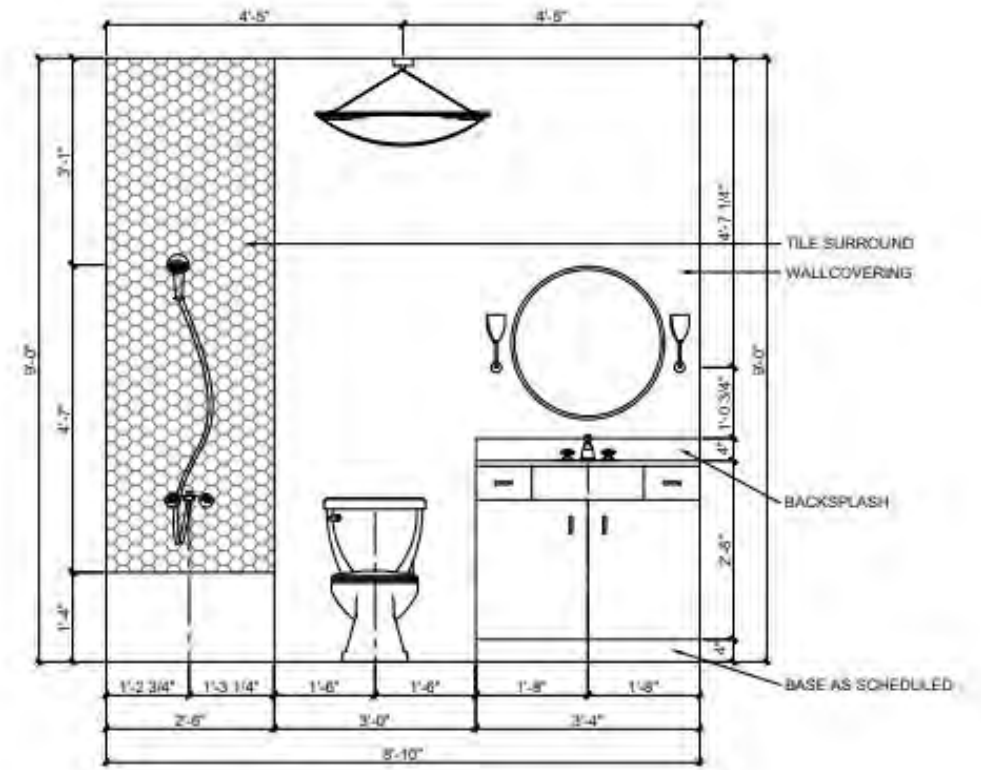

C BATHROOM ELEVATION
SCALE: 3/8" = 1'-0"

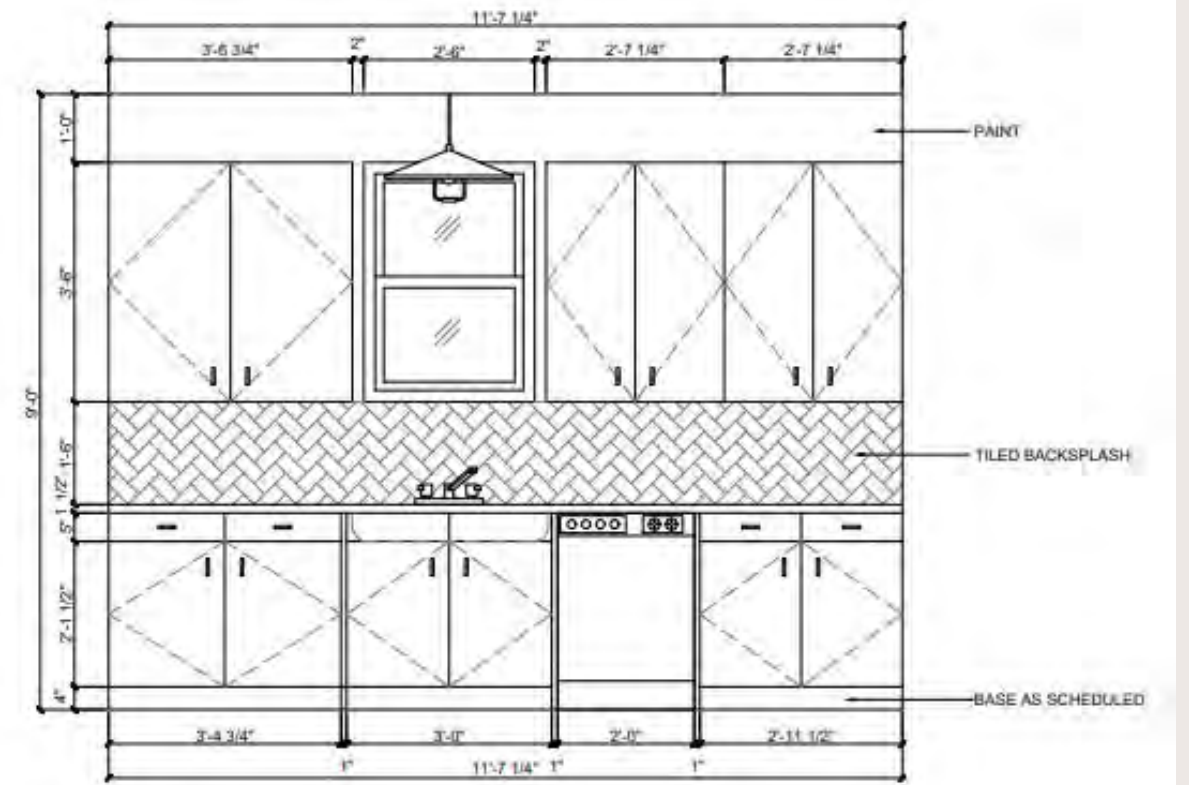

A KITCHEN ELEVATION
SCALE: 3/8" = 1'-0"

HAND RENDERINGS

PROFESSIONAL WORK



HAND RENDERINGS

PROFESSIONAL WORK



FRONT AND REAR ELEVATIONS



HAND DRAFTING


PROFESSIONAL WORK



Team project designing a two-story, 3,185 square foot, hand drafted private residence located in Watkinsville, GA

HAND DRAFTING

PROFESSIONAL WORK

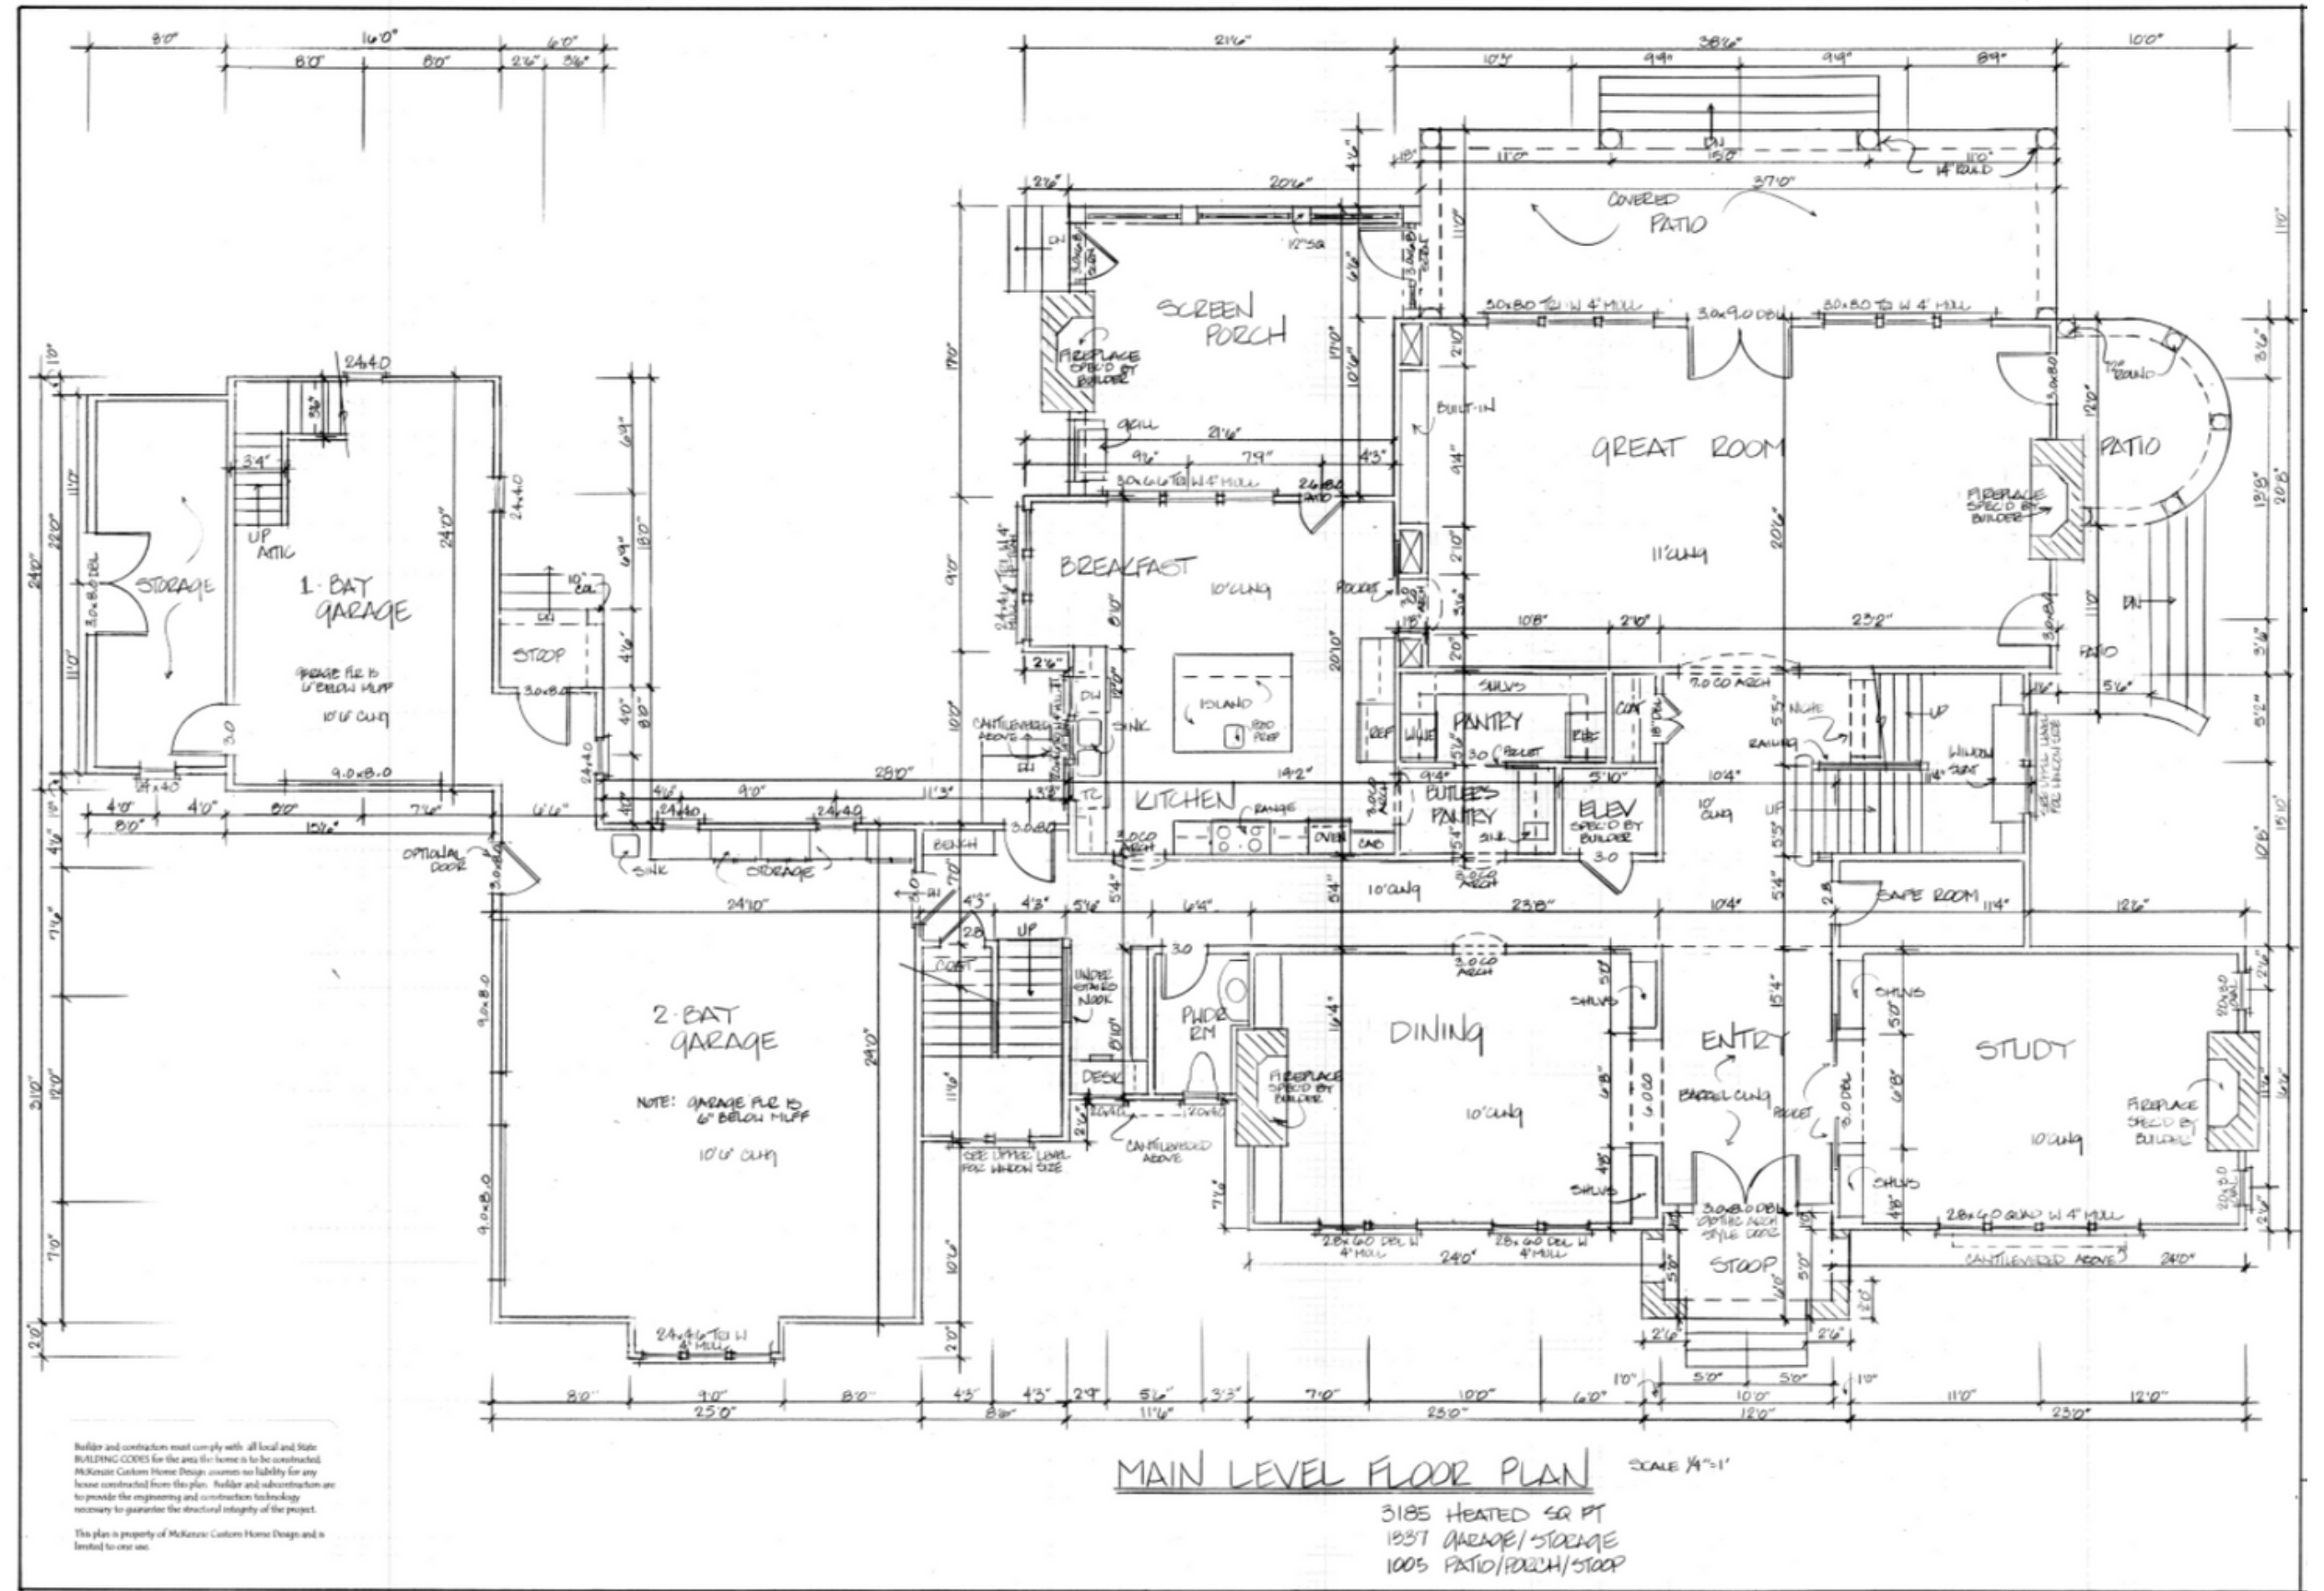

THANK YOU!

CAELAN MCKENZIE

706-817-1121

CAELANG.MCK@GMAIL.COM



CAELAN MCKENZIE
INTERIORS