

Fake Pearson

interior design portfolio



Contents

- Brown Residence
- NKBA Project
- Trammel Offices
- Jones Residence
- Train Car Reno
- Garage Cabinetry Project



Brown Residence

Designed a 3400 square foot, single-family, two-story home in Duluth, MN

- Revit 2024
- Enscape
- CD Set
- Roof and Site Plans
- Interior and Exterior Elevations
- Furniture Plan
- Specified Finishes
- Selected FF&E
- Lighting and Electrical Plans with Legends




Brown Residence



First Floor




Second Floor

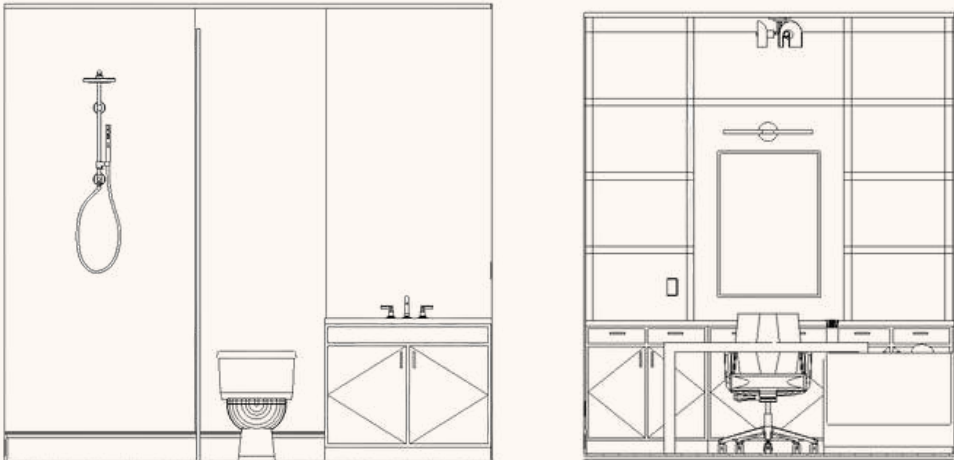

Guest Bathroom and Office Elevations



Sun Room Elevation

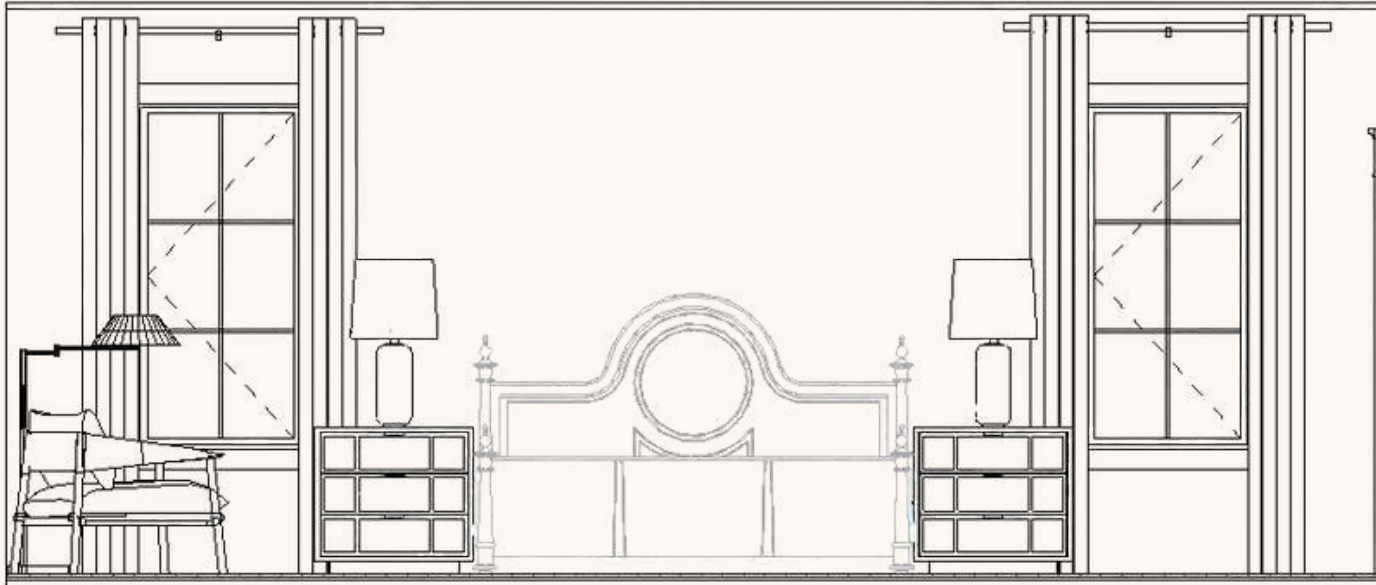


Guest Bedroom Elevation



Brown Residence



Brown Residence

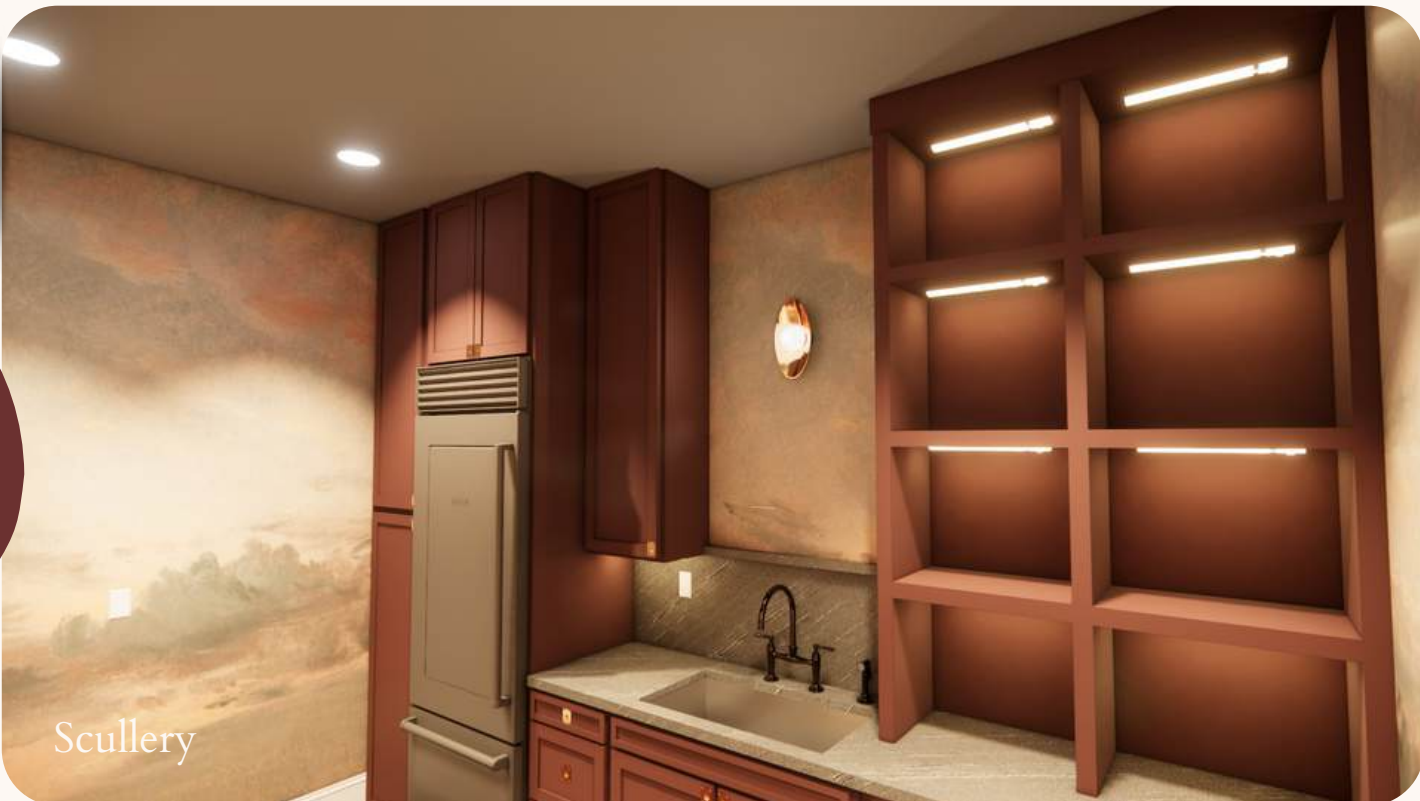

Scullery



Exterior



Sunroom



Master Bedroom




Nkba Project

Designed a Maximalist Inspired kitchen renovation following the NKBA guidelines

- AutoCAD 2024
- SketchUp 2025
- Enscape
- Drawing Set
- Finish Plan
- Specified Finishes
- Interior Elevations
- Selected FF&E




nkba project

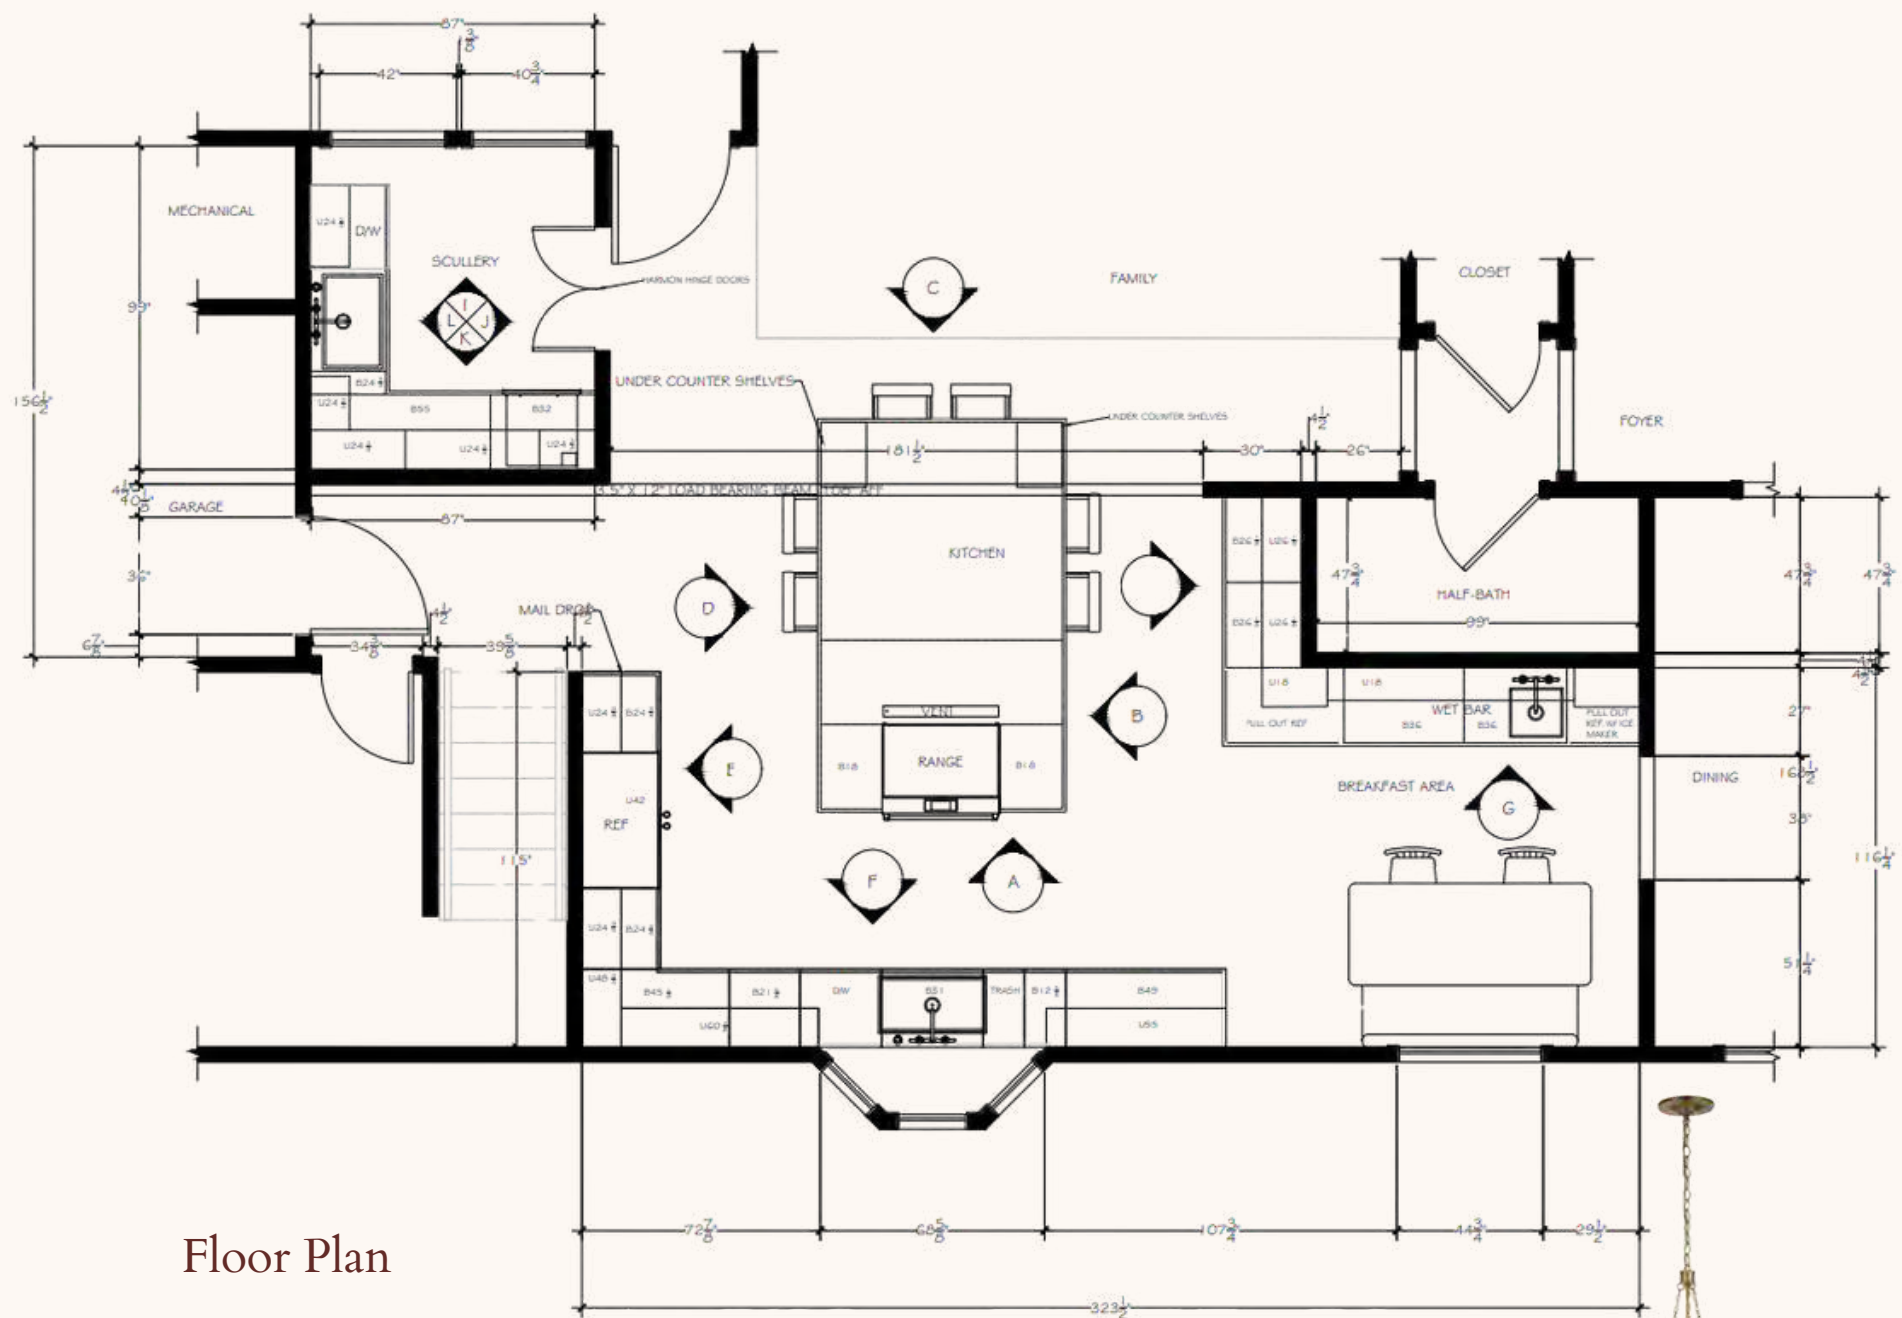


Floor Plan



nkba project

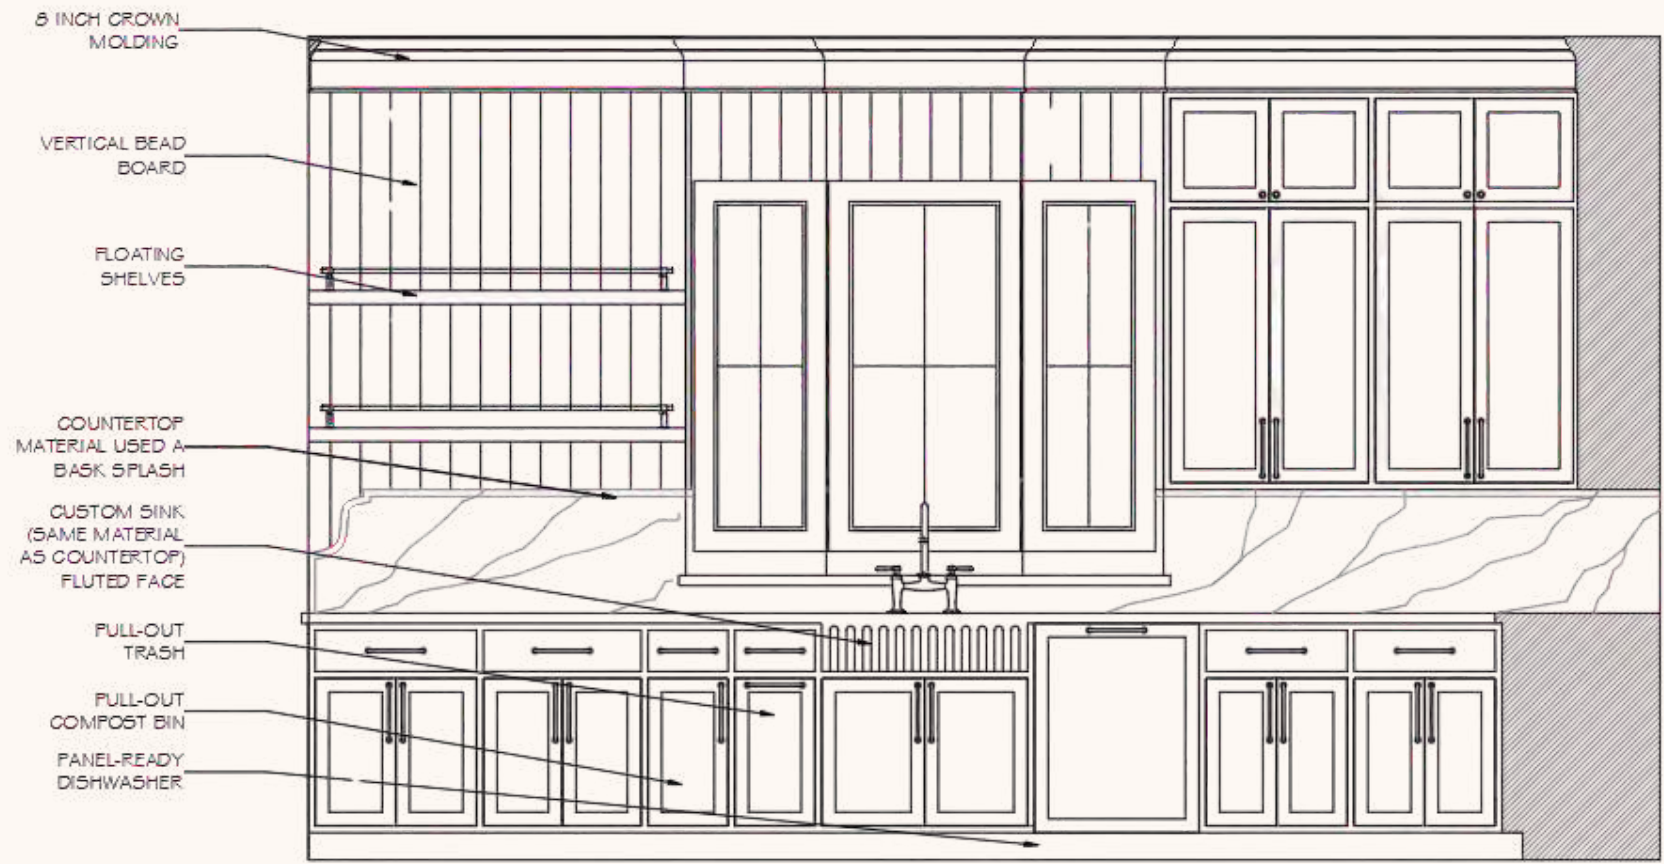


Sink Elevation

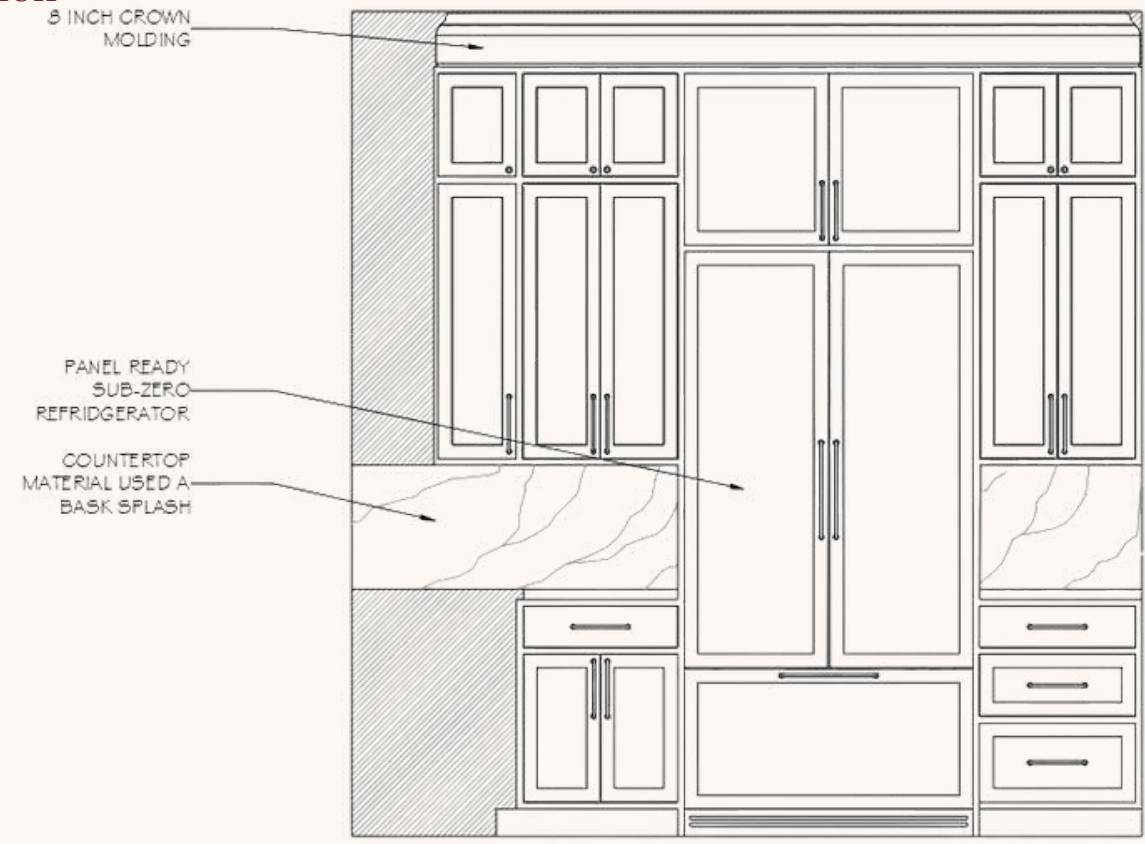


Fridge Elevation




nkba project

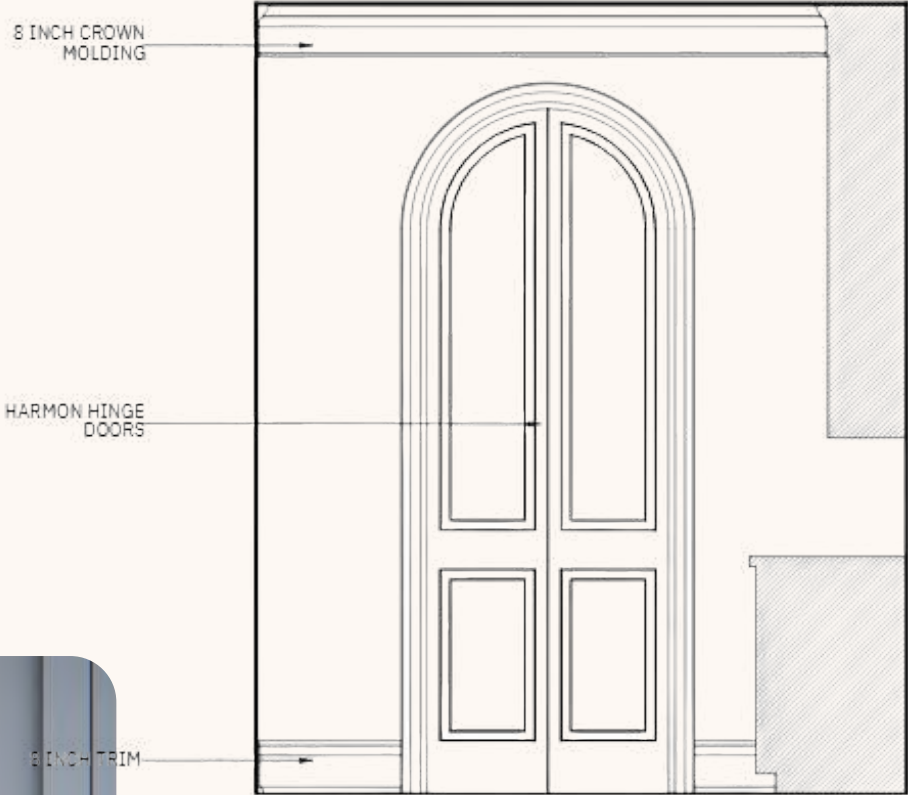


J. Sculler Door Elevation

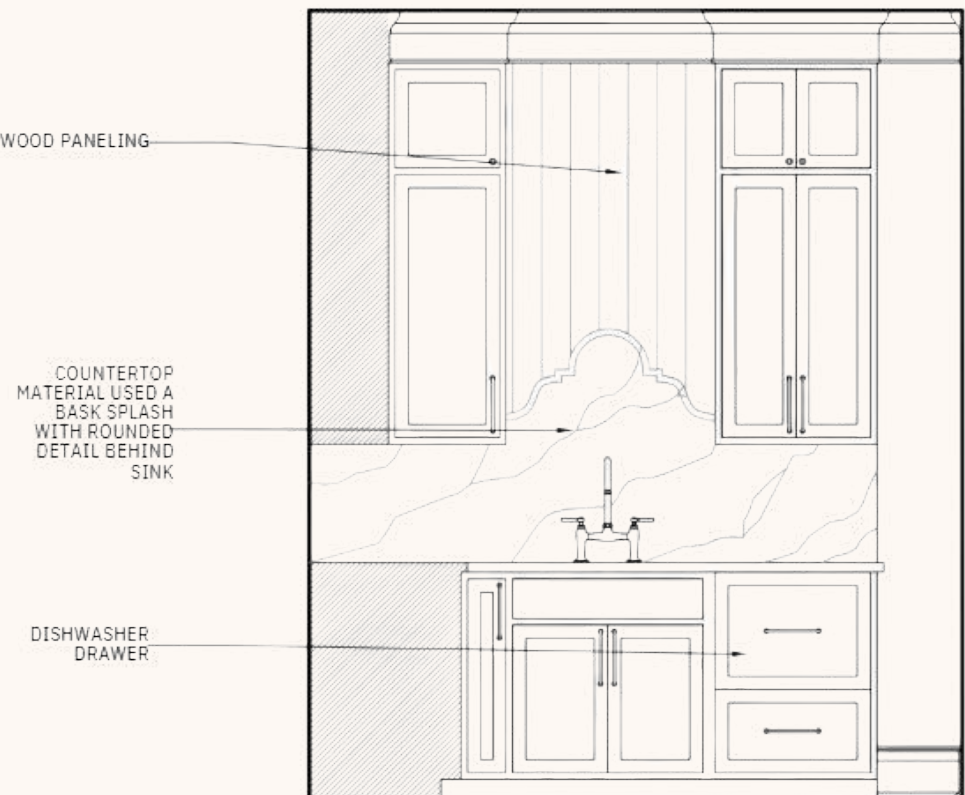

L. Scullery Sink Elevation

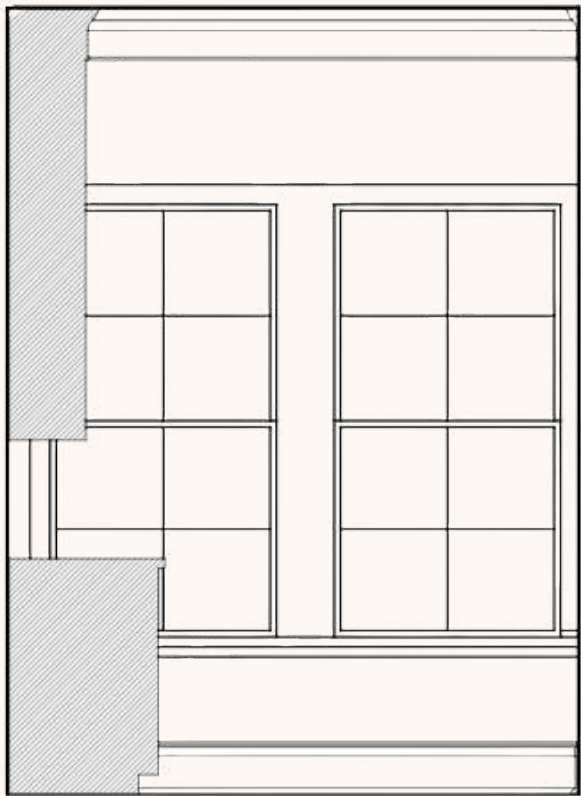

I.Scullery Window Elevation

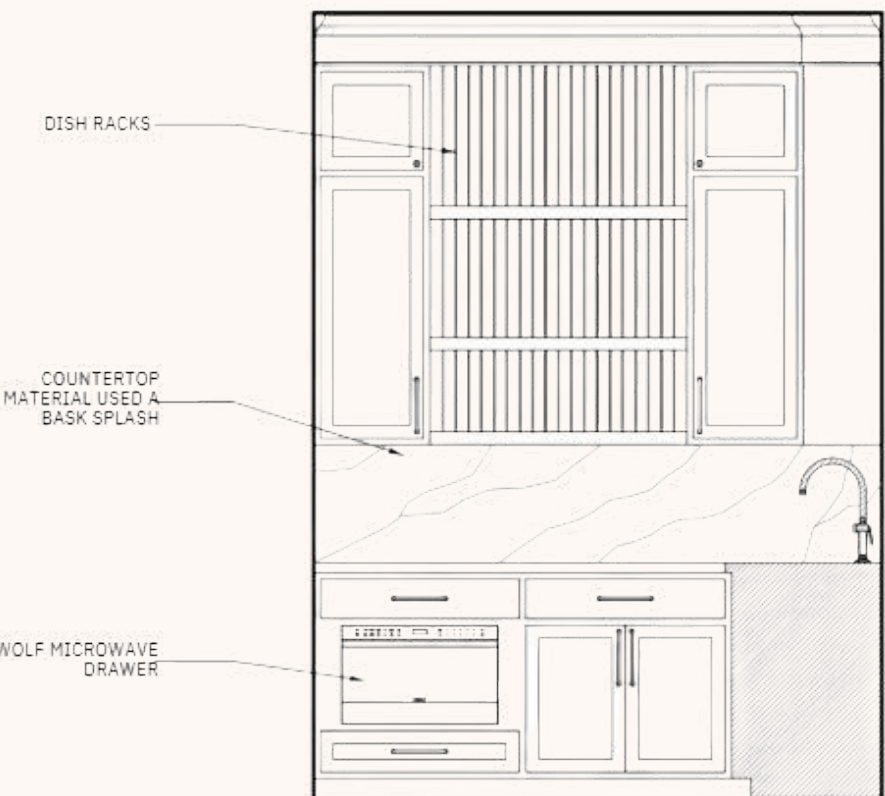

K. Scullery Microwave Elevation




Frammel Project

Designed a 5539-square-foot commercial space for an advertising firm in Dallas, TX

- AutoCAD 2024
- CD Set
- ADA accessibility
- Specified Finishes
- Finish Plan
- Details
- Interior and Exterior Elevations
- Furniture Plan
- Selected FF&E
- Lighting and Electrical Plans with Legends



Frammel Project

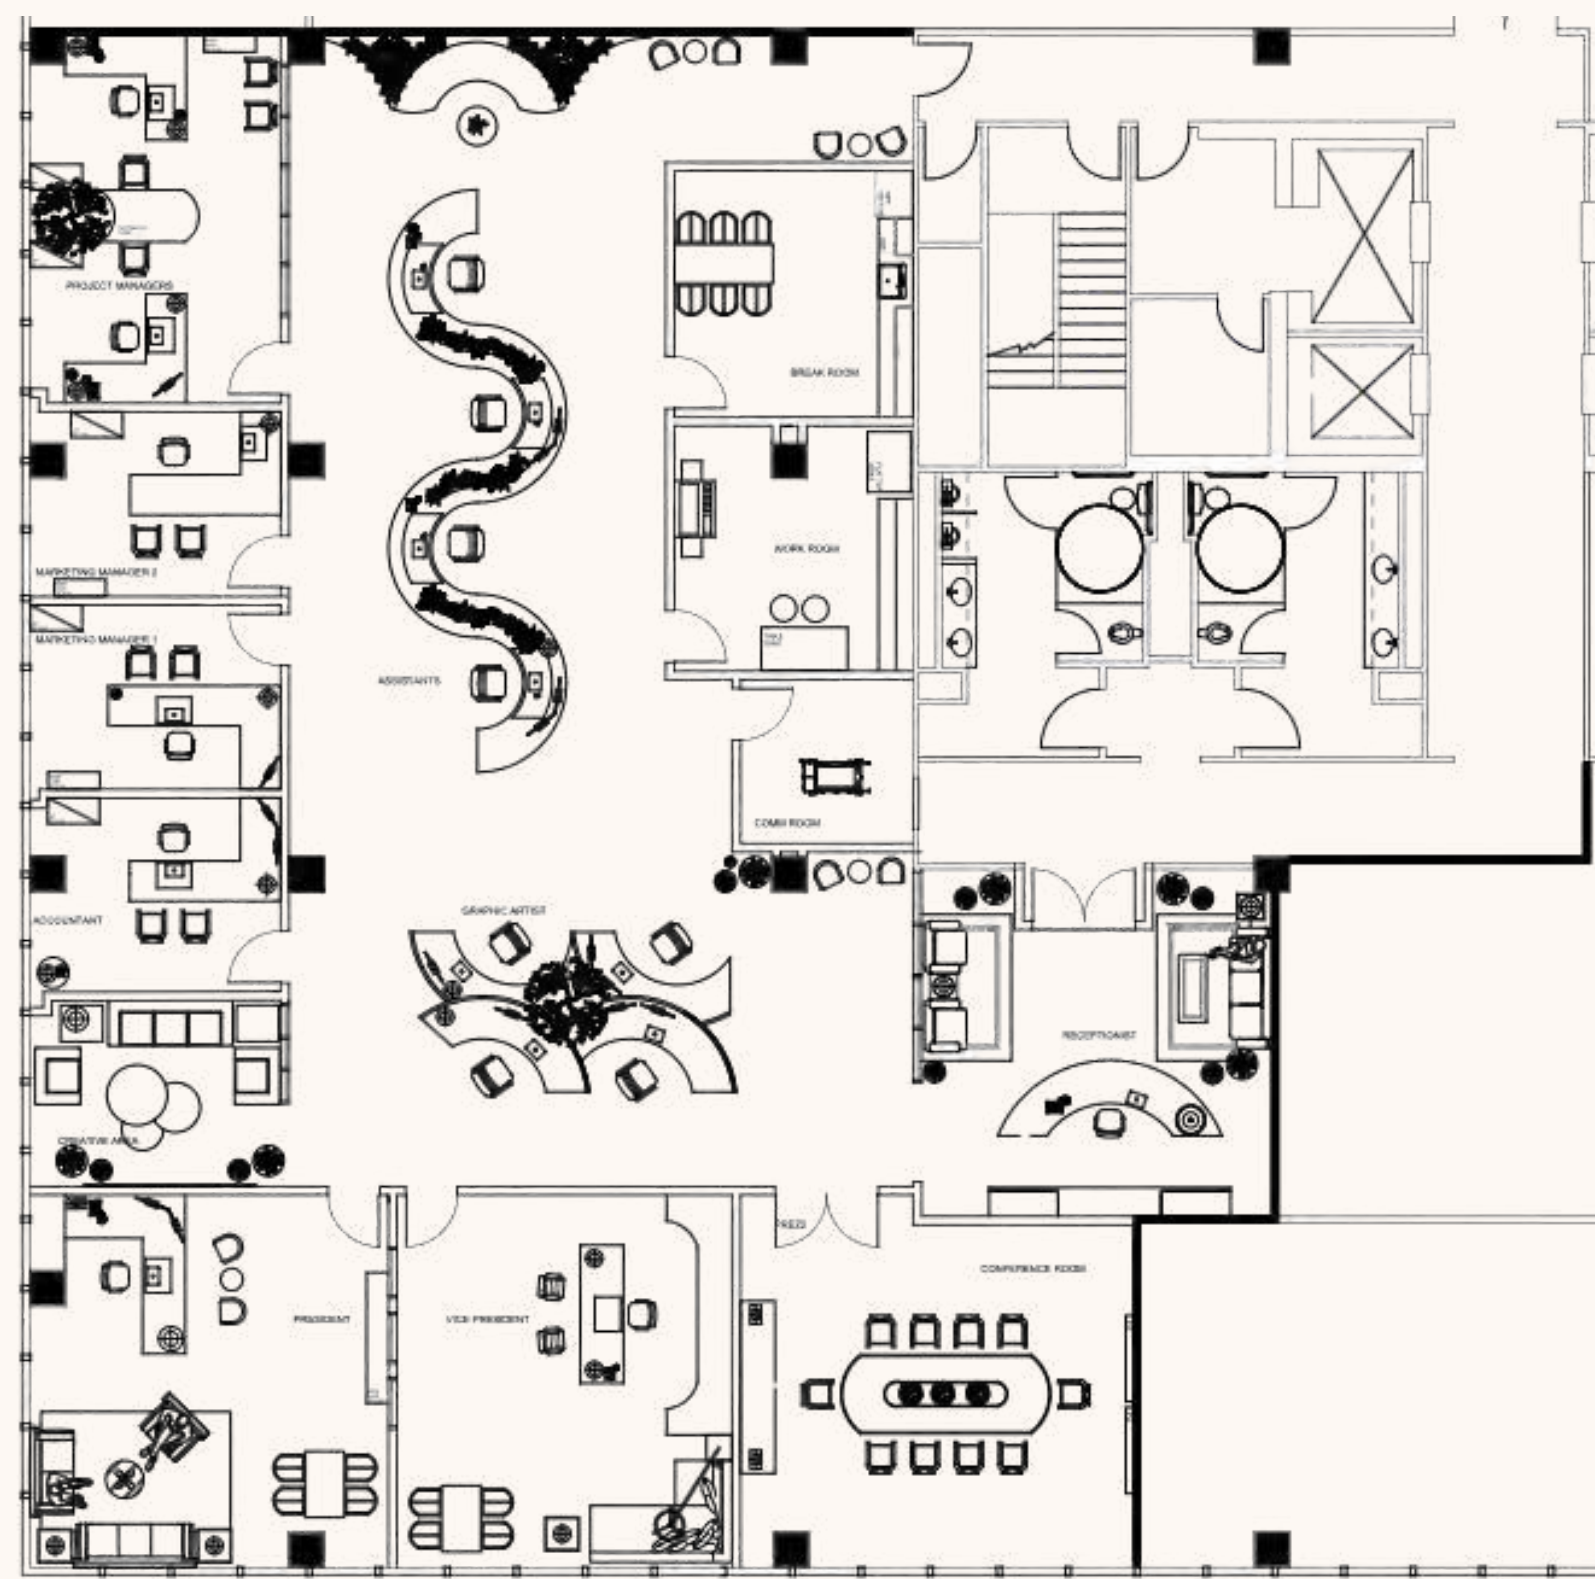


Furniture Plan




Reception Desk Elevation




Frammel Project

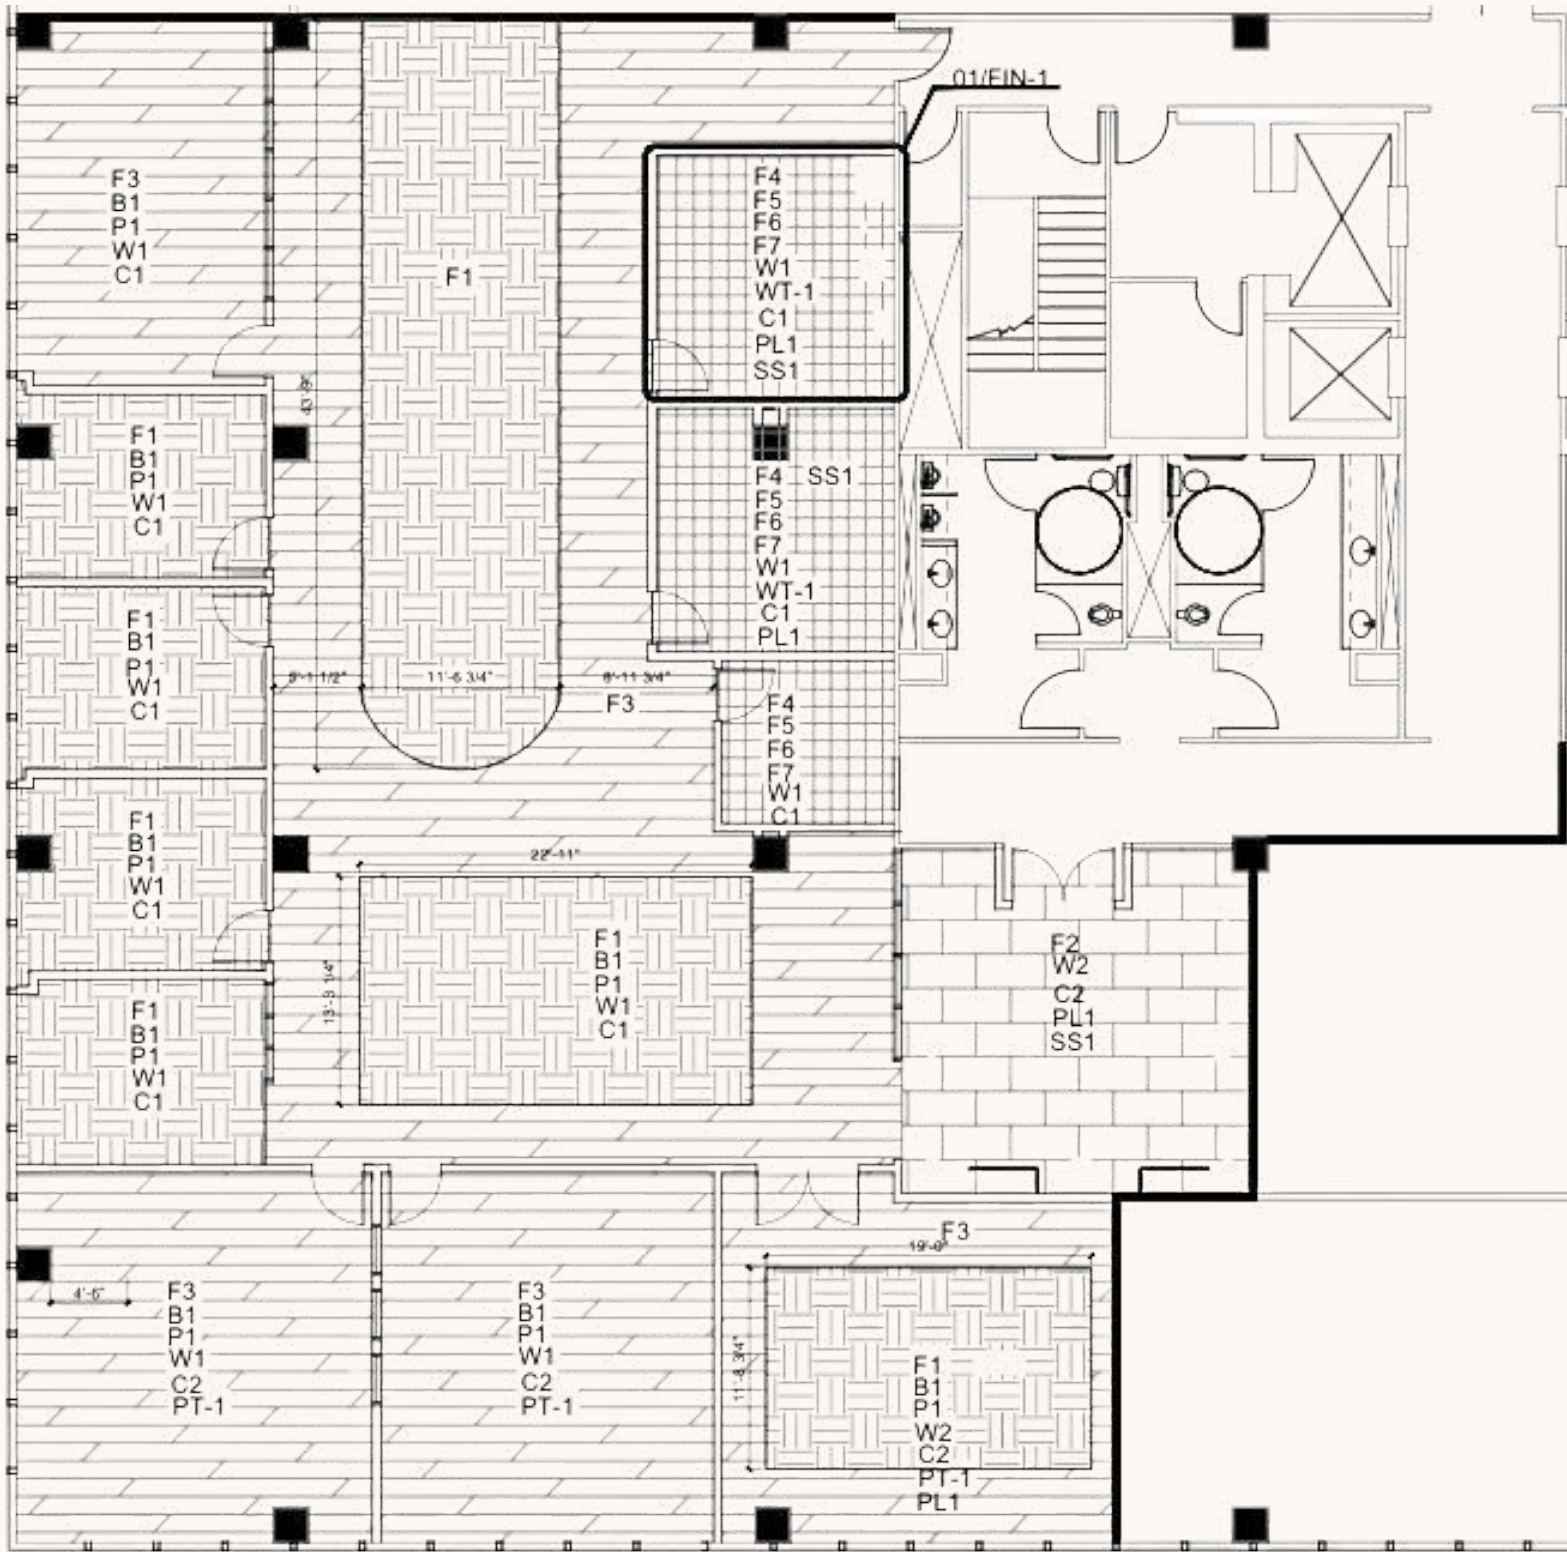

Reception Desk Elevation

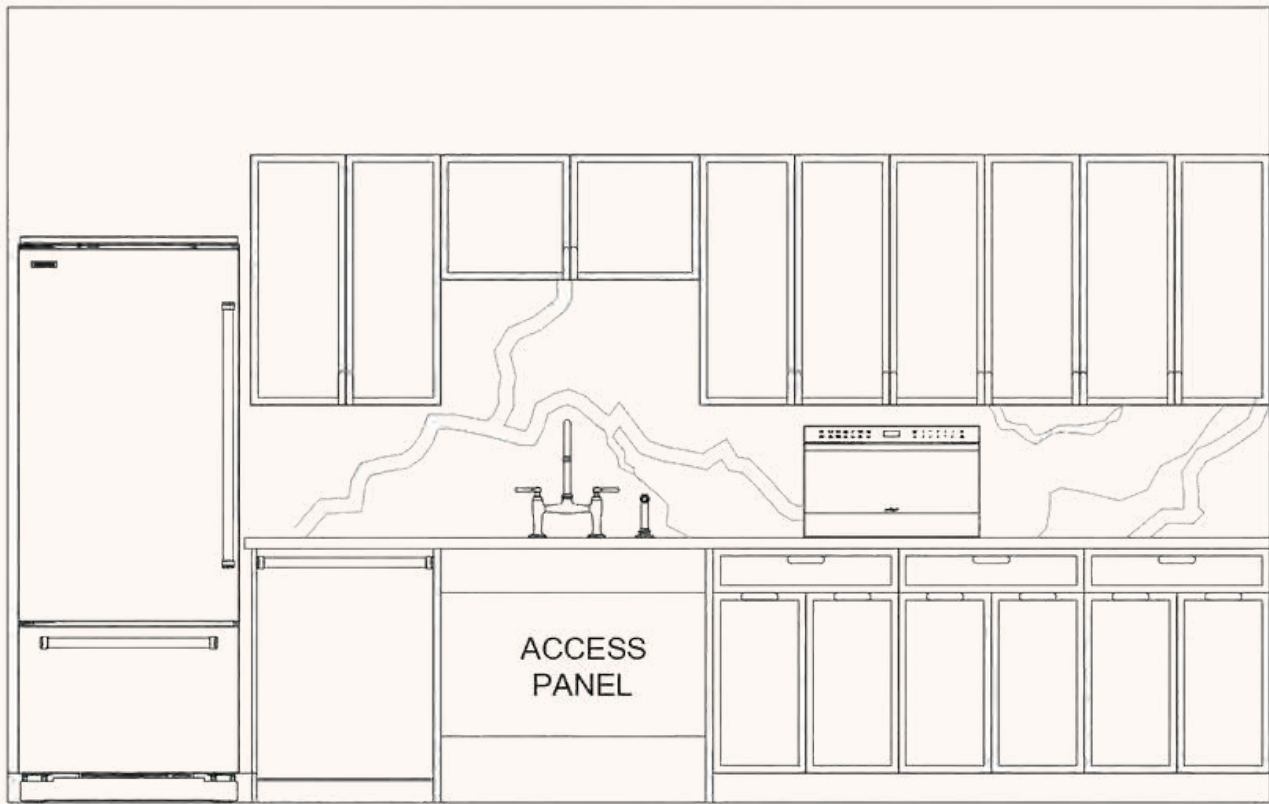


Break Room Elevation

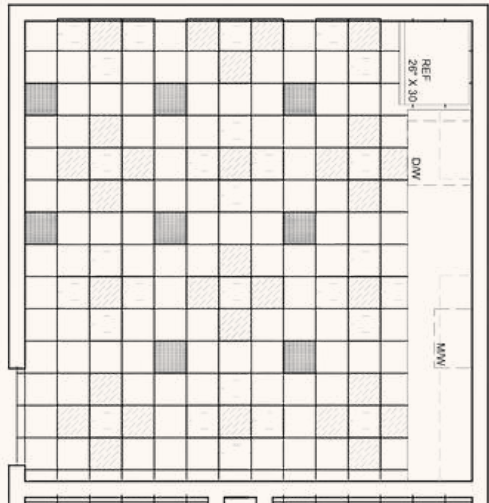


Break Room Floor Pattern




F3

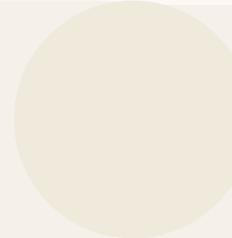

P1

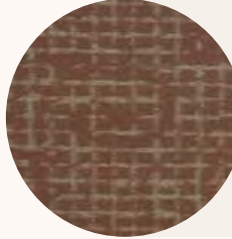


F1

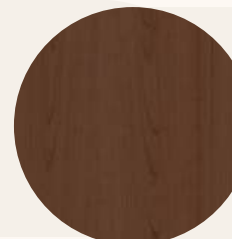

PL1




F2

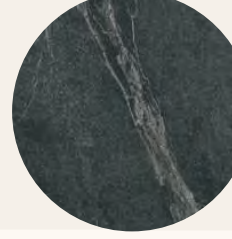


SS1




Frammel Project

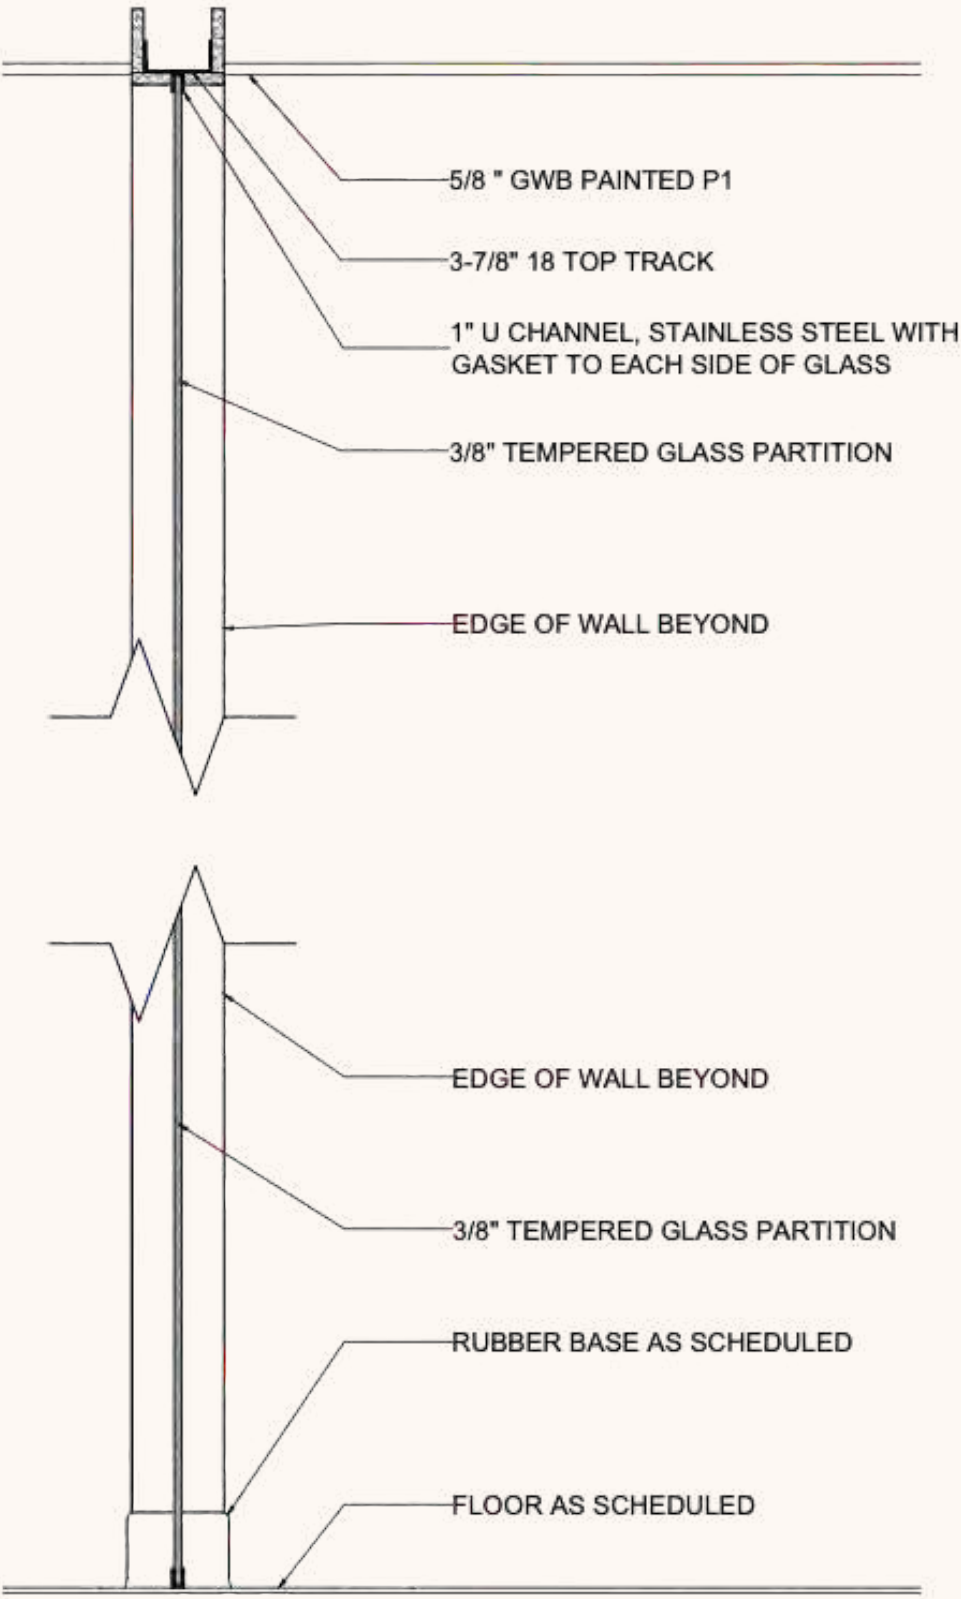

03 GLASS PARTITION SECTION
SCALE: 1-1/2" = 1'-0"

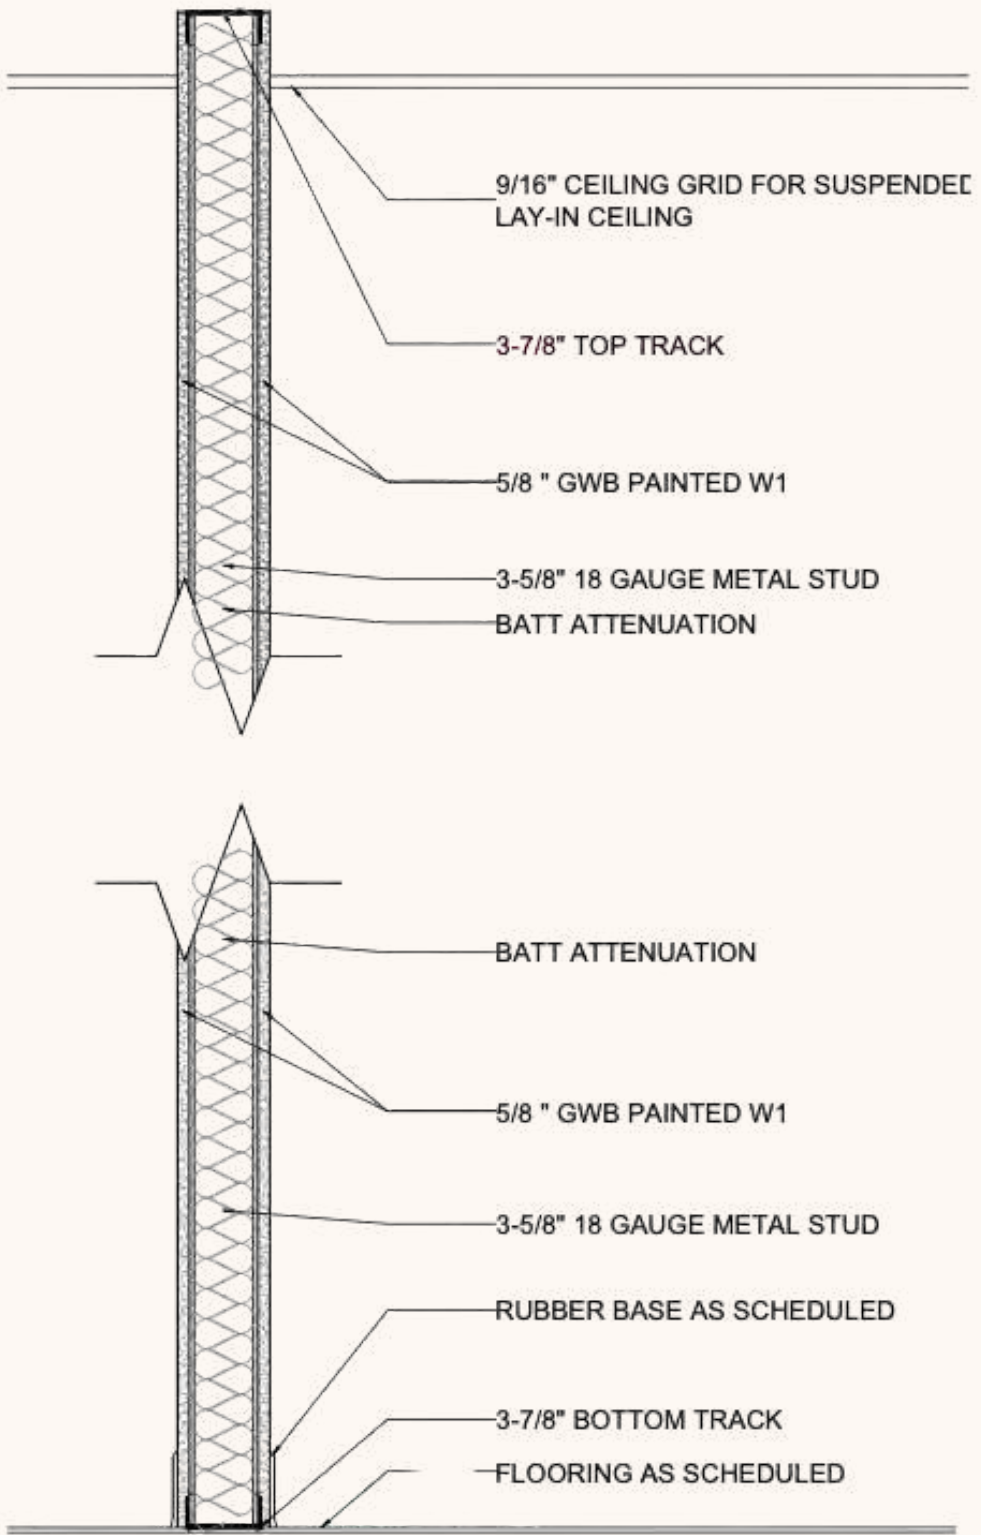

01 TYP. WALL SECTION
SCALE: 1-1/2" = 1'-0"

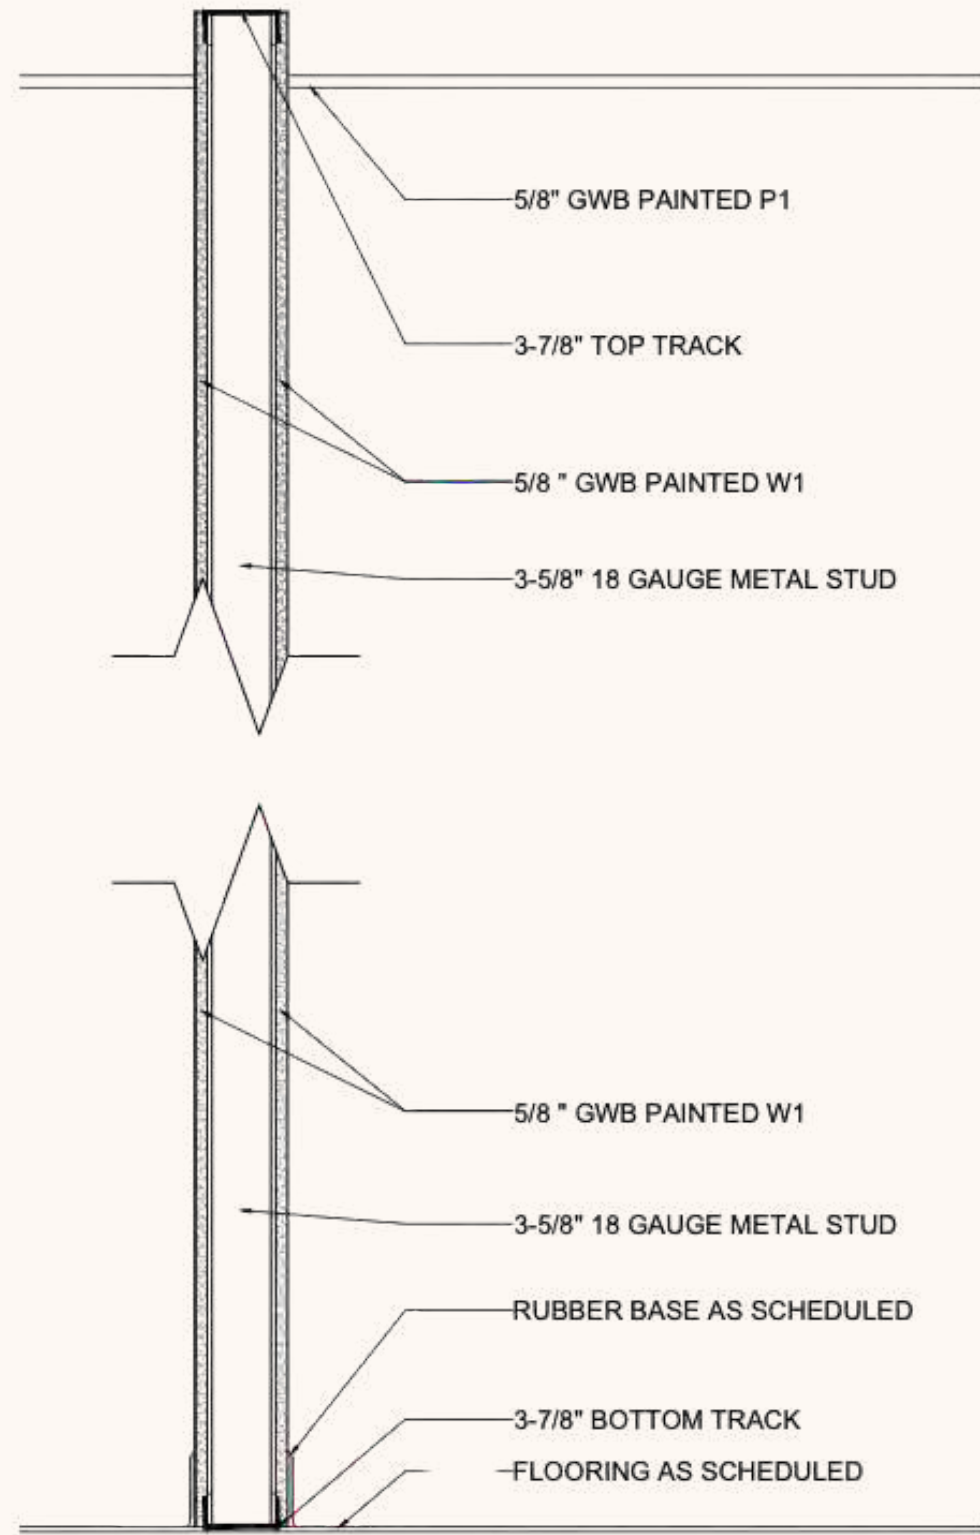

01 TYP. WALL SECTION
SCALE: 1-1/2" = 1'-0"



Jones Residence

The Jones Residence is a 1,800-square-foot single family residence features 2 bedrooms and 1 bathroom,

- AutoCAD 2024
- CD Set
- Roof Plan
- Finish Plan
- Specified Finishes
- Details
- Interior and Exterior Elevations
- Furniture Plan
- Selected FF&E
- Lighting and Electrical Plans with Legends



Jones Residence



Front Elevation



Right Elevation



Rear Elevation




Left Elevation



Jones Residence




Floorplan

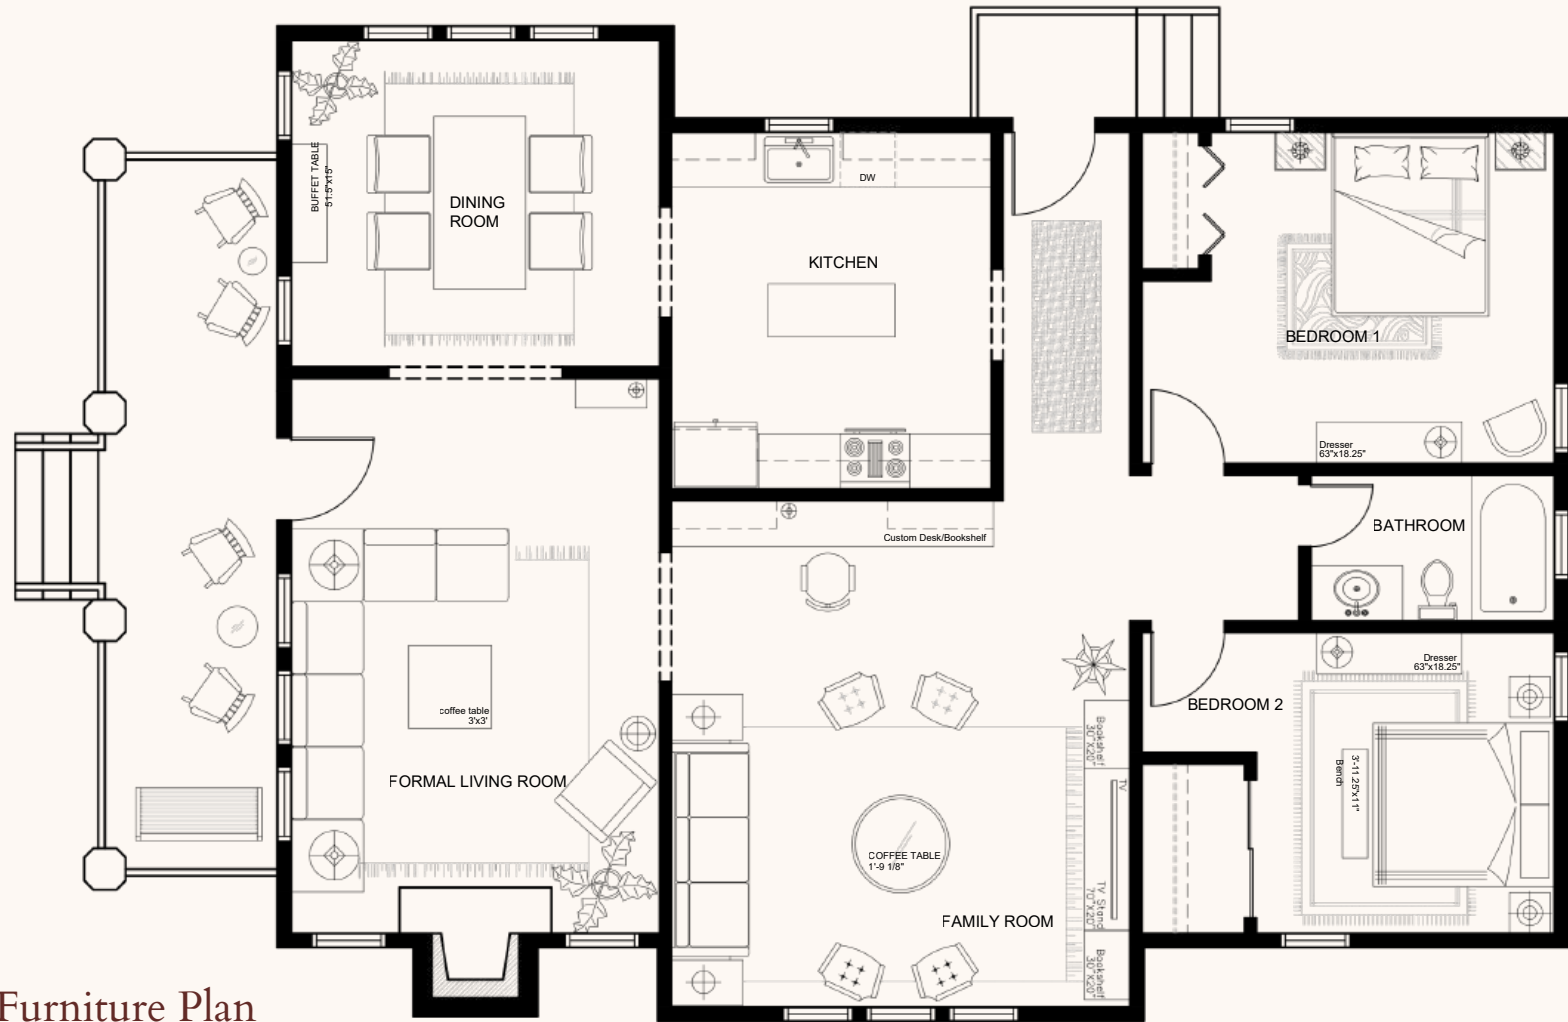

Furniture Plan




Jones Residence

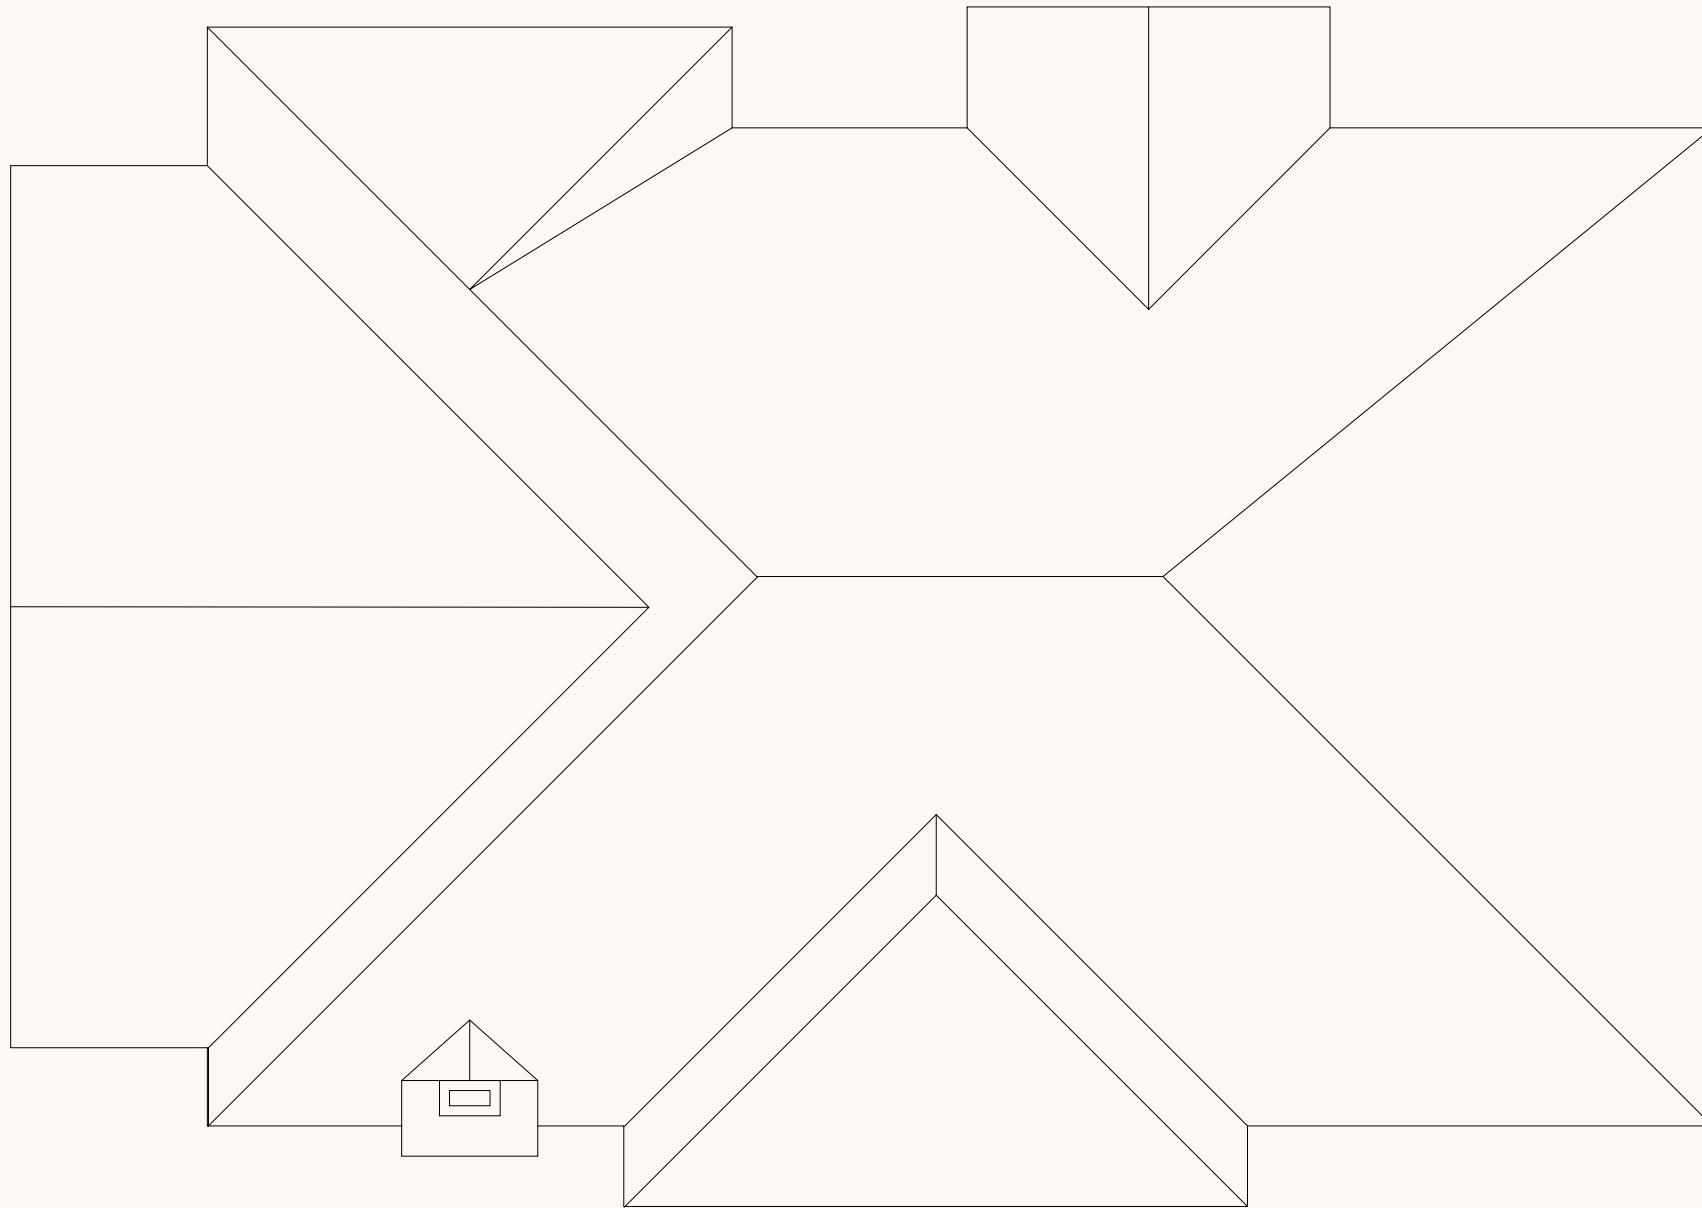


Roof Plan


Wall Section

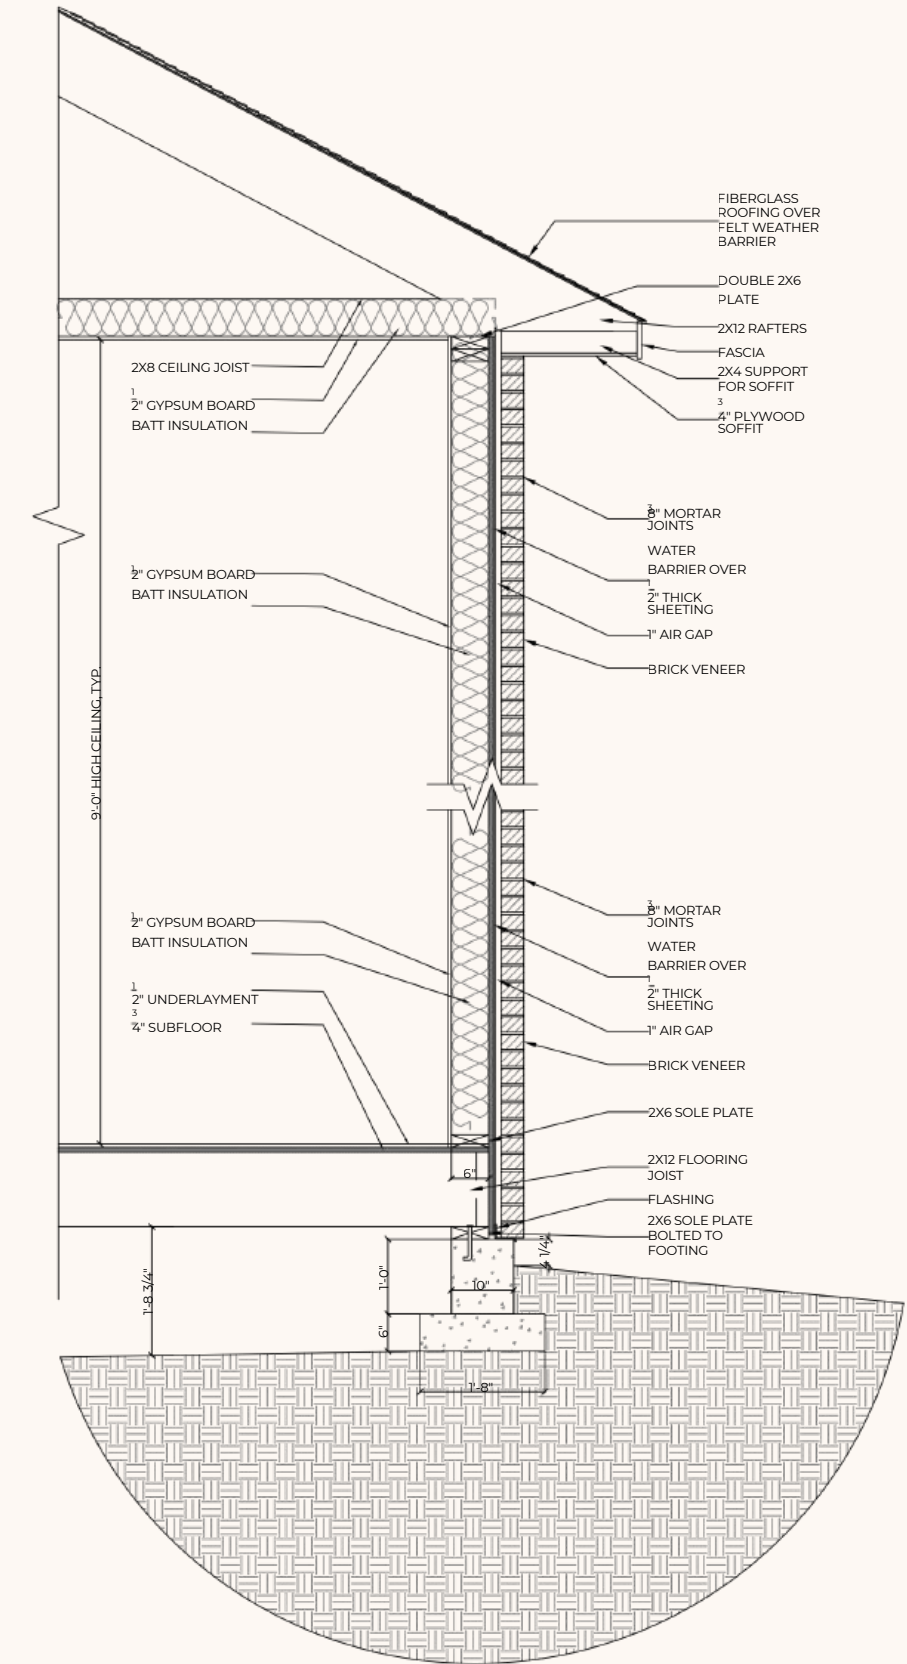


Jones Residence

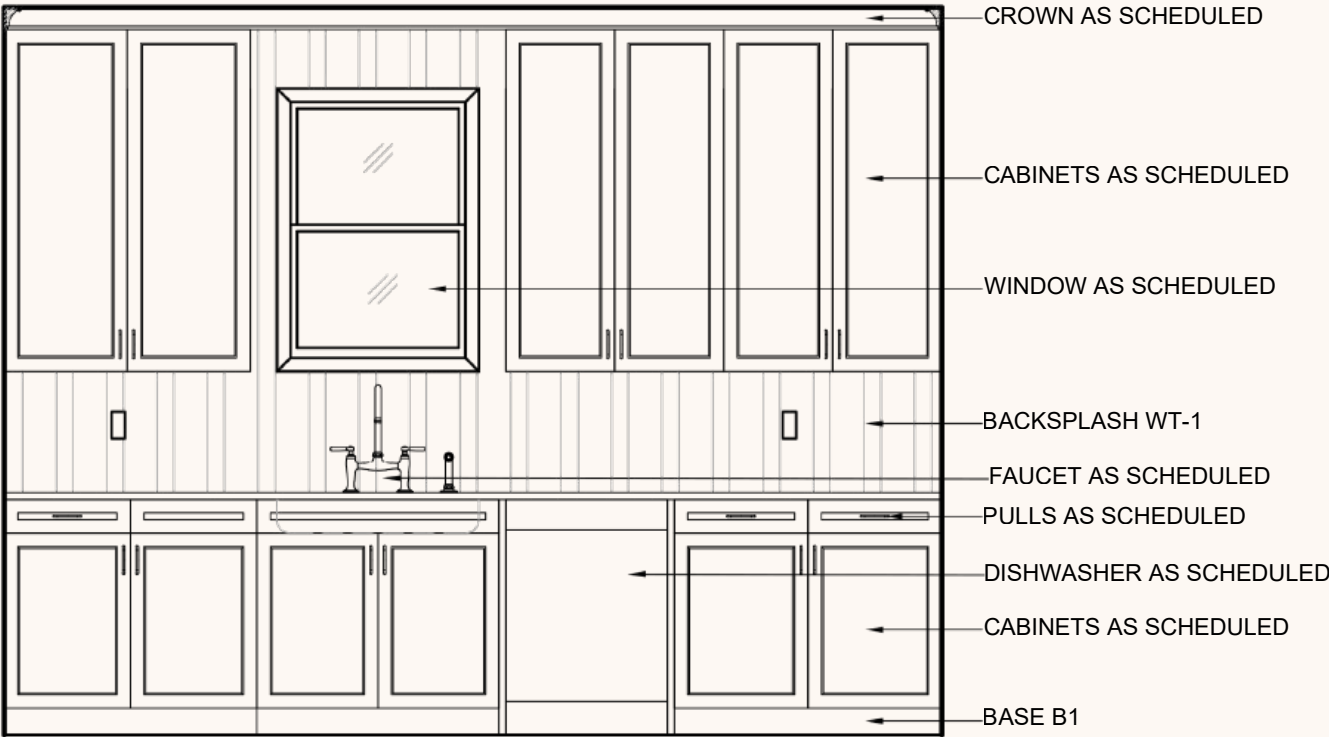

Kitchen Sink Elevation

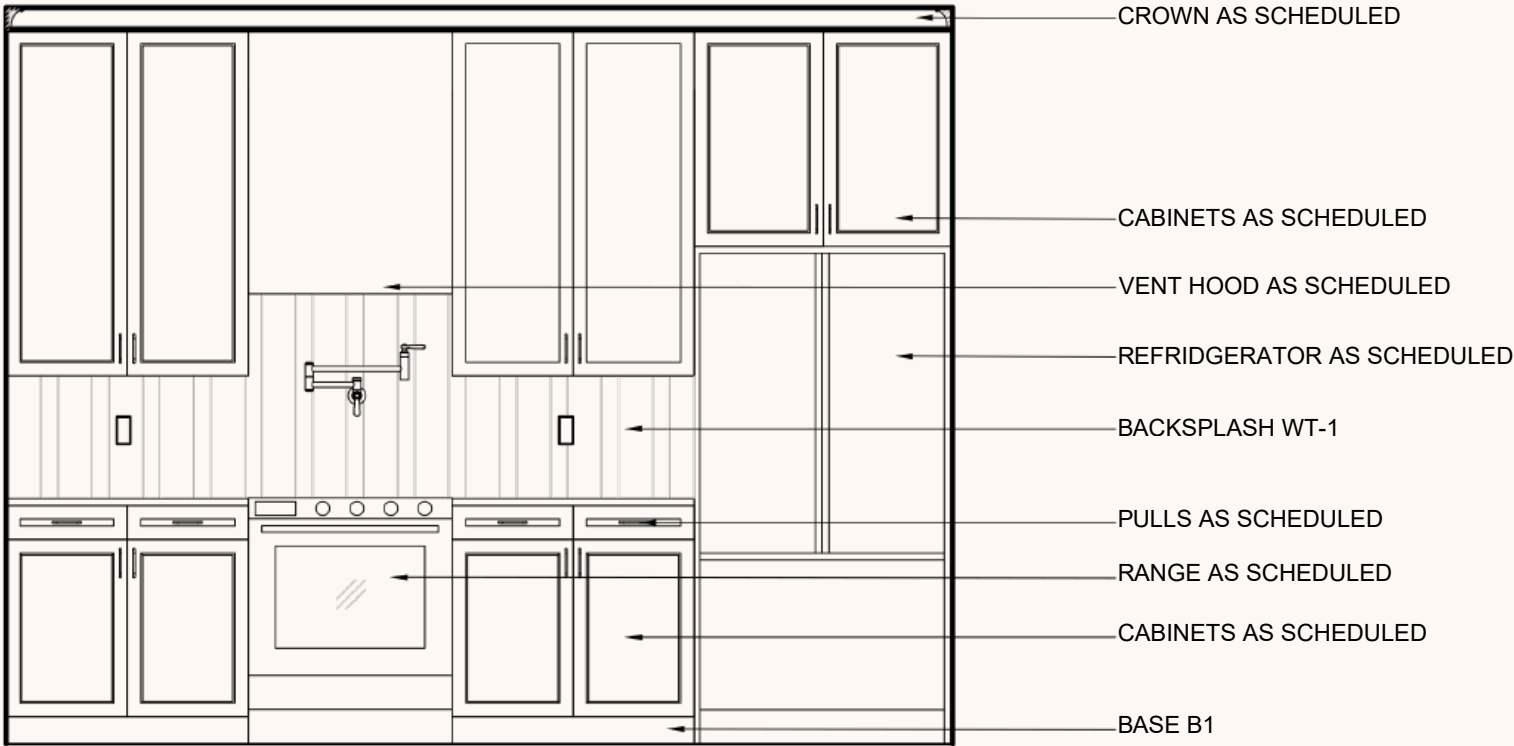

Kitchen Range Elevation

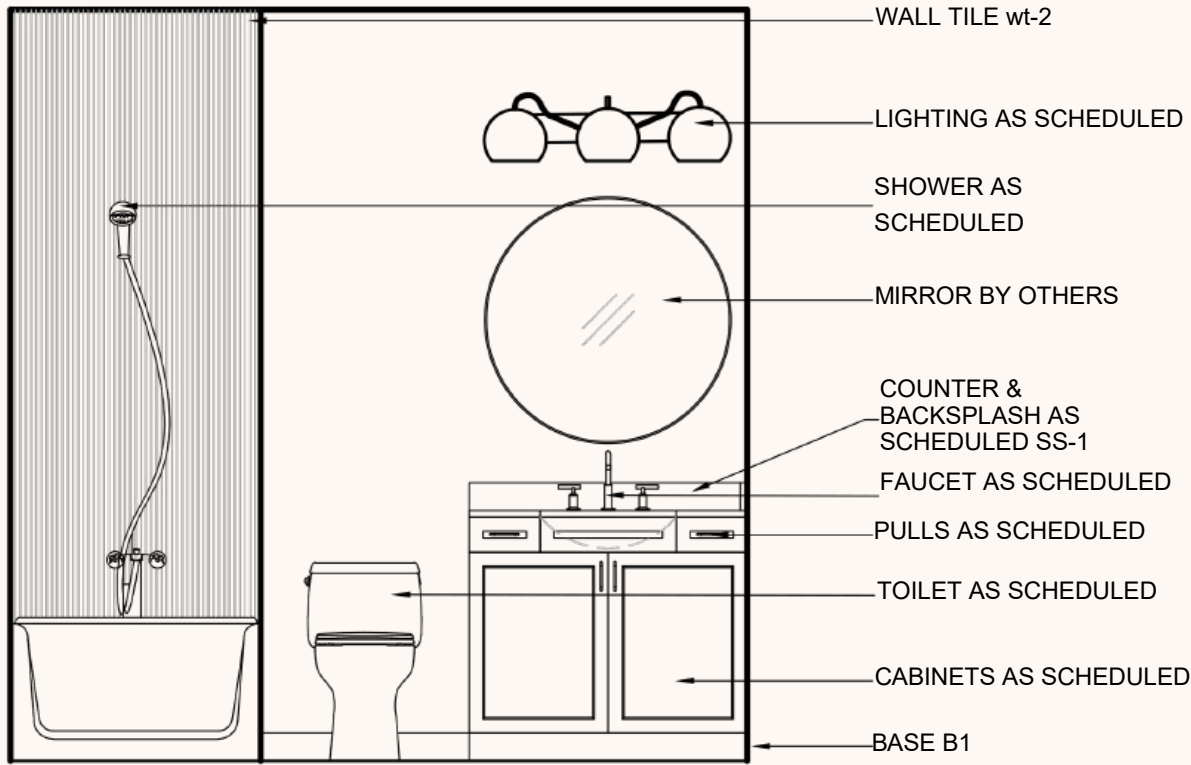

Bathroom Elevation




Fireplace Elevation



Train Car Renovation

Converted a single train car into a 1,180 sq ft living space with two bedrooms, two bathrooms, and built-in storage


- AutoCAD 2024
- Revit 2024
- Enscape
- Details
- Elevation
- Furniture Plan
- Selected FF&E
- Lighting and Electrical Plans with legends
- Renderings

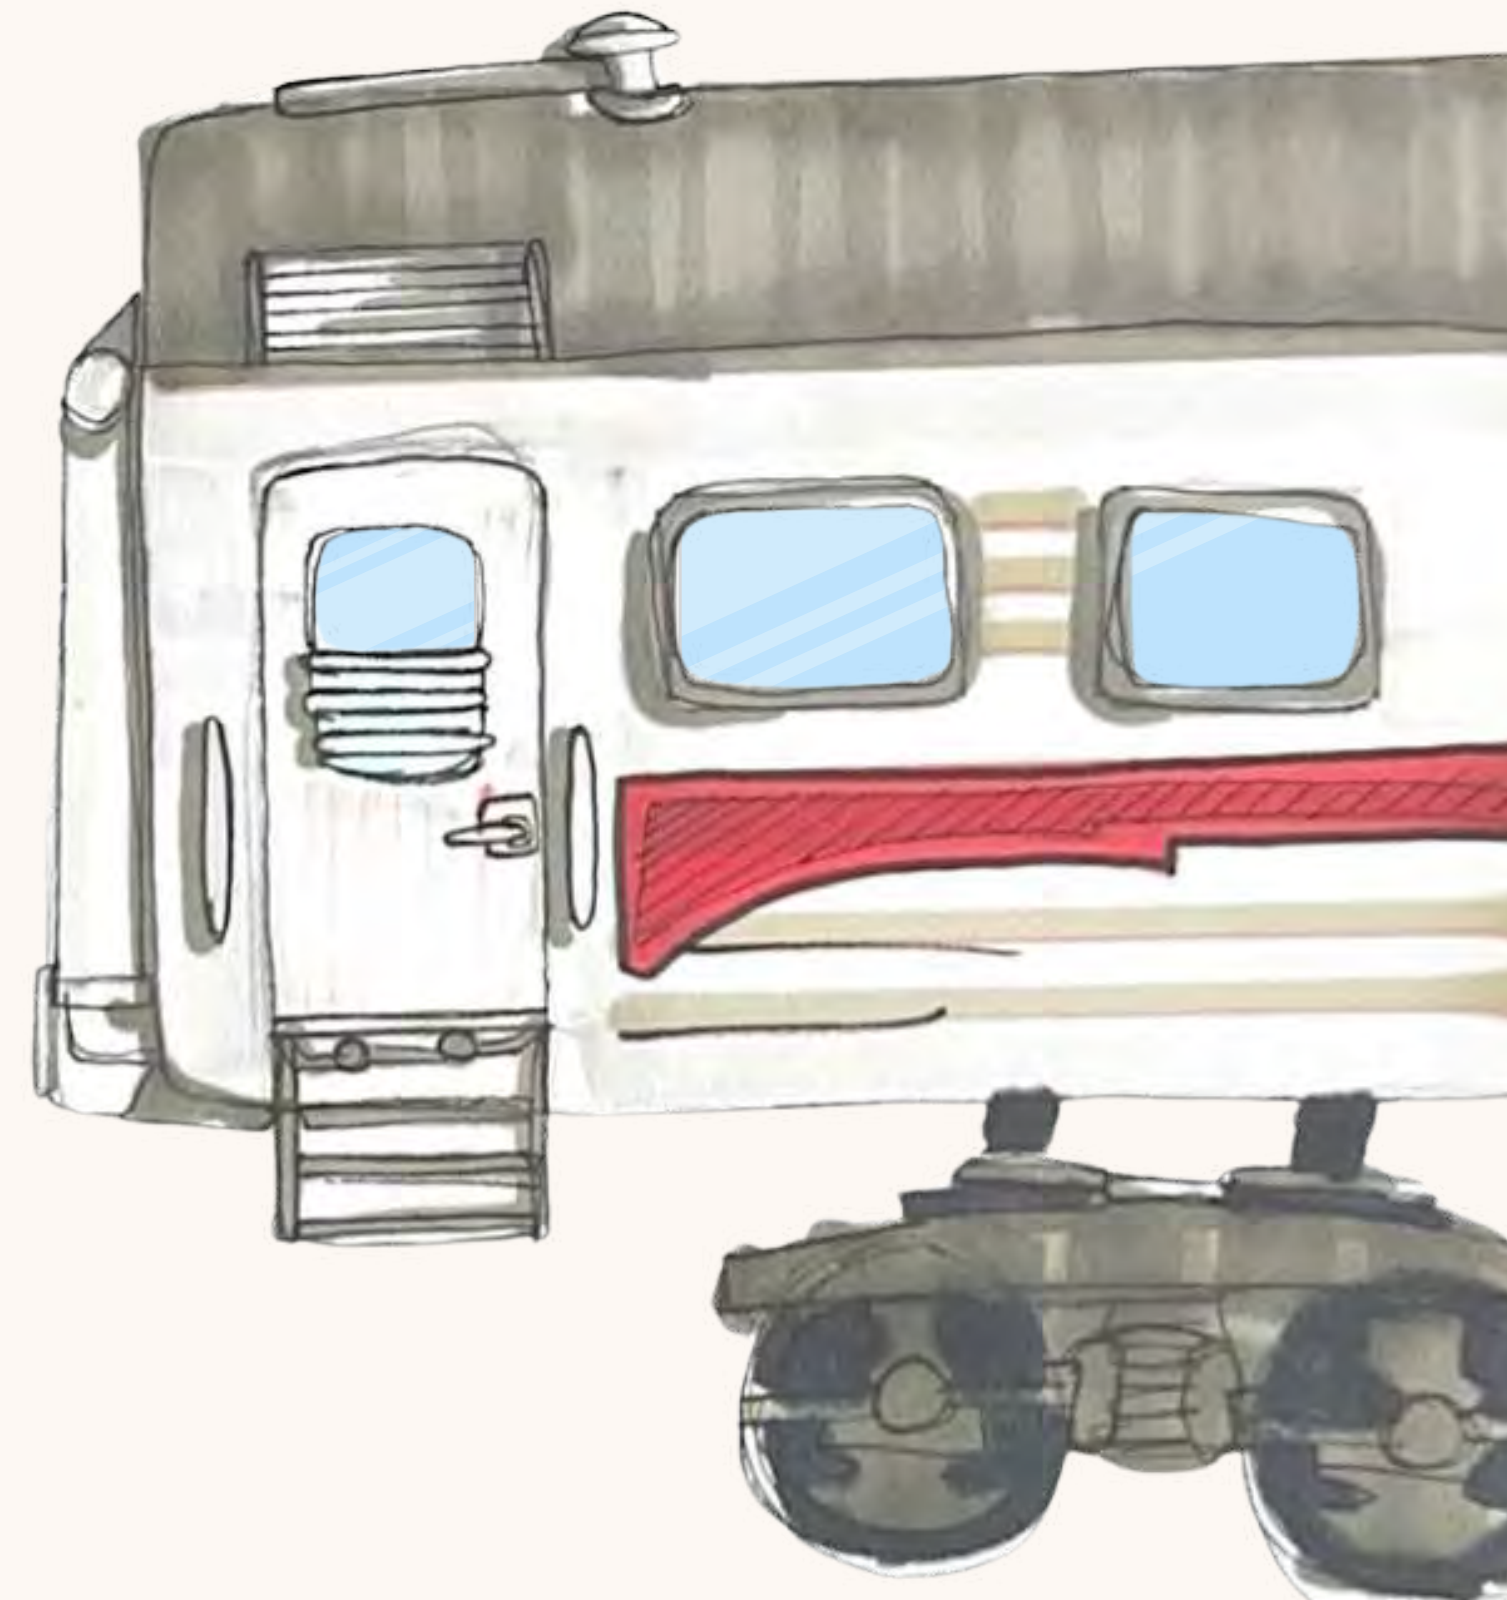


Train Car Renovation



01/DT-1

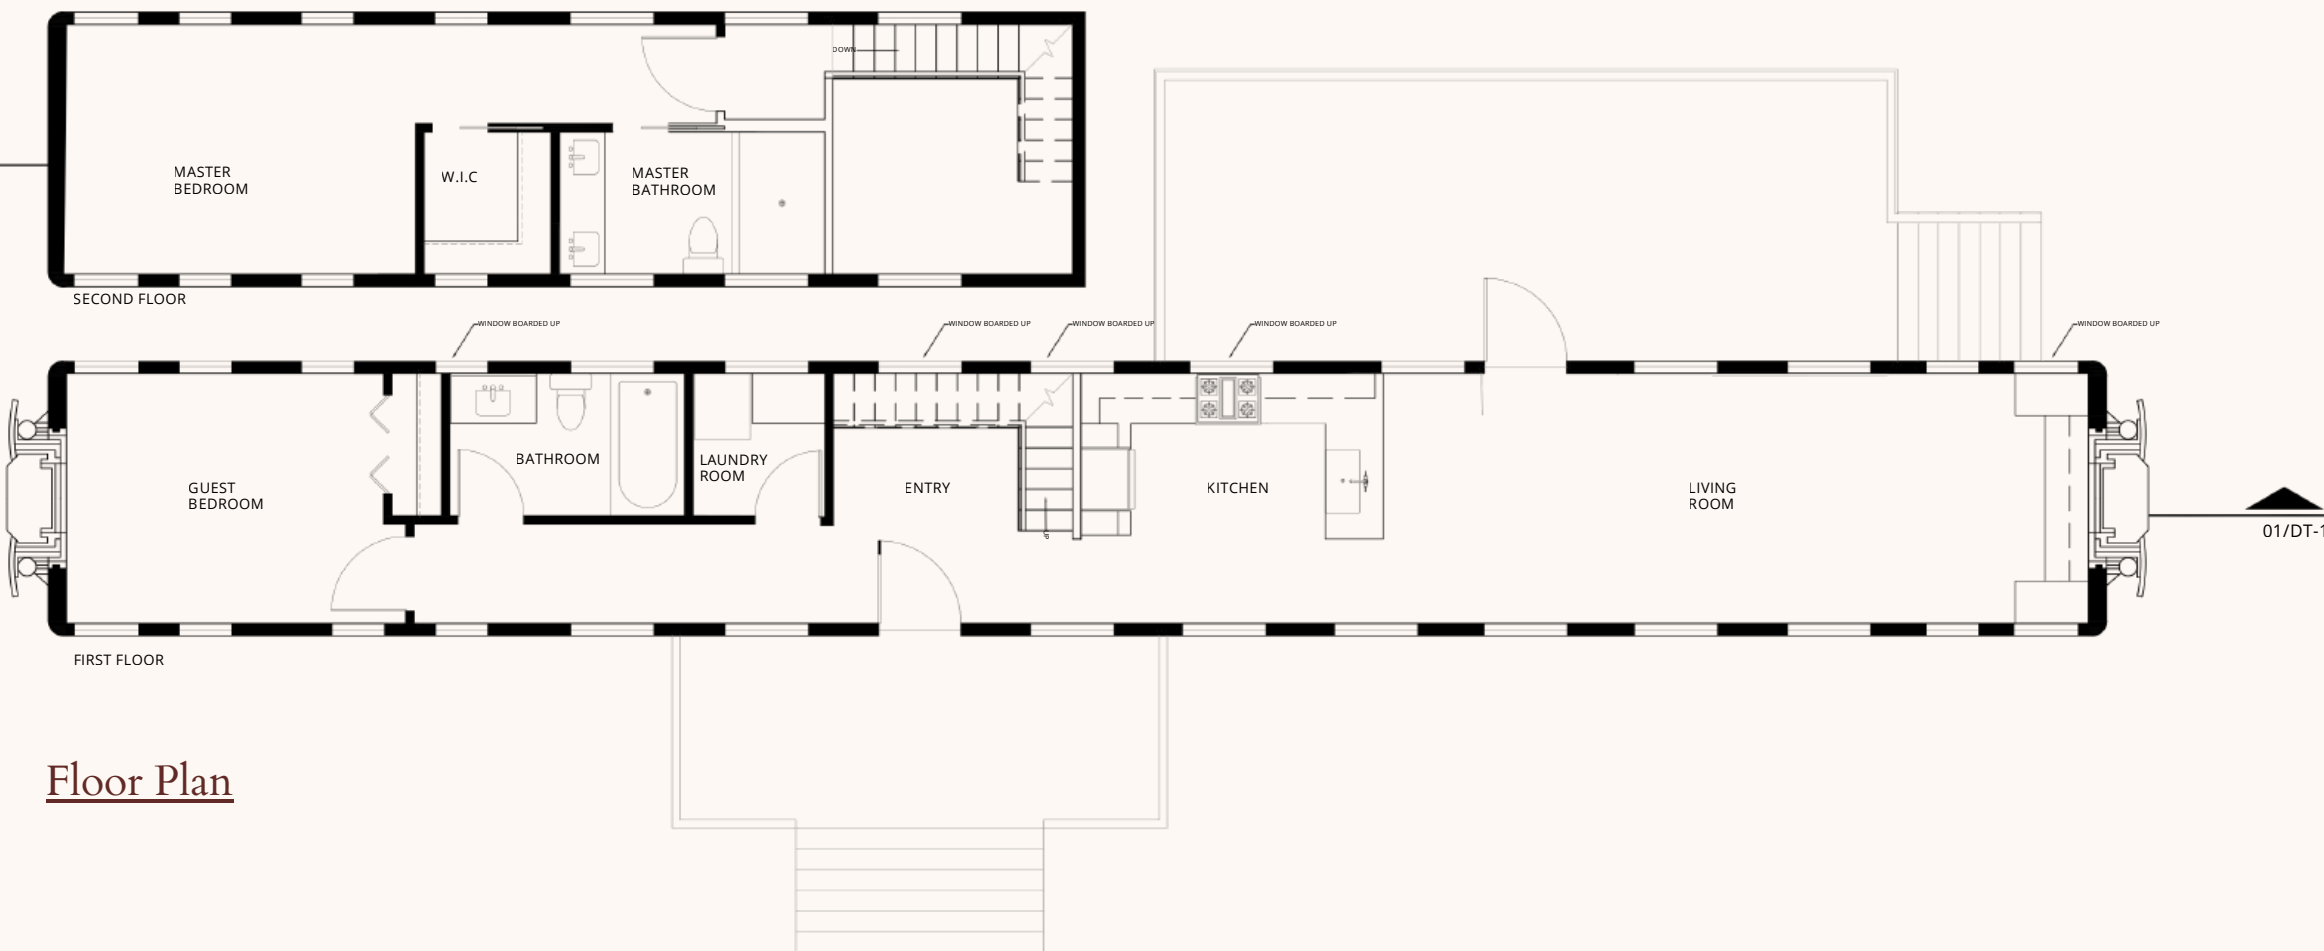


Floor Plan

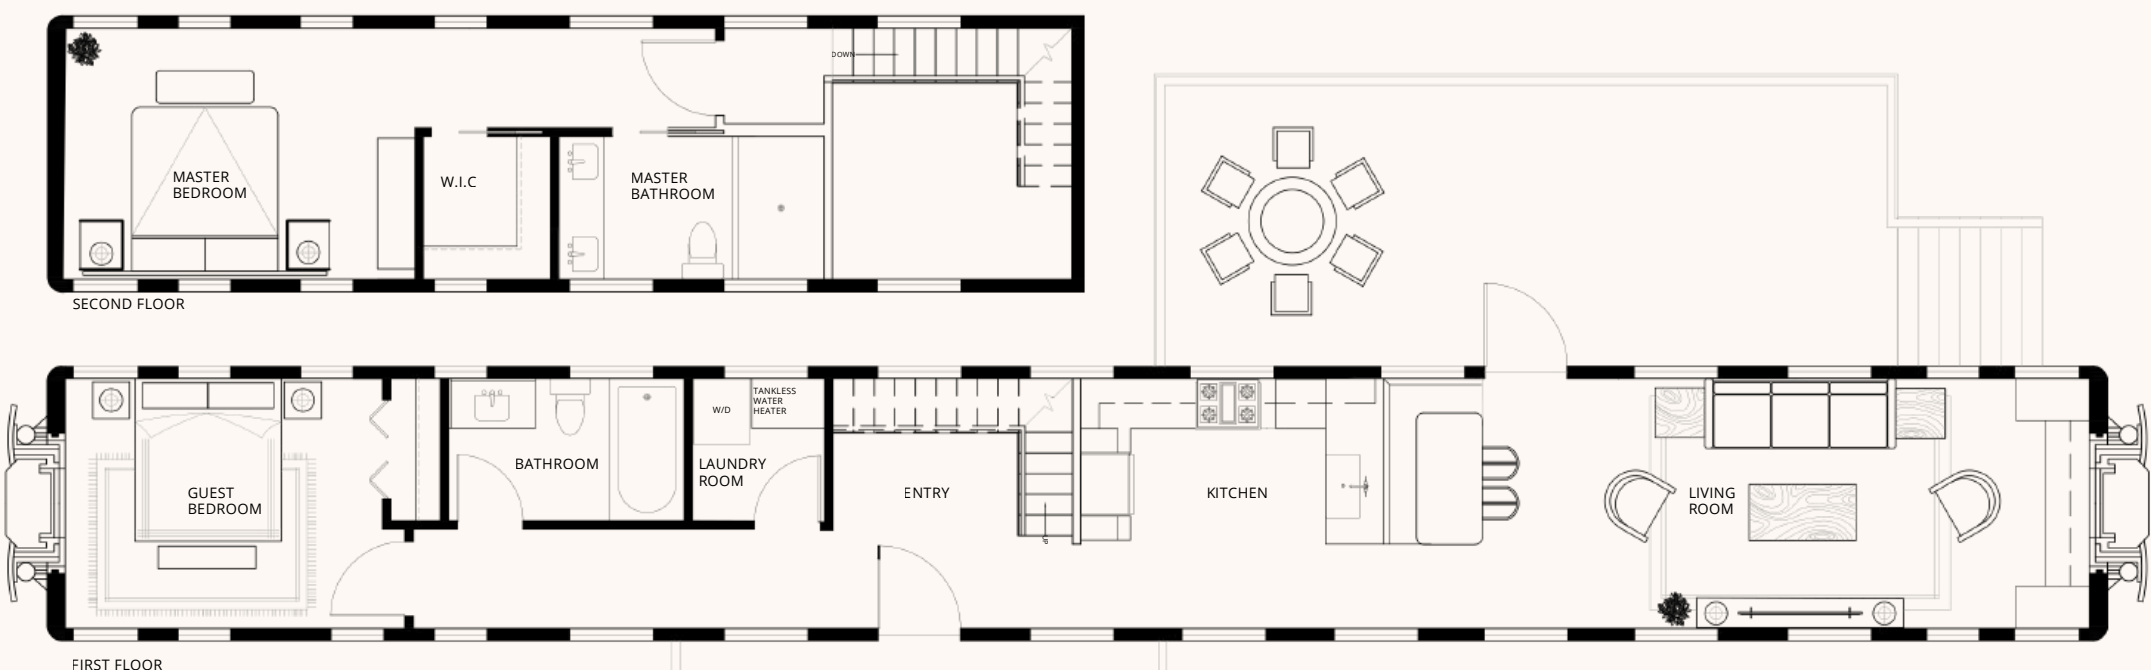


Furniture Plan



Train Car Renovation

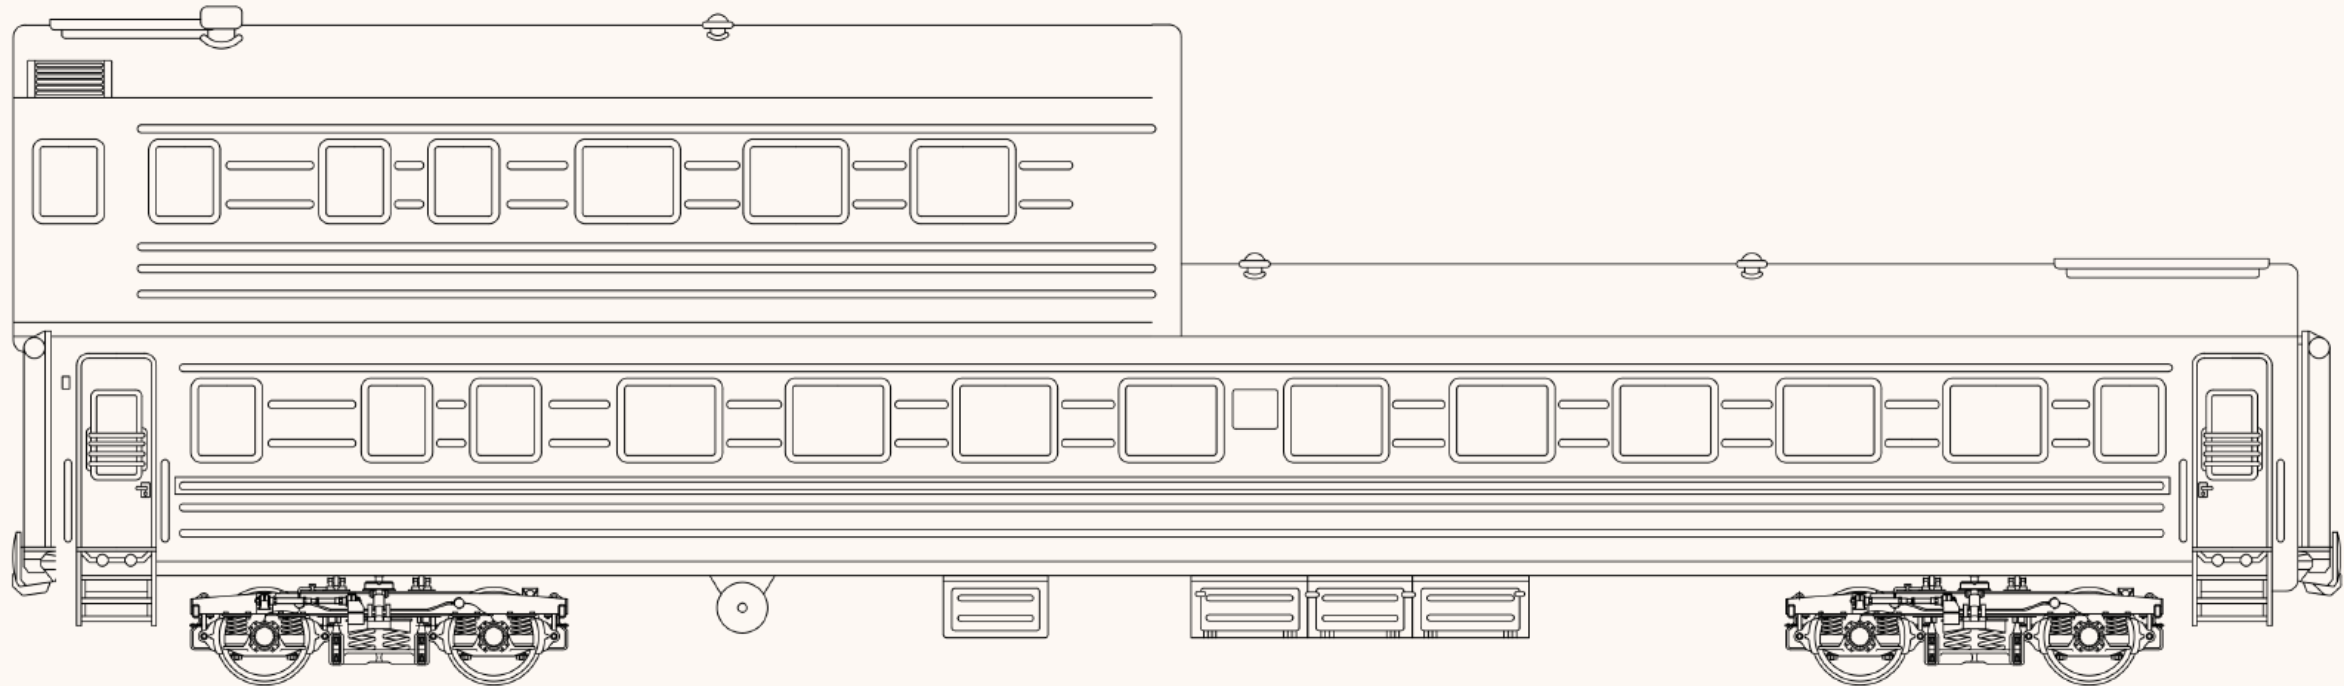

Exterior Elevation

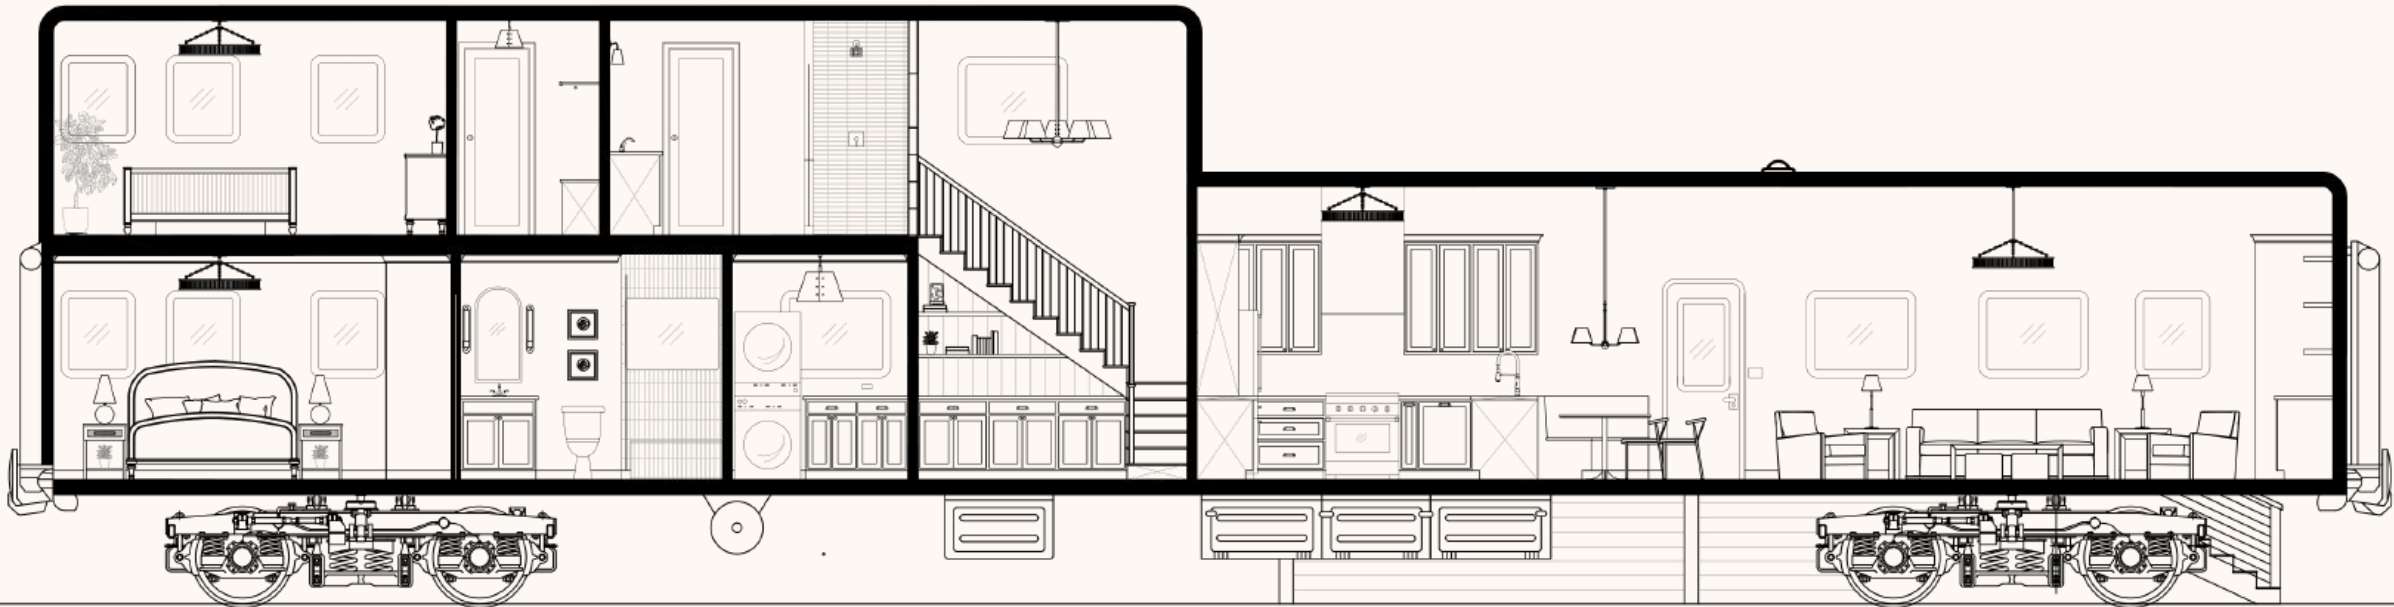

Interior Section



floors



tile




walls



Train Car Renovation



Kitchen

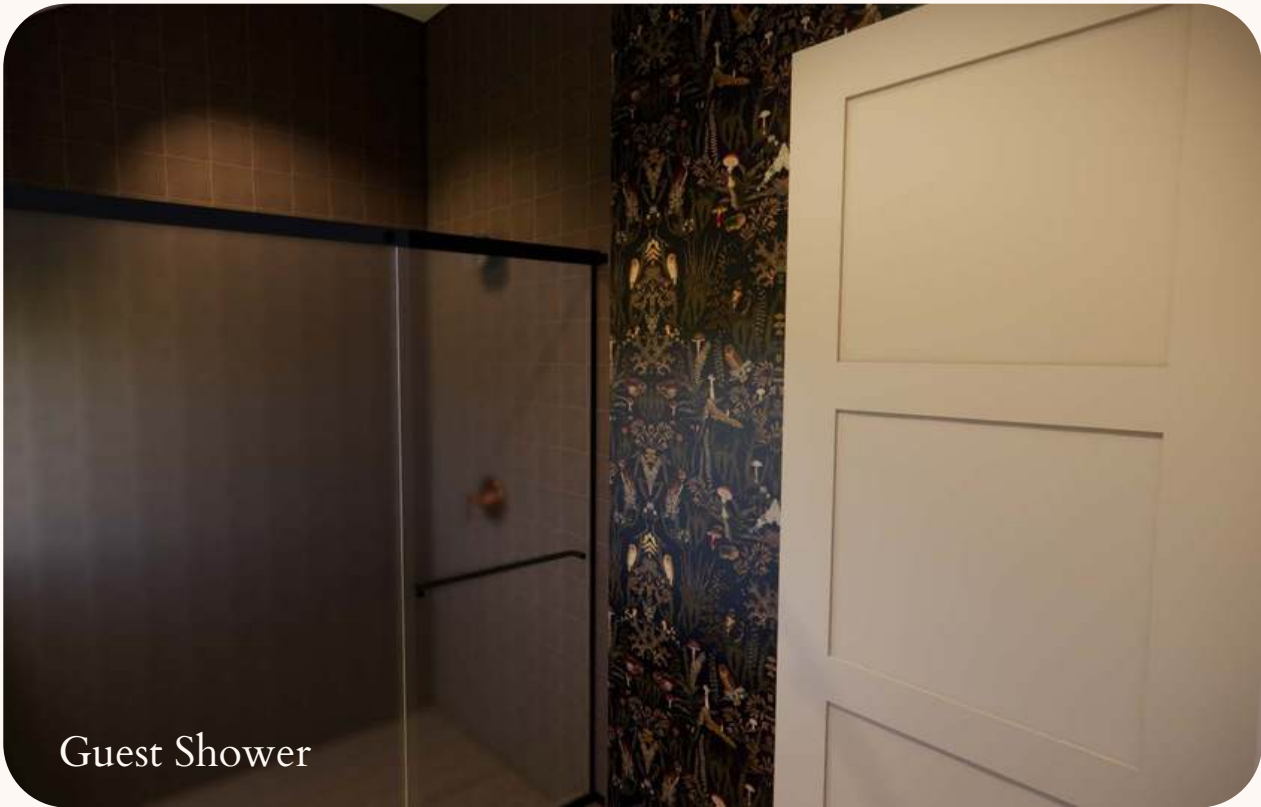

Guest Shower



Living Room



Guest Bathroom




Garage Proposal

Designed a clients to new garage to fit their needs after moving to Athens, GA

- AutoCAD 2024
- As-Built Floor Plan
- Isometric
- Elevations
- Sections
- Lighting and Electrical Plans




Garage Proposal

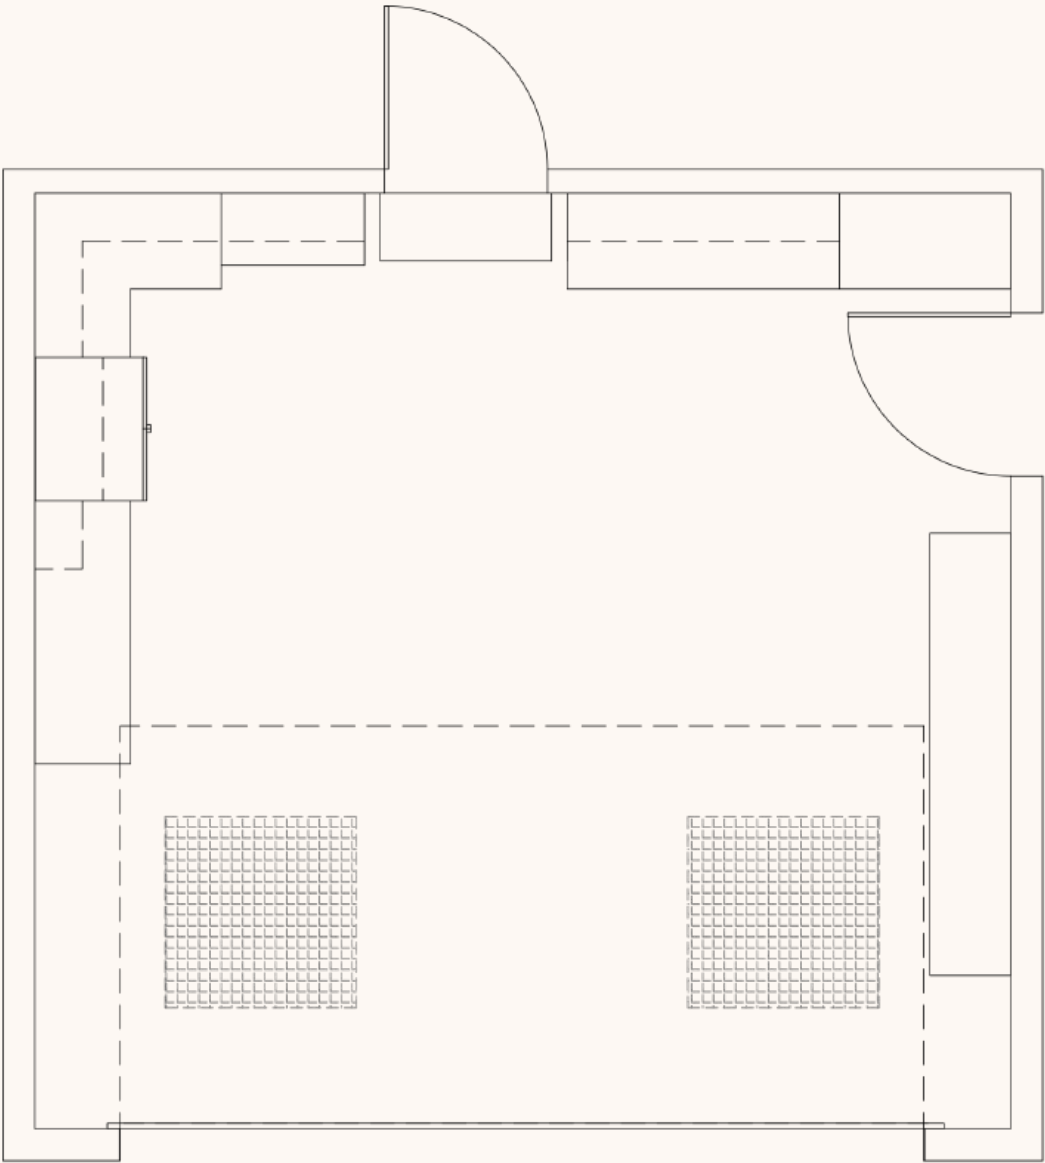


Proposed Floor Plan


Isometric

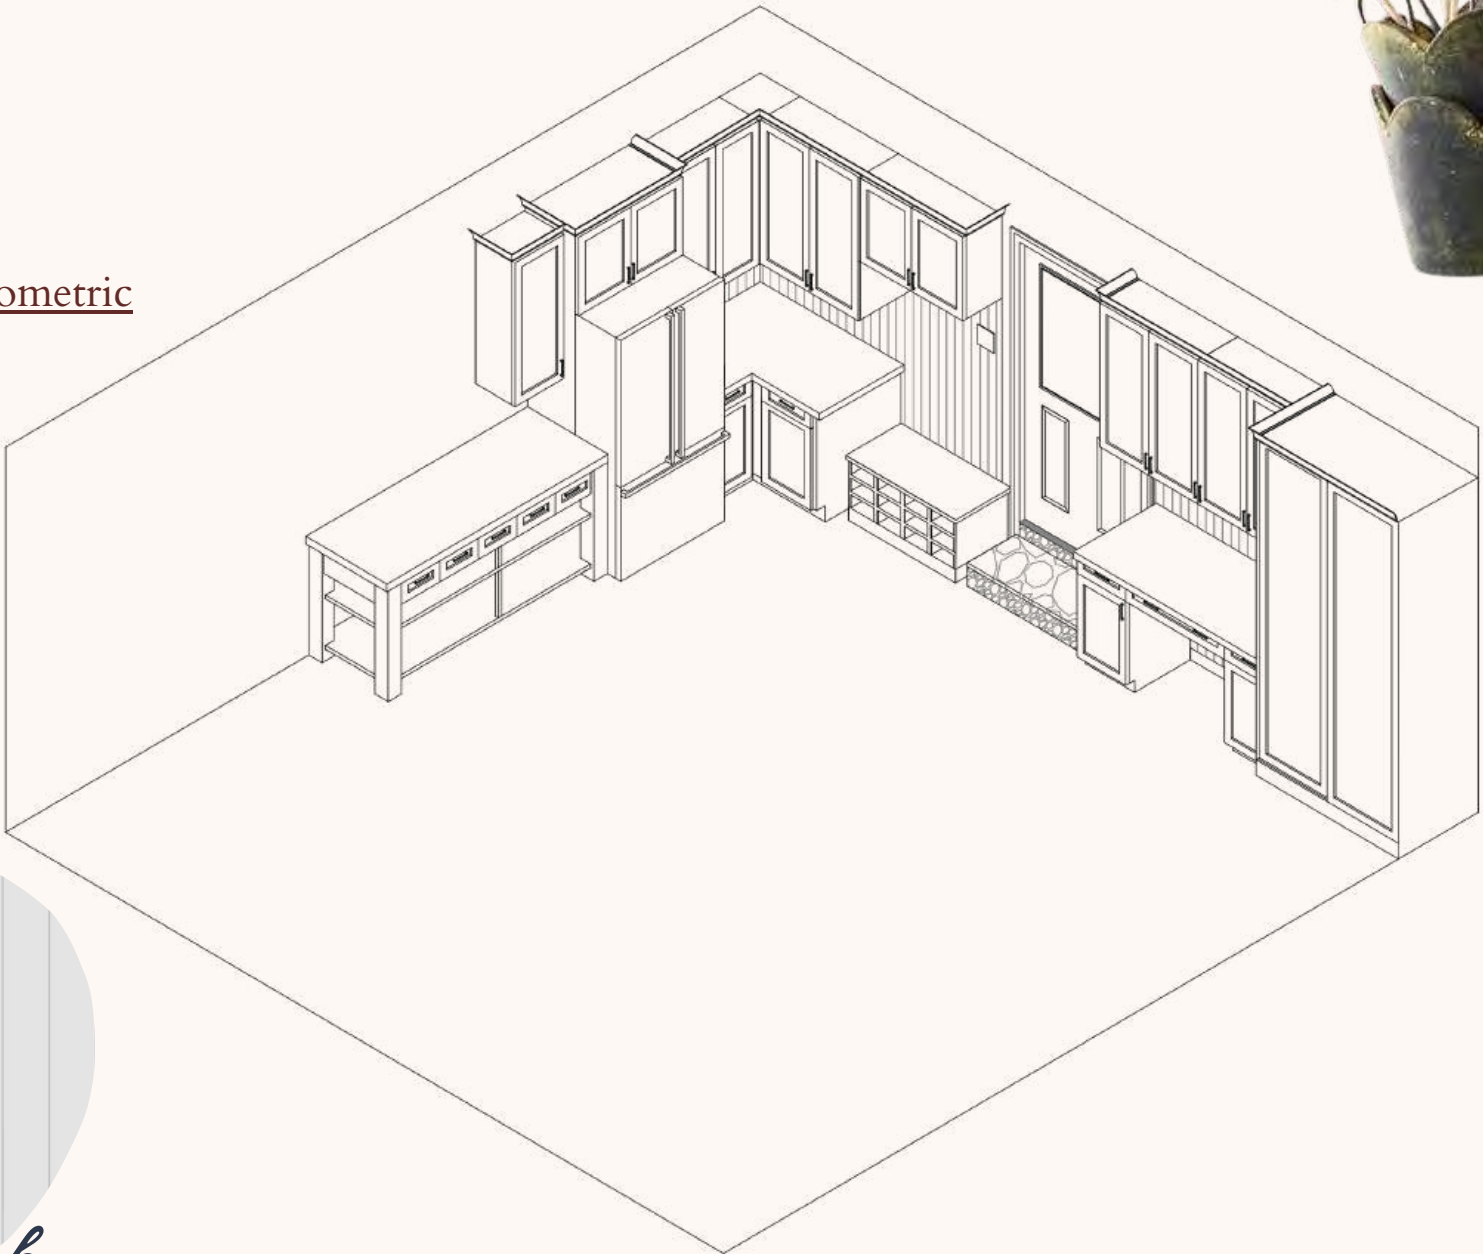

counter

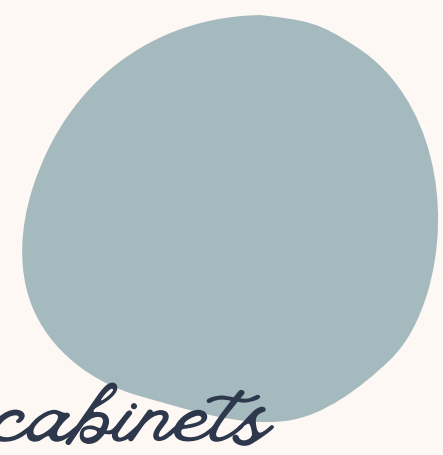

cabinets

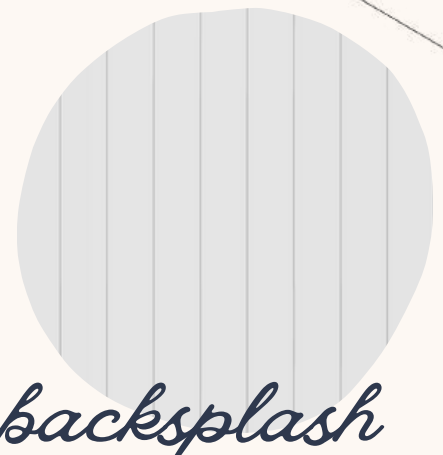


backsplash


Garage Proposal




North Elevation

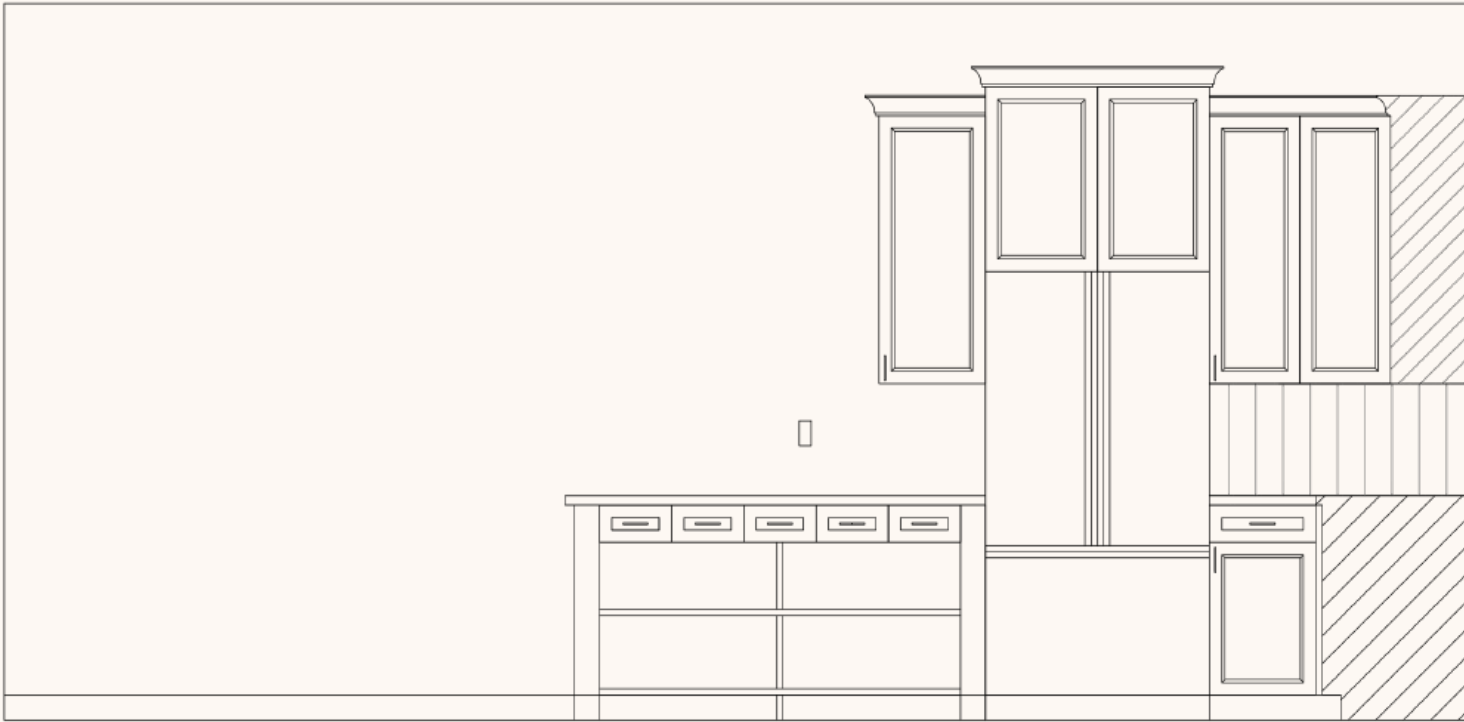

East Elevation

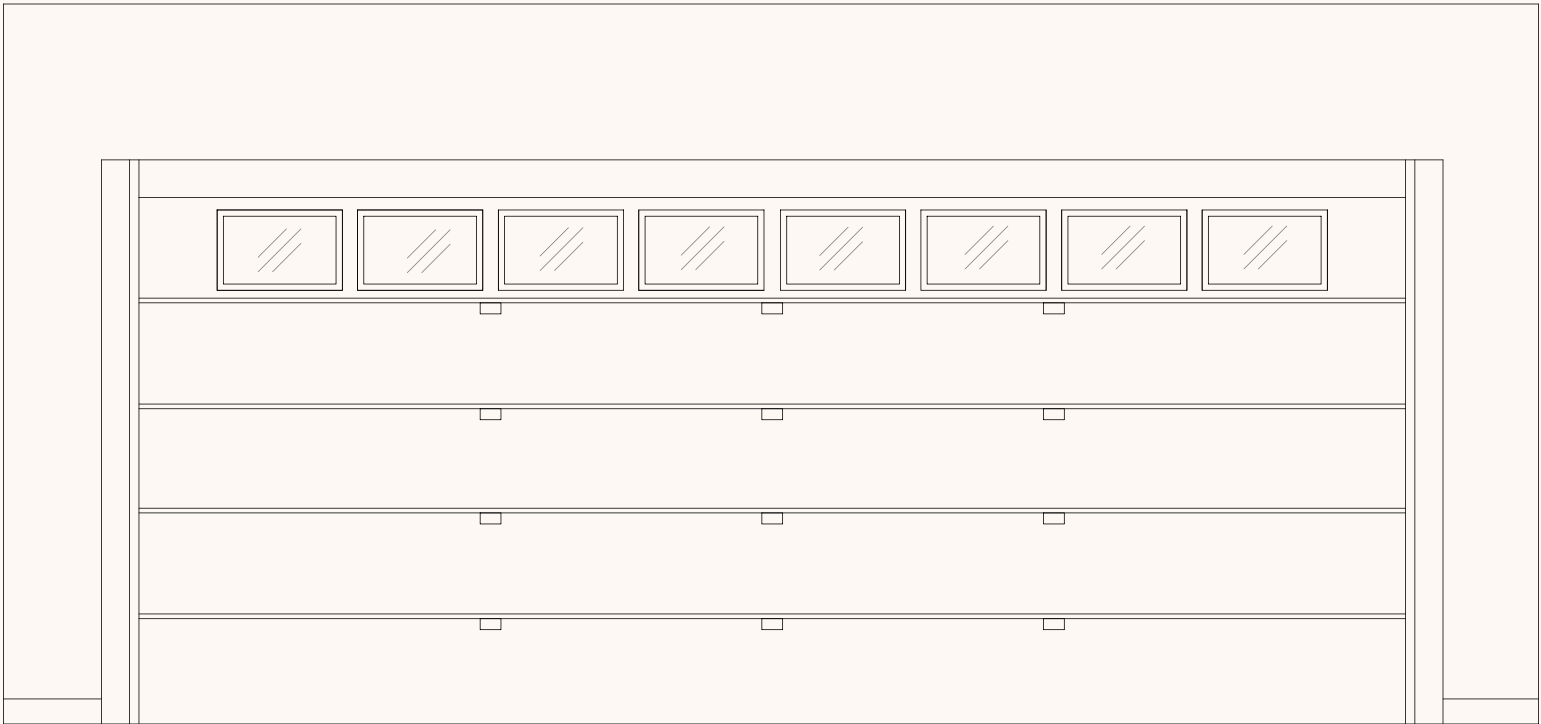

South Elevation

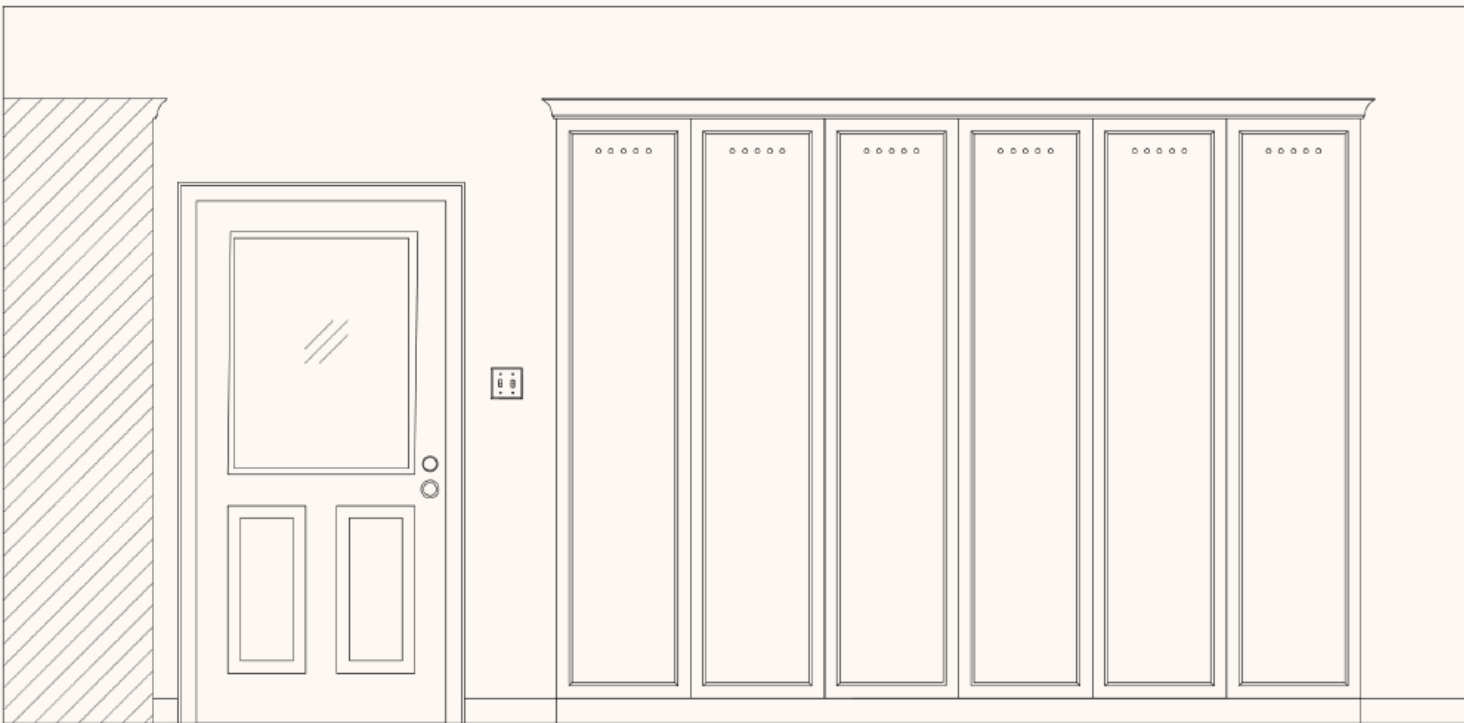

West Elevation





Thank You!

JAKE PEARSON

JPEARSON200413@GMAIL.COM

404.780.3807