



01 FRONT SECTION
SCALE: 3/16" = 1'-0"

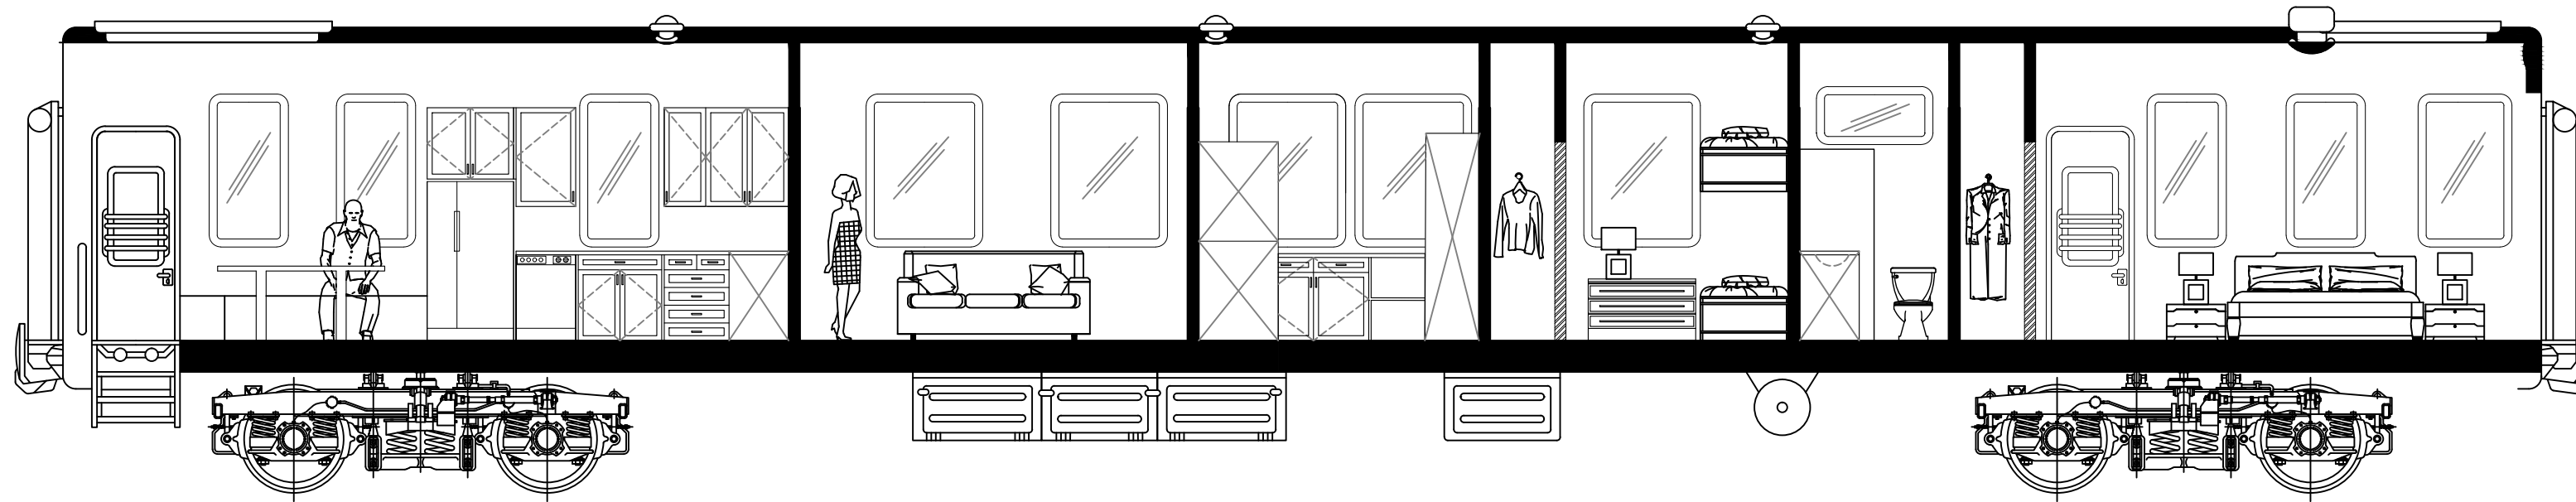

02 BACK SECTION
SCALE: 3/16" = 1'-0"

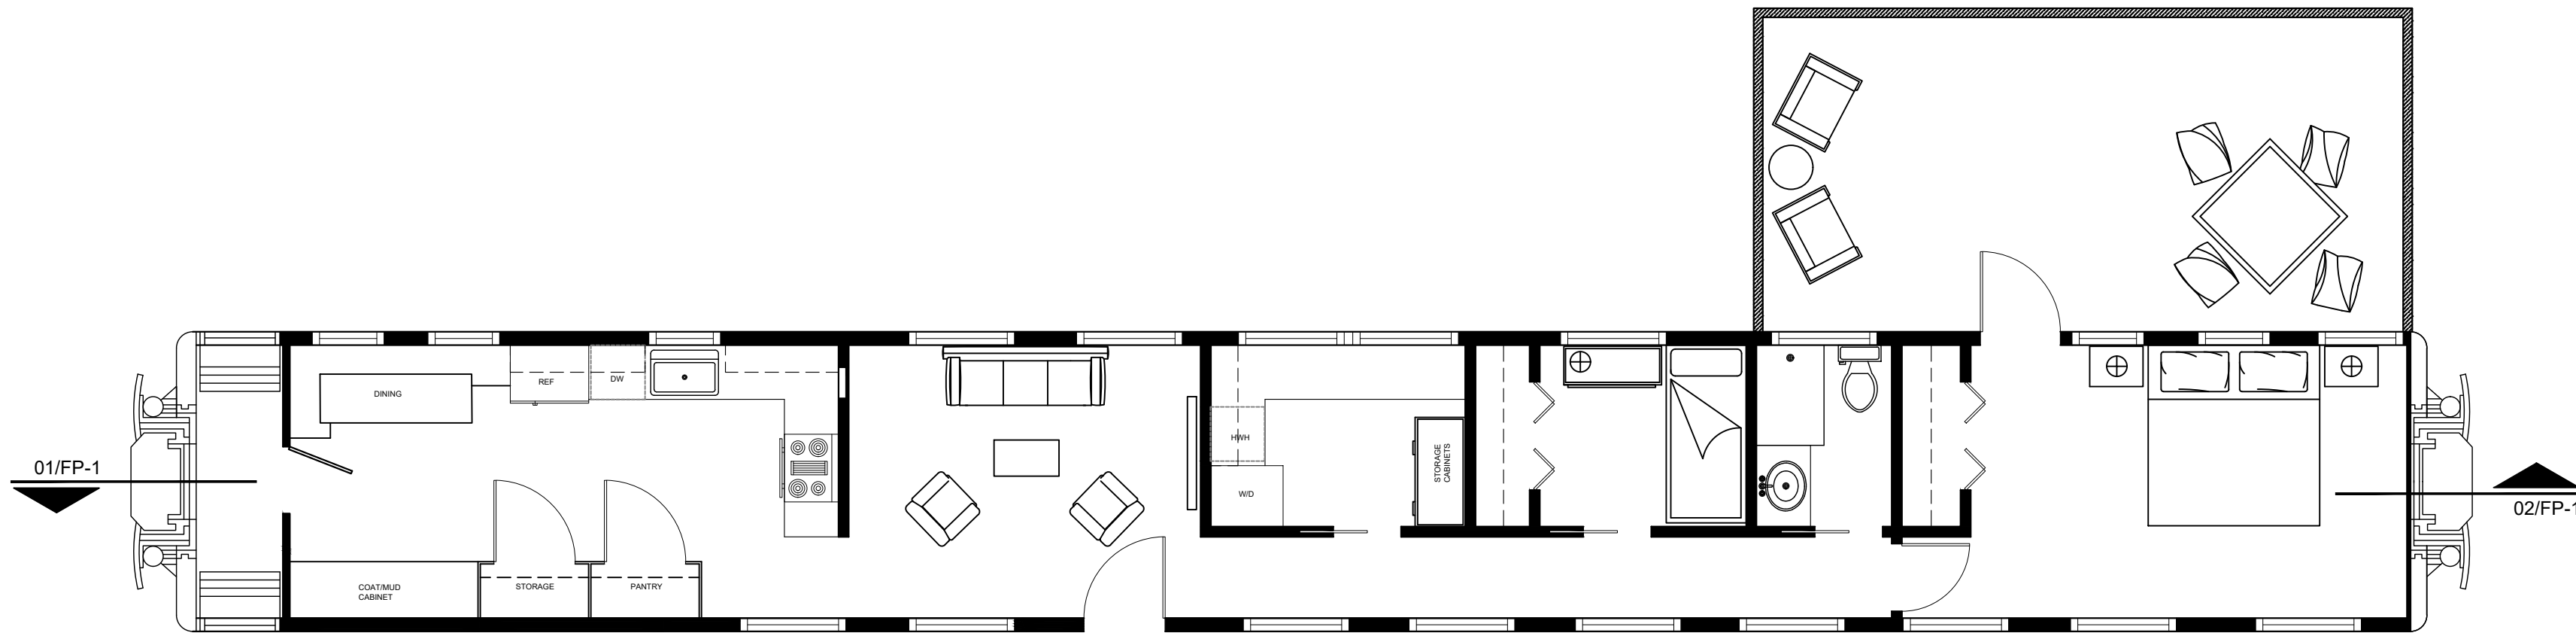

01 FLOOR PLAN
SCALE: 3/16" = 1'-0"


UNIVERSITY OF GEORGIA
TXMI 2370 STUDIO II - PROF. ELLENBERG
TRAIN CAR RENOVATION
CAREN BOWERS

REVISIONS

DATE: 4.01.23

SCALE: 3/16" = 1'-0"

FLOORPLAN AND
SECTIONS
FP-1

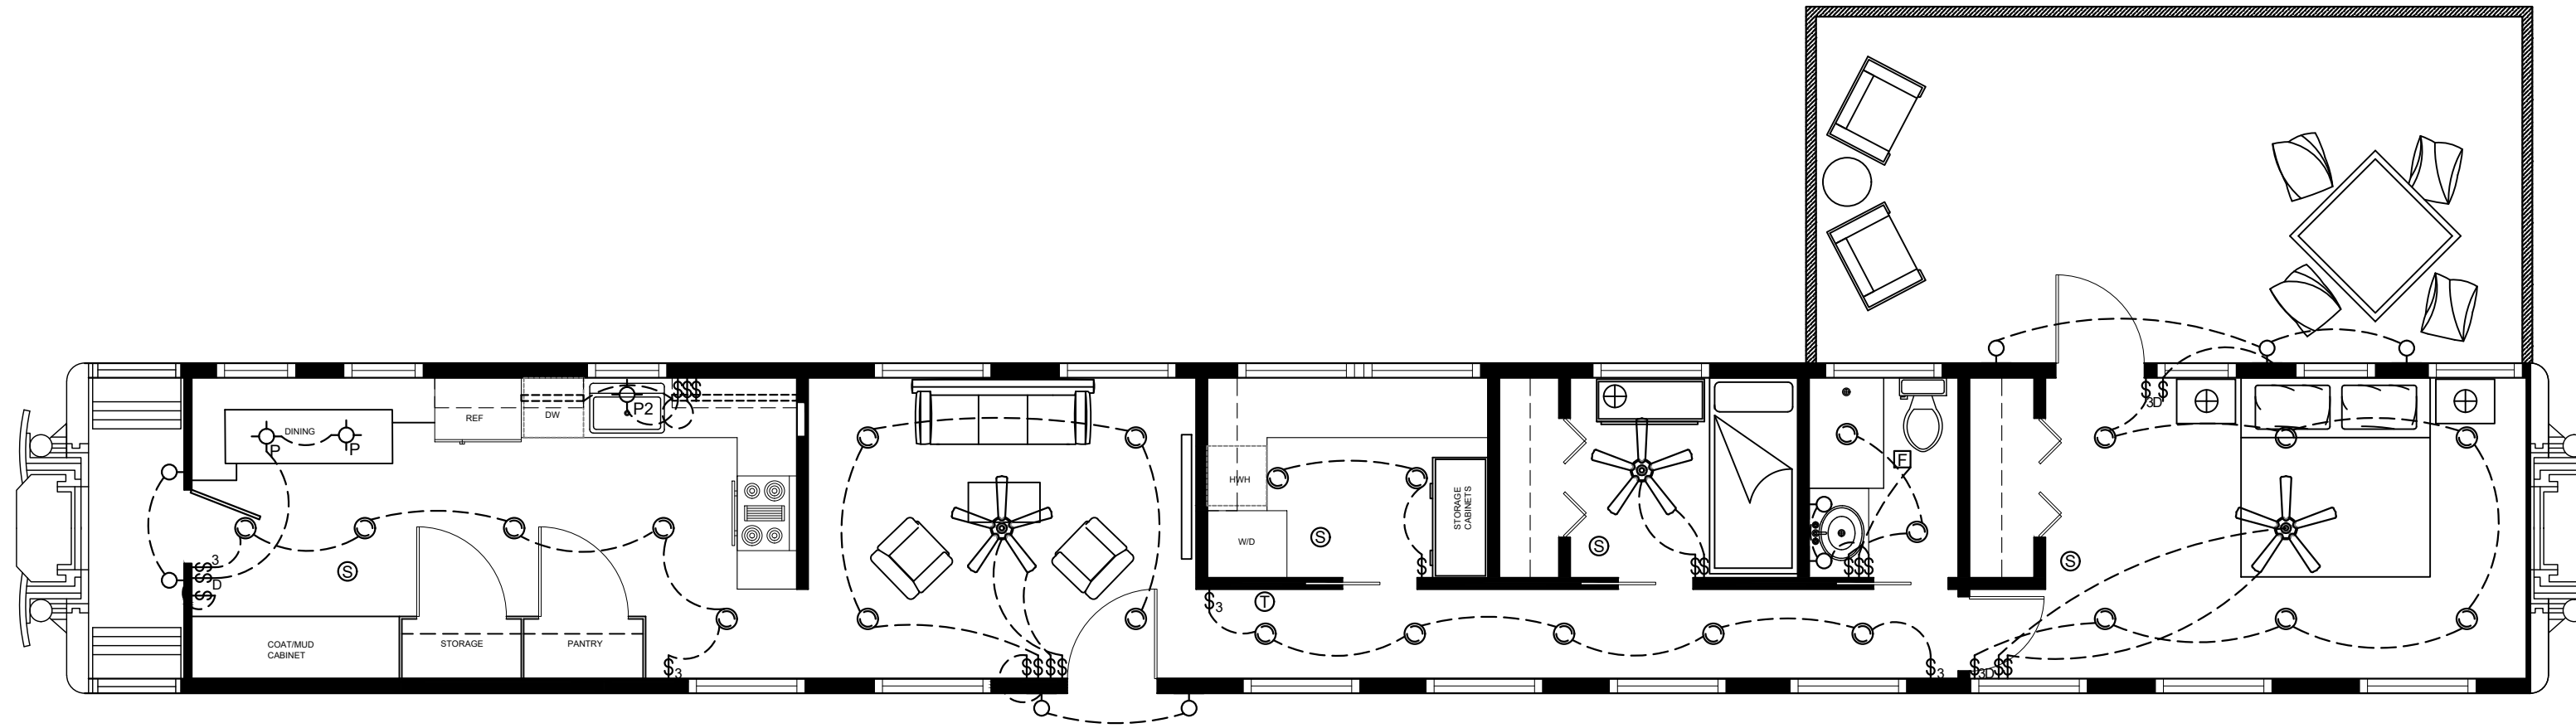

01 LIGHTING PLAN
SCALE: 3/16" = 1'-0"

LIGHTING LEGEND	
	HIDDEN STRIP FLUORESCENT/LED
	CEILING FAN WITH LIGHT KIT
	LED PENDANT FIXTURE
	EXHAUST FAN
	WALL SCONCE/WALL MOUNTED LIGHT FIXTURE
	LED DOWNLIGHT - RECESSED
	LED WALL WASHER - RECESSED
	STANDARD SINGLE POLE SWITCH
	STANDARD THREE-WAY SWITCH (USE WHEN YOU HAVE 2 SWITCHES AND 1 LIGHT)
	DIMMER SWITCH
	THERMOSTAT
	SMOKE DETECTOR



01 ELECTRICAL PLAN
SCALE: 3/16" = 1'-0"

ELECTRICAL LEGEND	
	WALL MOUNTED DUPLEX CONVENIENCE OUTLET
	WALL MOUNTED DUPLEX OUTLET WITH GROUND FAULT INTERRUPTER
	WALL MOUNTED WEATHER PROOF EXTERIOR OUTLET
	240 DUPLEX CONVENIENCE OUTLET
	WALL MOUNTED DUPLEX OUTLET AT 18" A.F.F. (ABOVE FINISHED FLOOR)
	DOOR BELL

UNIVERSITY OF GEORGIA
TXMI 2370 STUDIO II - PROF. ELLENBERG
TRAIN CAR RENOVATION
CAREN BOWERS

REVISIONS

DATE: 4.01.23

SCALE: 3/16" = 1'-0"

ELECTRICAL AND
LIGHTING PLAN

E/L-1