


ORIGINAL FRONT ELEVATION

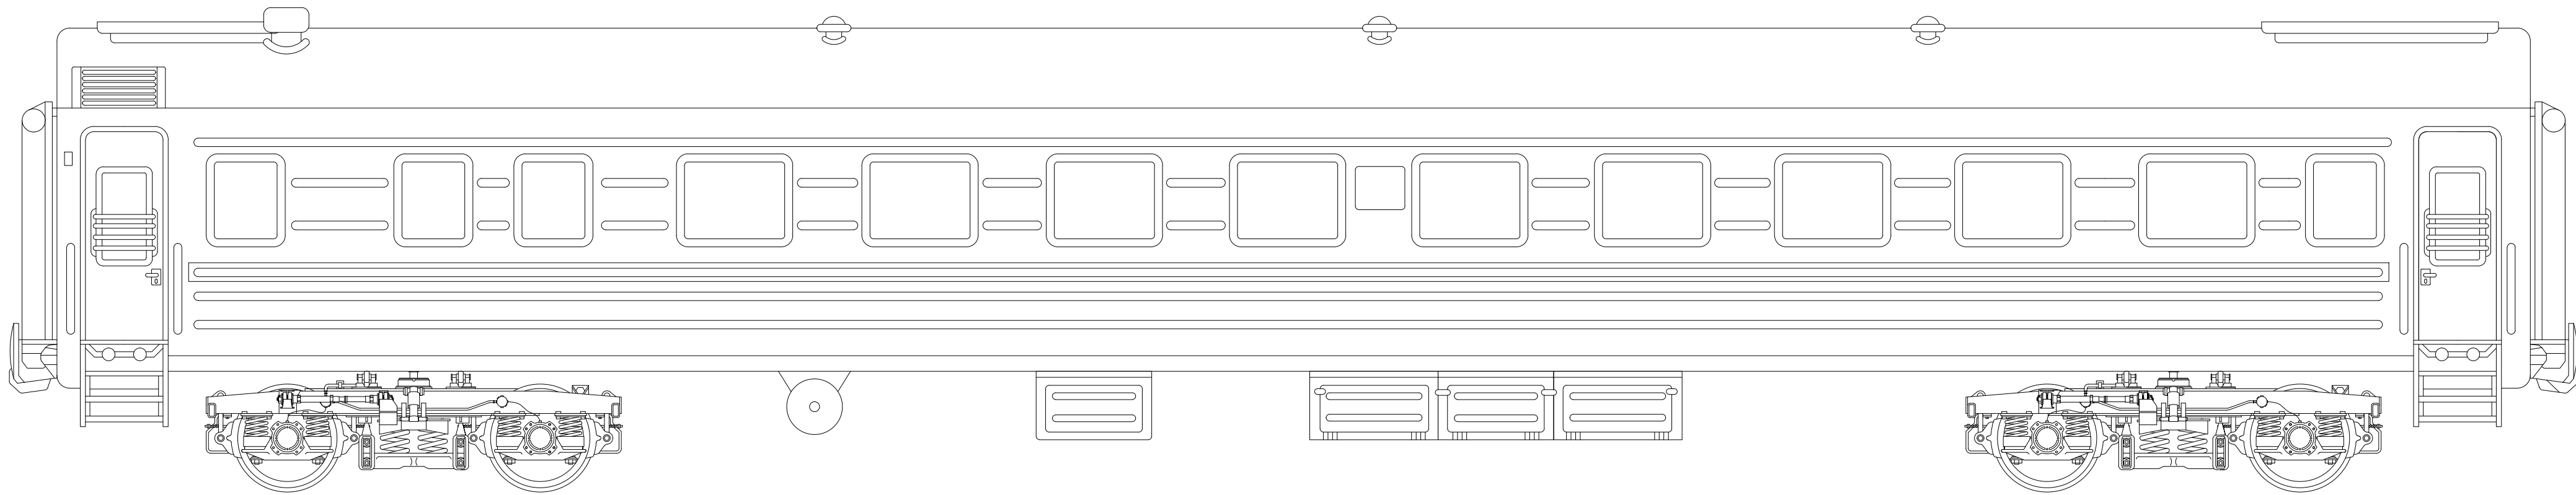

ORIGINAL BACK ELEVATION

INDEX OF DRAWINGS	
SHEET #	TITLE
CS-1	COVER SHEET
FP-1/S-1	FLOOR PLAN AND SECTION
L-1/E-1	LIGHTING AND ELEC. PLAN
P-1	PERSPECTIVES



UNIVERSITY OF GEORGIA
TXMI 2370 STUDIO II MS. ELLENBERG
TRAIN CAR RESIDENCE
SARAH BRITTON GIVENS

DATE: 04.24.2026

SCALE $\frac{1}{4}$ " = 1'-0"

COVER SHEET

CS-1

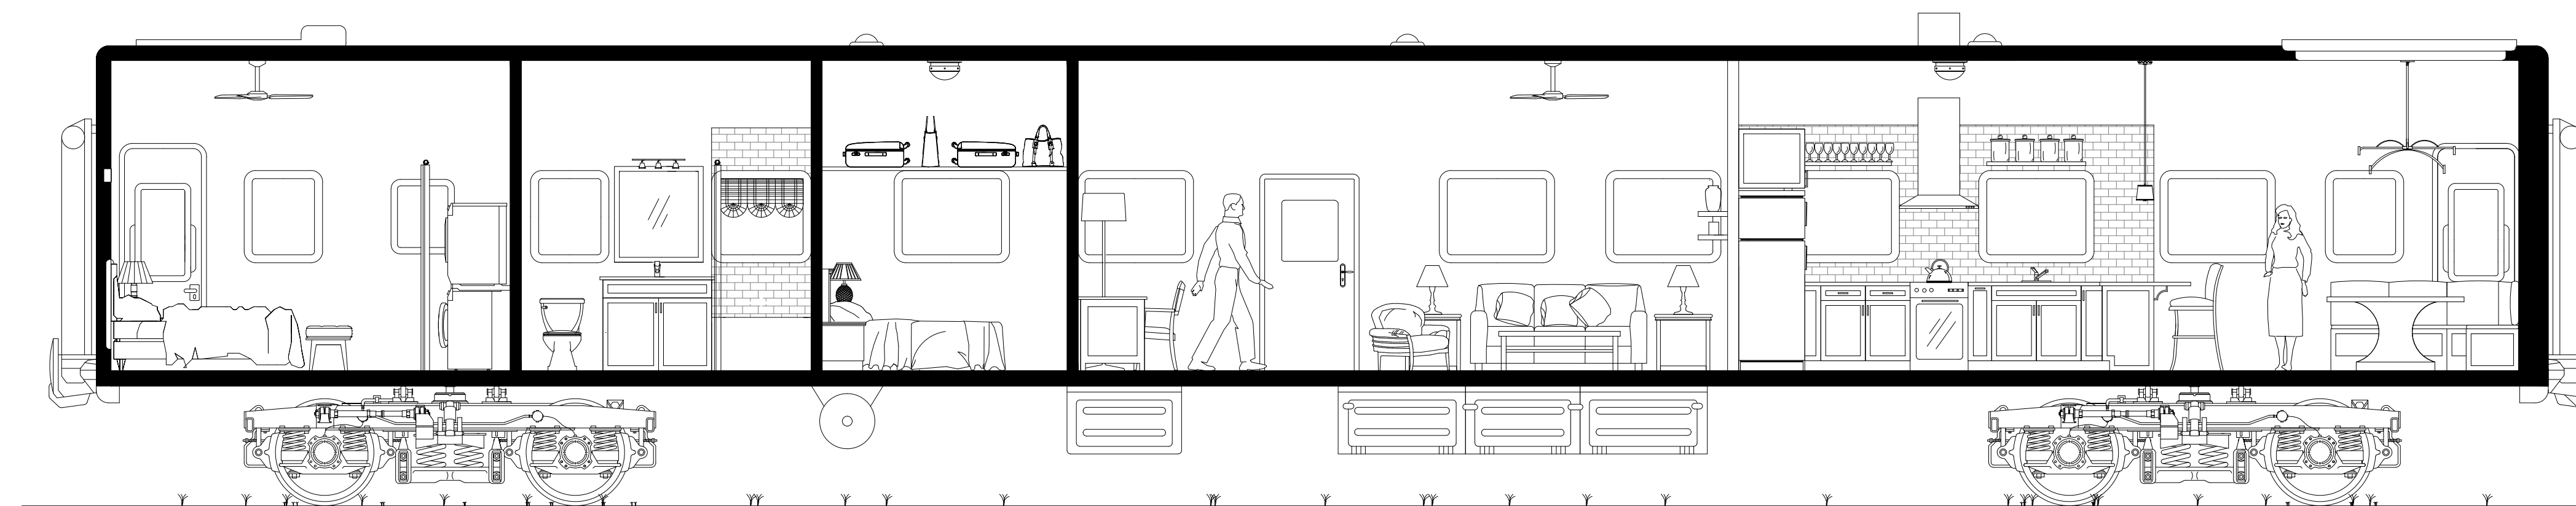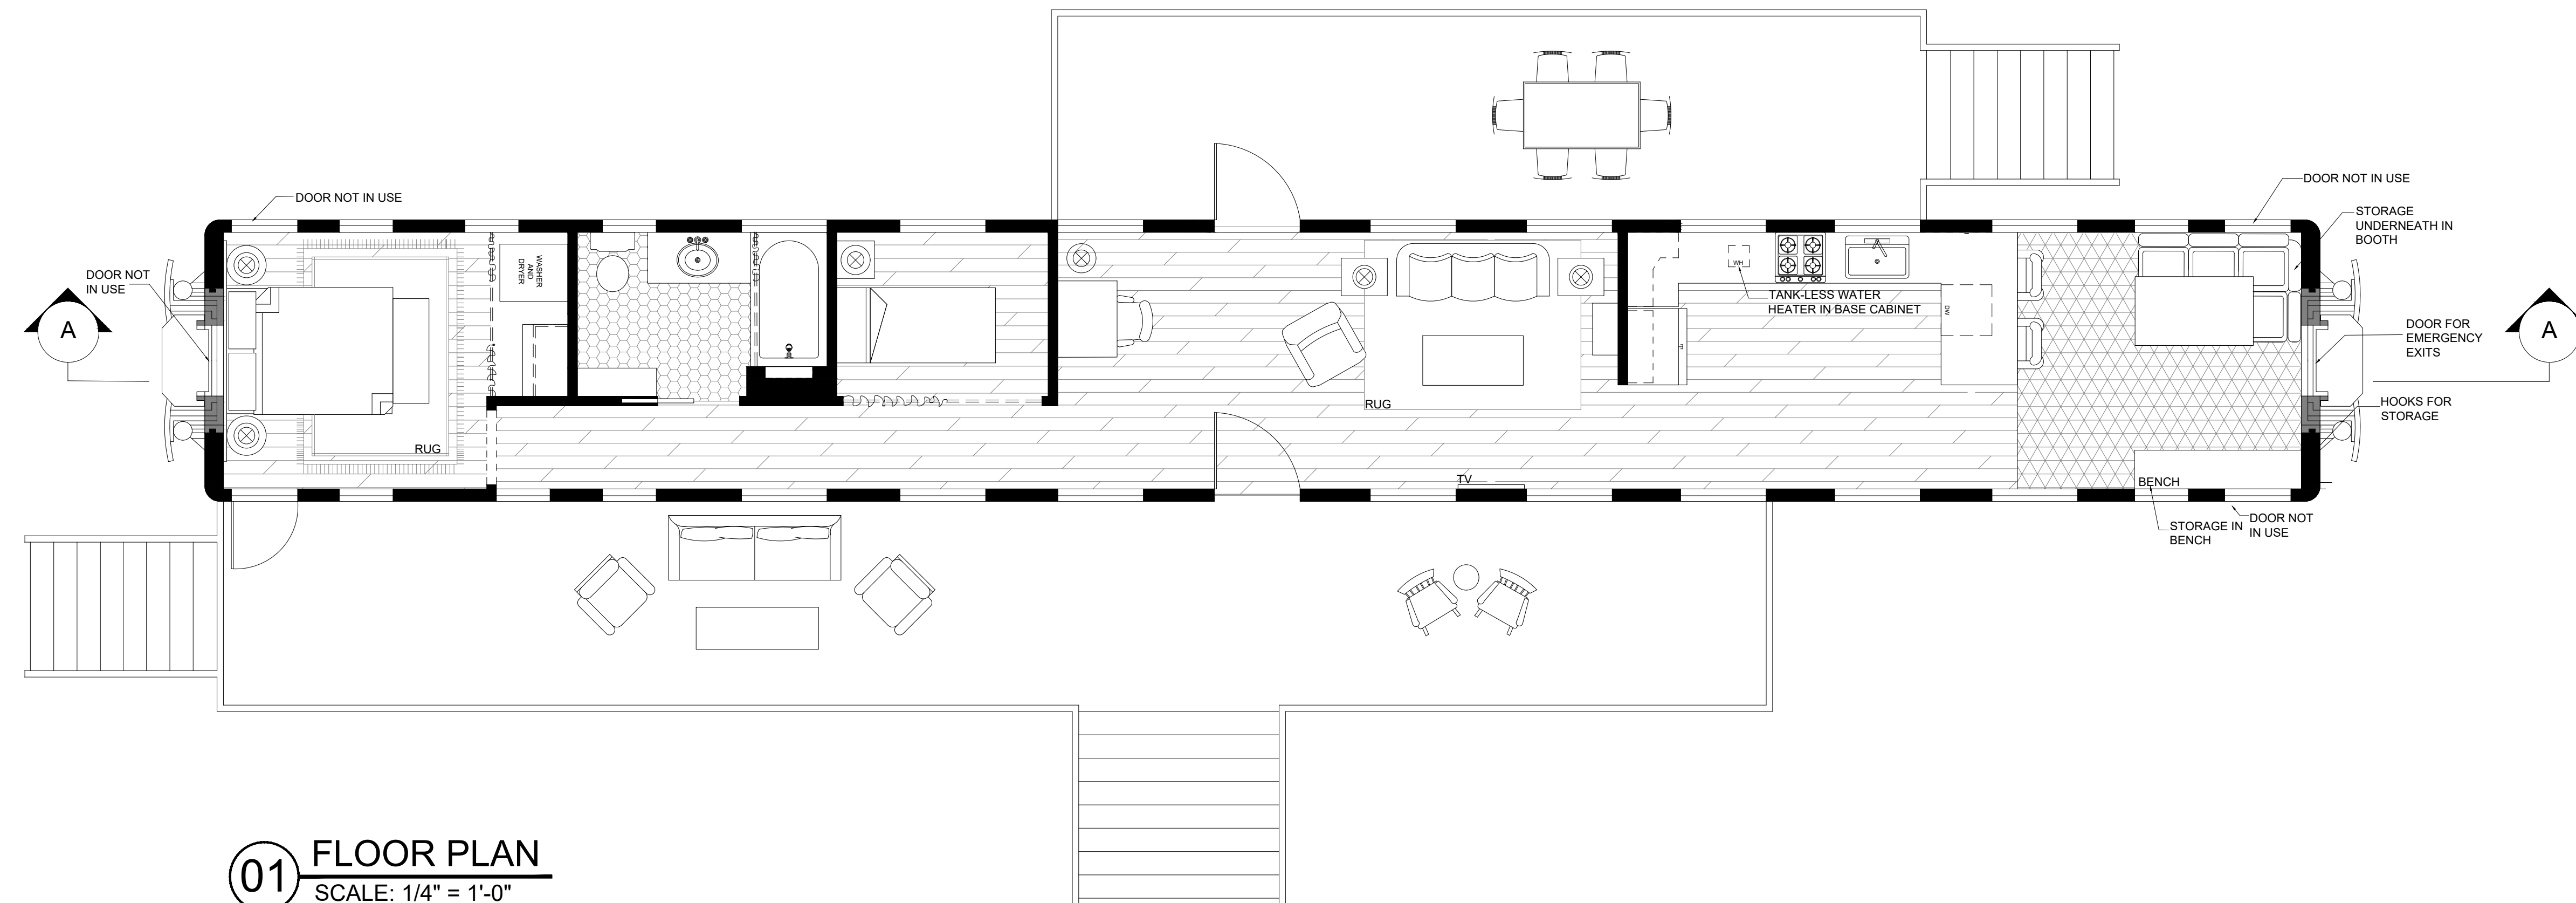


UNIVERSITY OF GEORGIA
TXMI 2370 STUDIO II MS. ELLENBERG
TRAIN CAR RESIDENCE
SARAH BRITTON GIVENS

DATE: 04.24.2026

CALE $\frac{1}{4} = 1'-0"$


FLOOR PLAN AND SECTION

FP-1 & S-1

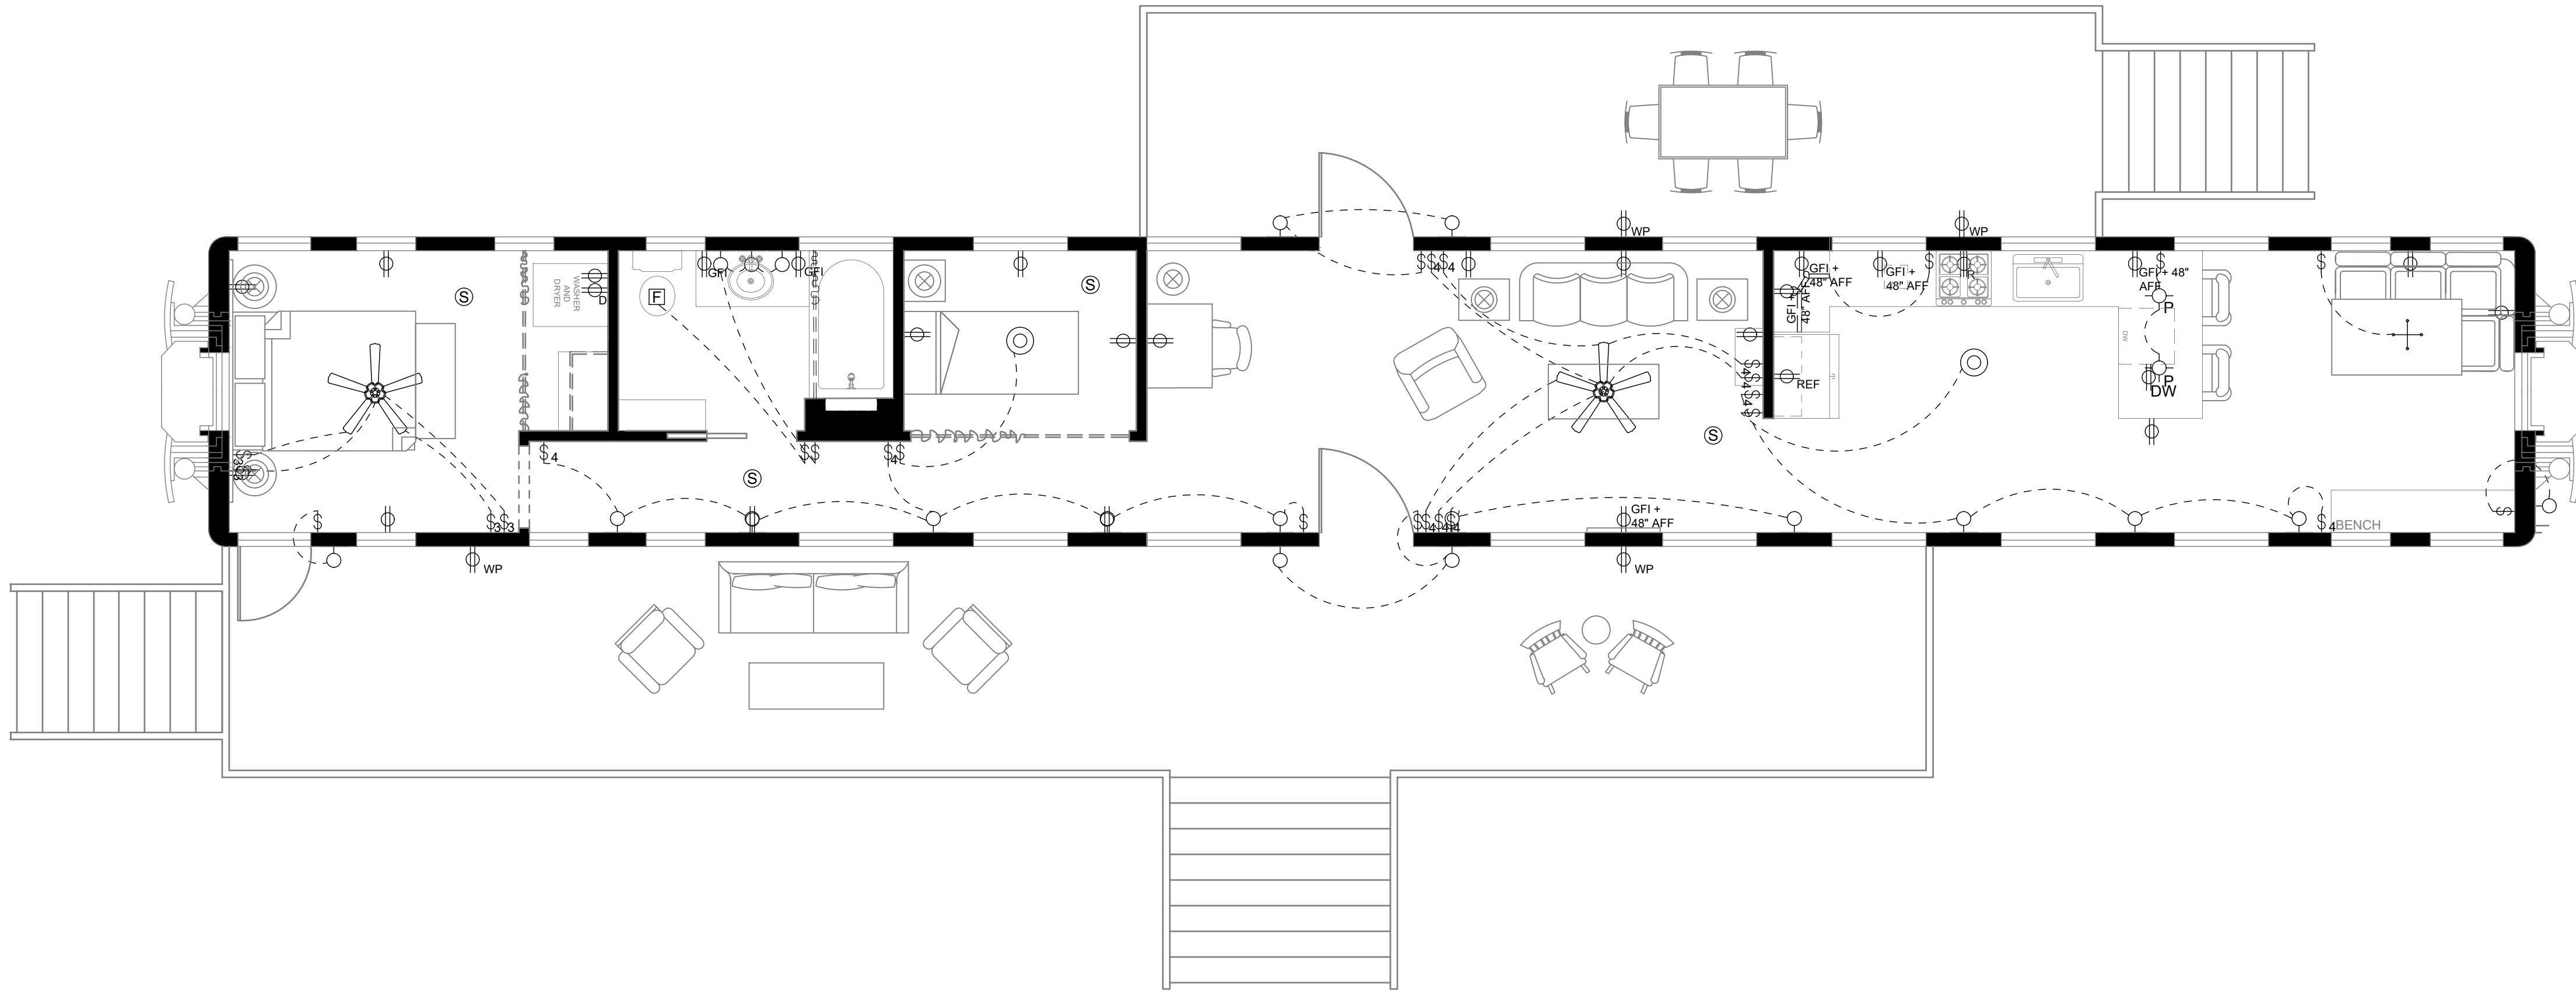

LIGHTING LEGEND	
	HIDDEN STRIP FLUORESCENT/LED
	LED PENDANT FIXTURE
	EXHAUST FAN
	WALL SCONCE/WALL MOUNTED LIGHT FIXTURE
	SURFACE MOUNTED LIGHT
	CHANDELIER
	VANITY LIGHT
	CEILING FAN WITH LIGHT KIT
	STANDARD SINGLE POLE SWITCH
	STANDARD THREE-WAY SWITCH (USE WHEN YOU HAVE 2 SWITCHES AND 1 LIGHT)
	STANDARD FOUR-WAY SWITCH (USE WHEN YOU HAVE 3 SWITCHES AND 1 OR MORE LIGHTS)
	SMOKE DETECTOR

01 LIGHTING PLAN
SCALE: 1/4" = 1'-0"

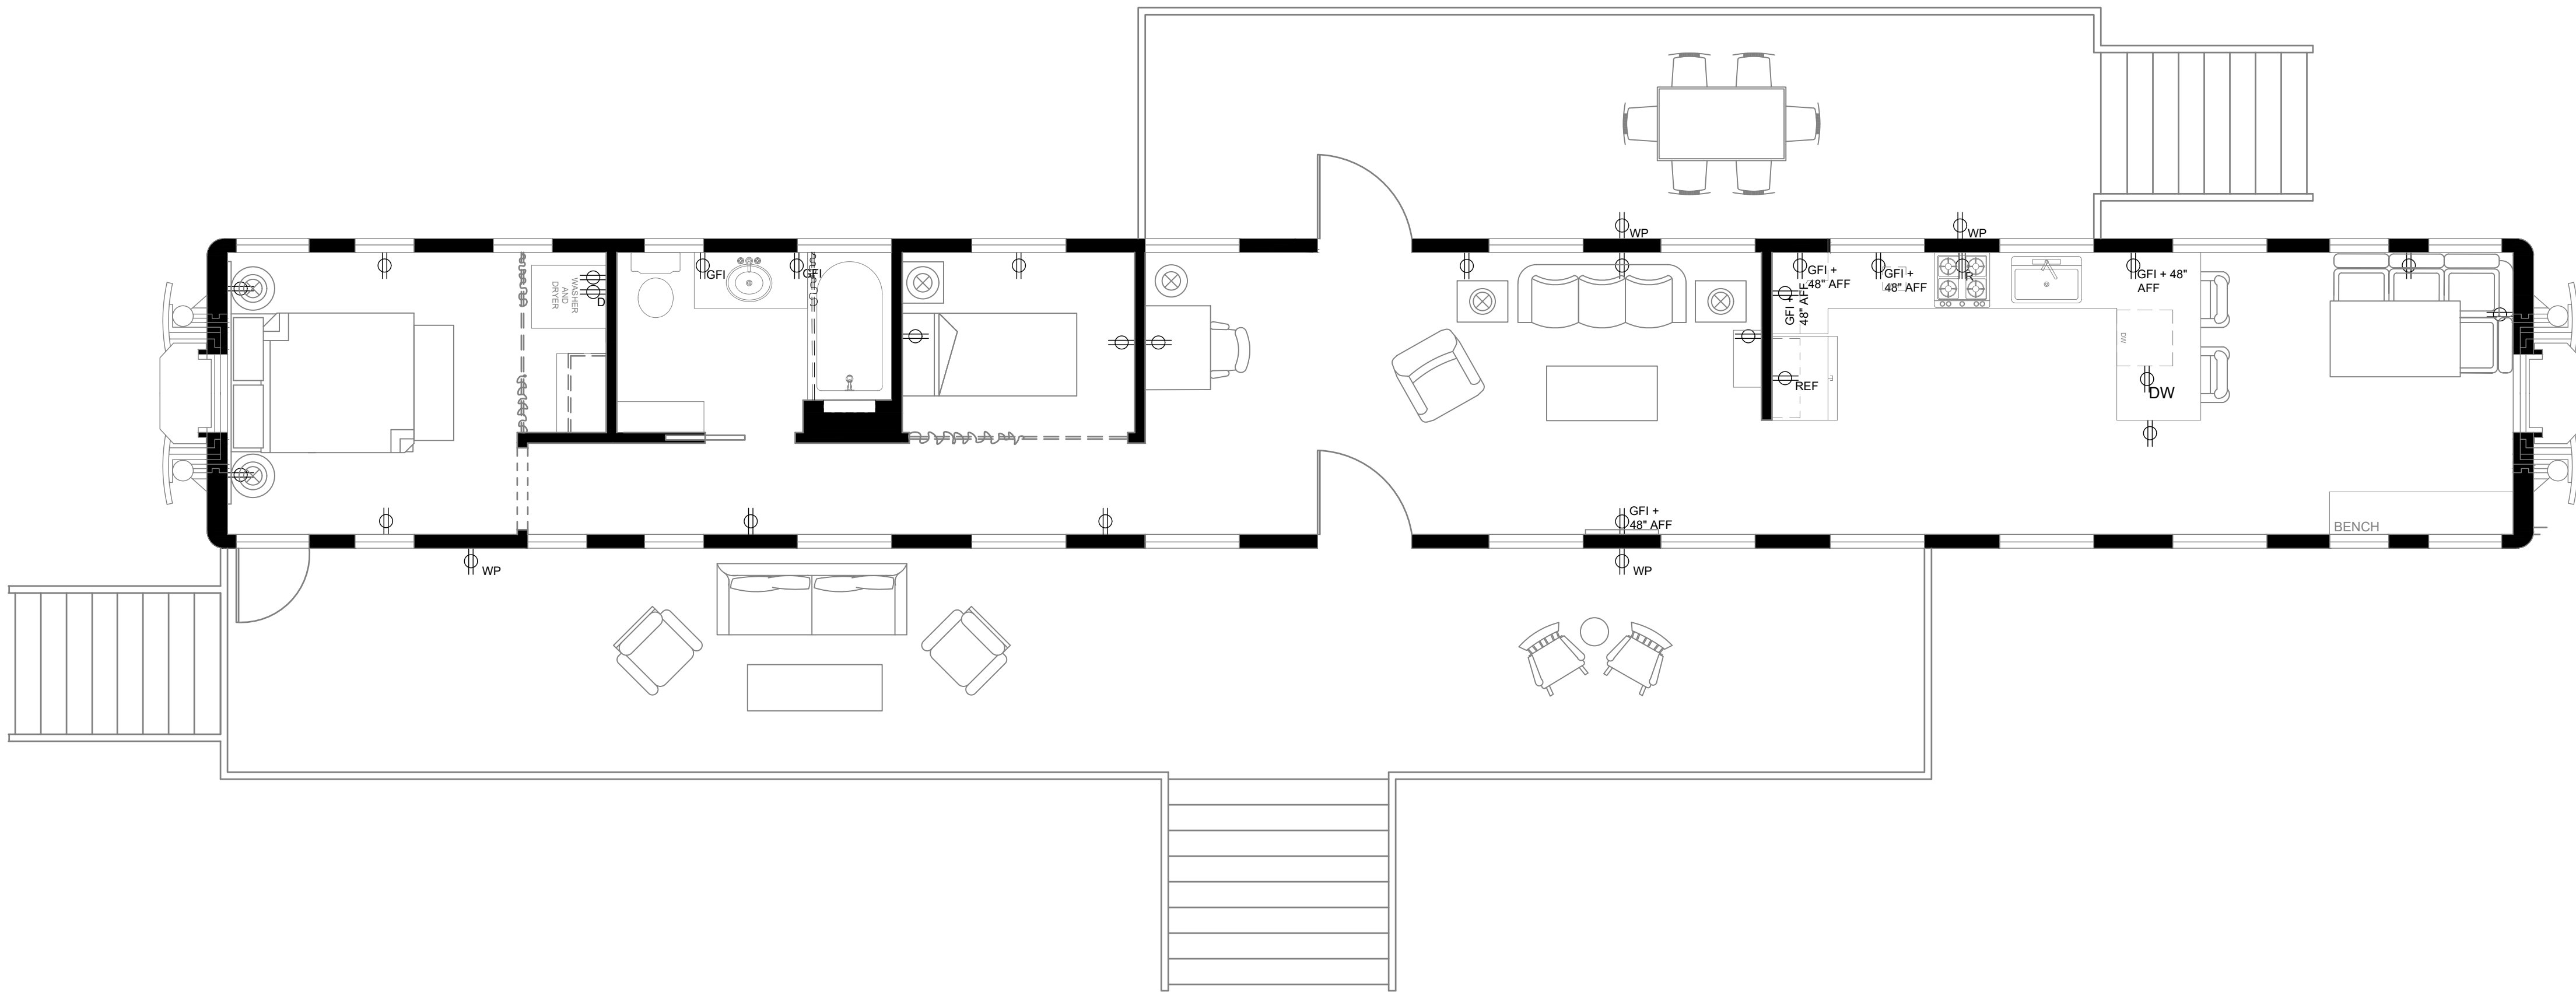


ELECTRICAL LEGEND	
	WALL MOUNTED DUPLEX CONVENIENCE OUTLET
	WALL MOUNTED DUPLEX OUTLET WITH GROUND FAULT INTERRUPTER
	EXTERIOR WEATHERPROOF OUTLET
	240 DUPLEX CONVENIENCE OUTLET
	240 DUPLEX DRYER OUTLET
	REFRIGERATOR OUTLET
	DISHWASHER OUTLET

01 ELECTRICAL PLAN
SCALE: 1/4" = 1'-0"



LIVING ROOM PERSPECTIVE

KITCHEN PERSPECTIVE

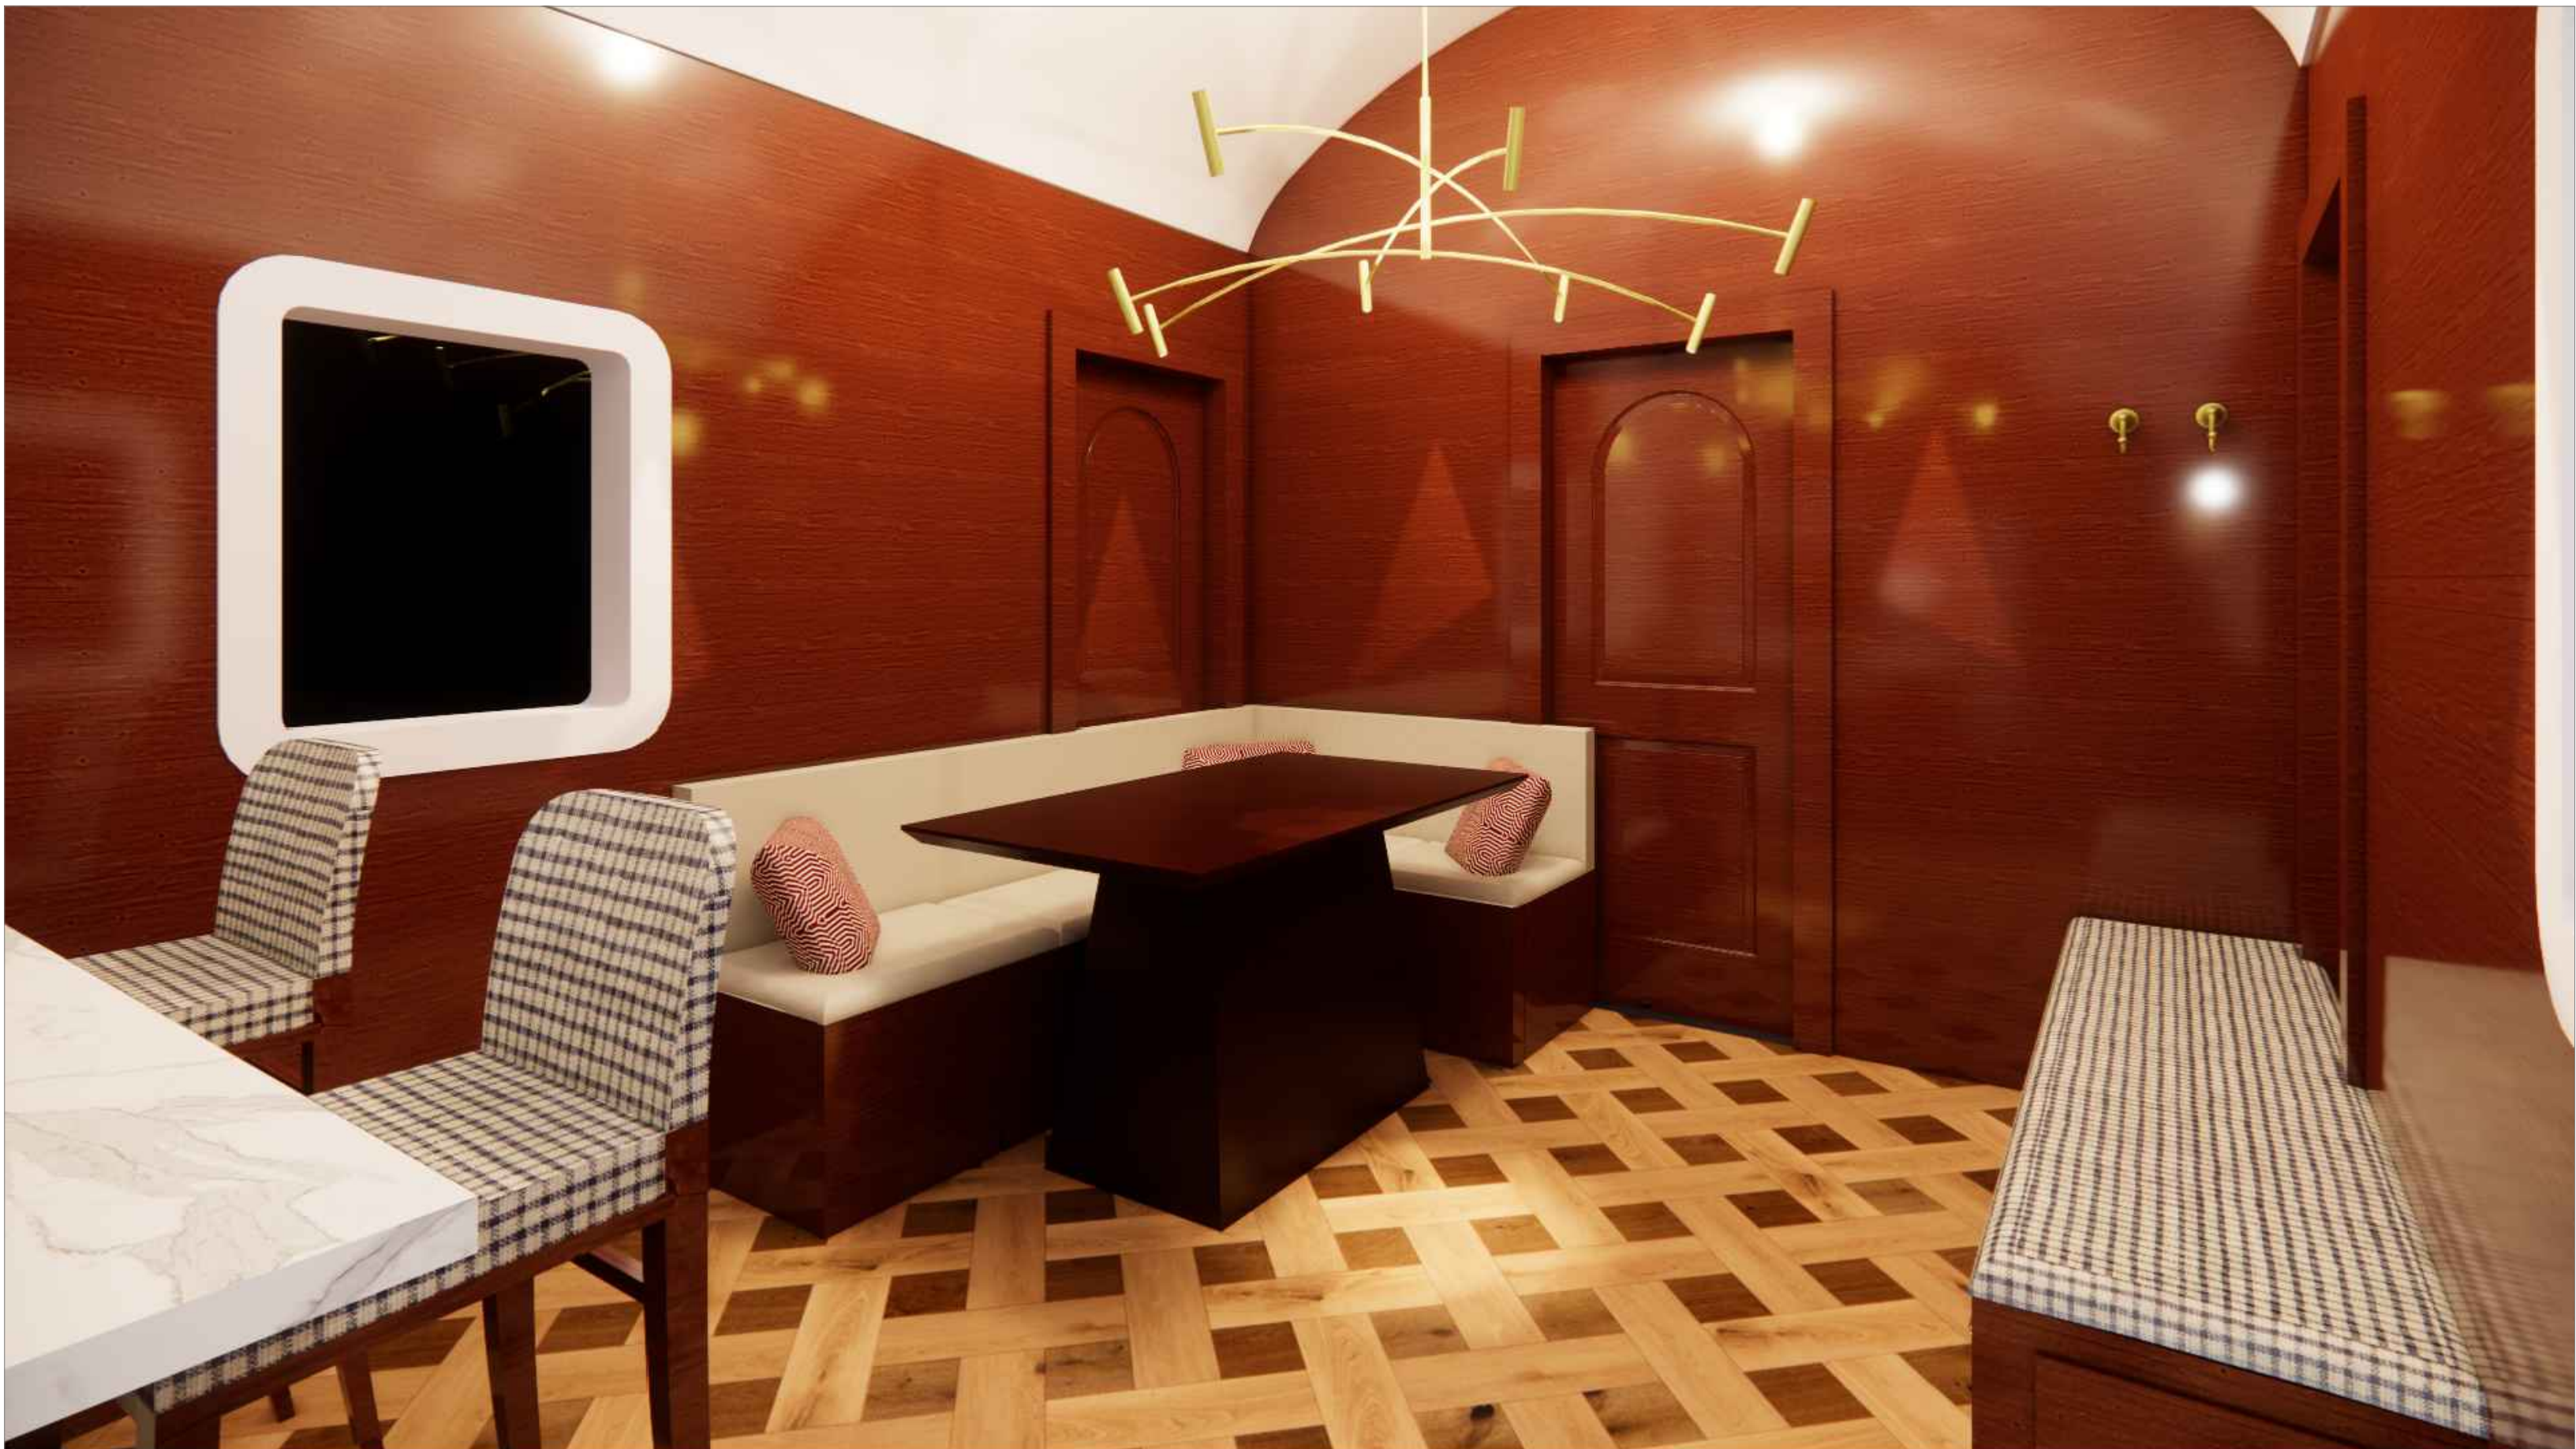

DINING ROOM PERSPECTIVE