



DUPLEX PLANS
17 CHERRY TREE LANE
CHICAGO, IL 60602

CODE & BUILDING INFORMATION, CHICAGO, IL:

Chicago Construction Codes Administrative Provisions
2019 Edition, with April 2022 Supplement

Chicago Building Code with Revised
2019 Edition, with April 2022 Supplement

Chicago Electrical Code (14E)
2018 Edition

INTERIM Chicago Fire Prevention Code (14F)

TITLE 14G FUEL GAS CODE

INTERIM Chicago Mechanical Code (14M)

Chicago Energy Transformation Code
2022 Edition

INTERIM Chicago Plumbing Code (14P)

INDEX OF DRAWINGS

SHEET #	TITLE
CS-1	COVER SHEET
ARCH-1	FIRST FLOOR PLAN
ARCH-2	SECOND FLOOR PLAN
SITE-3	ROOF & SITE PLAN
FF&E-4	FIRST FLR. FURNITURE PLAN
FF&E-5	SECOND FLR. FURNITURE PLAN
ELEC-6	FIRST FLR. ELECTRICAL PLAN
ELEC-7	SECOND FLR. ELECTRICAL PLAN
L-8	FIRST FLR. LIGHTING PLAN
L-9	SECOND FLR. LIGHTING PLAN
FIN-10	FIRST FLR. FINISH PLAN
FIN-11	SECOND FLR. FINISH PLAN
DET-12	INTERIOR ELEVATIONS & DETAILS
DET-13	INTERIOR ELEVATIONS & DETAILS
DET-14	EXTERIOR ELEVATION




REVISIONS:
DATE: 11.20.25

SCALE: $\frac{1}{4}" = 1' - 0"$

DOOR SCHEDULE								
SYMBOL	MANUFACTURER	ITEM NO.	LOCATION	SIZE	TYPE	MATERIAL	HARDWARE	QUANTITY
(1)	TruStile	PL243	ENTRY	6'-8" X 3'-0"	SOLID WOOD	WHITE OAK/GLASS	KEYED+DEADBOLT	2
(2)	TruStile	TS3300	INTERIOR	6'-8" X 6'-0"	SOLID SLIDING	WHITE OAK	HANDLE SET	2
(3)	TruStile	TS3300	INTERIOR	6'-8" X 2'-8"	SOLID POCKET	WHITE OAK	PRIVACY	6
(4)	TruStile	TS3300	INTERIOR	6'-8" X 2'-8"	SOLID WOOD	WHITE OAK	PRIVACY	6
(5)	TruStile	FL1310	PATIO	6'-8" X 3'-0"	SOLID FRENCH	WHITE OAK/GLASS	KEYED+DEADBOLT	4
(6)	TruStile	CUSTOM	INTERIOR	6'-8" X 3'-4"	SOLID SLIDING	WHITE OAK	HANDLE SET	6
(7)	TruStile	TS3300	INTERIOR	6'-8" X 2'-7"	SOLID WOOD	WHITE OAK	PRIVACY	4
(8)	TruStile	CUSTOM	INTERIOR	6'-8" X 3'-4"	LOUVERED WOOD	WHITE OAK	HANDLE SET	2
(9)	TruStile	CUSTOM	INTERIOR	6'-8" X 2'-0"	SOLID WOOD	WHITE OAK	HANDLE SET	2
(10)	TruStile	TS3300	GARAGE	6'-8" X 3'-0"	SOLID WOOD	WHITE OAK	KEYED+DEADBOLT	4
(11)	Craft Doors USA	CUSTOM	GARAGE	7'-0" X 16'-4"	GARAGE	WOOD/GLASS	ELEC KEYPAD	2
(12)	TruStile	TS3300	INTERIOR	6'-8" X 2'-6"	SOLID POCKET	WHITE OAK	PRIVACY	6
(13)	TruStile	TS3300	INTERIOR	6'-8" X 3'-0"	SOLID WOOD	WHITE OAK	HANDLE SET	2
(14)	Creative Mirror & Shower	CUSTOM	INTERIOR	6'-8" X 1'-9"	SHOWER	GLASS	UNLACQUERED BRASS PULL	2

WINDOW SCHEDULE					
SYMBOL	MANUFACTURER	SIZE	TYPE	MATERIAL	QUANTITY
(A)	MARVIN	4'-2" X 4'-6"	FIXED	STAINED GLASS	2
(B)	MARVIN	3'-2" X 5'-0"	SINGLE HUNG	WOOD/GLASS	22
(C)	MARVIN	2'-7" X 5'-0"	SINGLE HUNG	WOOD/GLASS	2

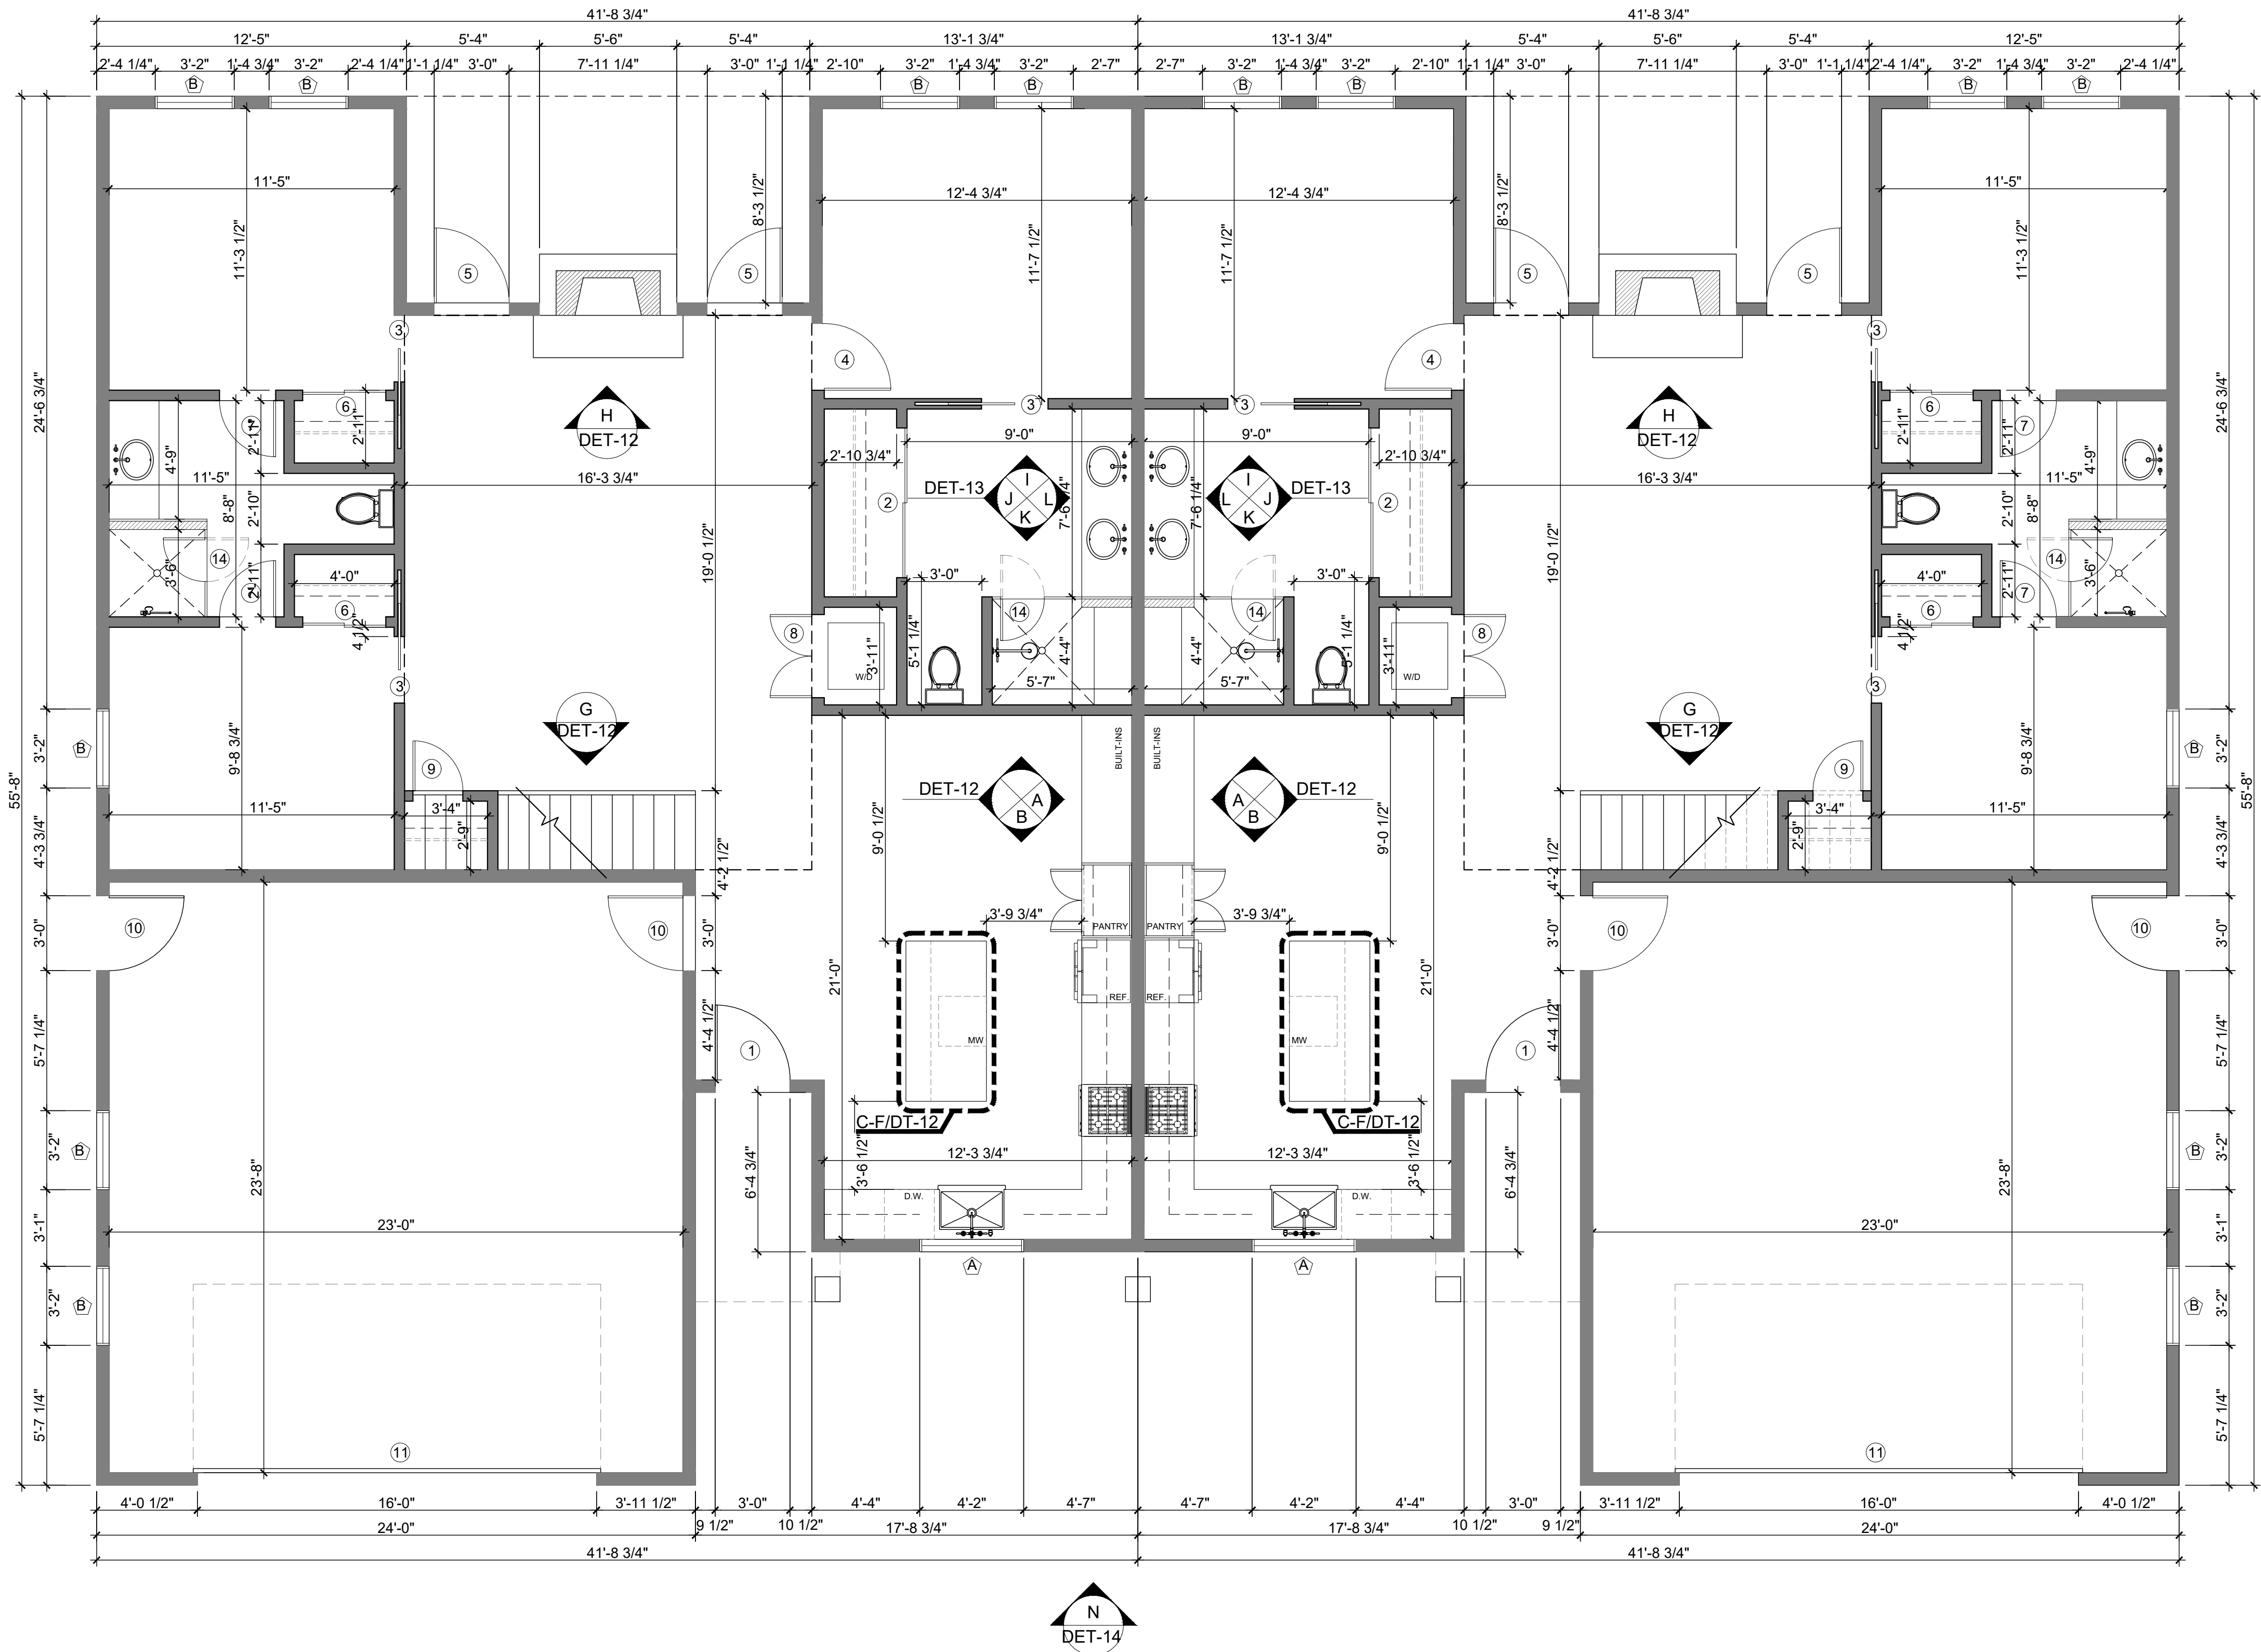

01 FIRST FLOOR PLAN
SCALE: $\frac{1}{4}" = 1' - 0"$



REVISIONS:
DATE: 11.20.25

SCALE: 1/4" = 1'-0"

DOOR SCHEDULE							
SYMBOL	MANUFACTURER	ITEM NO.	LOCATION	SIZE	TYPE	MATERIAL	HARDWARE
(1)	TruStile	FL243	ENTRY	6'-8" X 3'-0"	SOLID WOOD	WHITE OAK/GLASS	KEYED+DEADBOLT
(2)	TruStile	TS3300	INTERIOR	6'-8" X 6'-0"	SOLID SLIDING	WHITE OAK	HANDLE SET
(3)	TruStile	TS3300	INTERIOR	6'-8" X 2'-8"	SOLID POCKET	WHITE OAK	PRIVACY
(4)	TruStile	TS3300	INTERIOR	6'-8" X 2'-8"	SOLID WOOD	WHITE OAK	PRIVACY
(5)	TruStile	FL1310	PATIO	6'-8" X 3'-0"	SOLID FRENCH	WHITE OAK/GLASS	KEYED+DEADBOLT
(6)	TruStile	CUSTOM	INTERIOR	6'-8" X 3'-4"	SOLID SLIDING	WHITE OAK	HANDLE SET
(7)	TruStile	TS3300	INTERIOR	6'-8" X 2'-7"	SOLID WOOD	WHITE OAK	PRIVACY
(8)	TruStile	CUSTOM	INTERIOR	6'-8" X 3'-4"	LOUVERED WOOD	WHITE OAK	HANDLE SET
(9)	TruStile	CUSTOM	INTERIOR	6'-8" X 2'-0"	SOLID WOOD	WHITE OAK	HANDLE SET
(10)	TruStile	TS3300	GARAGE	6'-8" X 3'-0"	SOLID WOOD	WHITE OAK	KEYED+DEADBOLT
(11)	Craft Doors USA	CUSTOM	GARAGE	7'-0" X 16'-4"	GARAGE	WOOD/GLASS	ELEC KEYPAD
(12)	TruStile	TS3300	INTERIOR	6'-8" X 2'-6"	SOLID POCKET	WHITE OAK	PRIVACY
(13)	TruStile	TS3300	INTERIOR	6'-8" X 3'-0"	SOLID WOOD	WHITE OAK	HANDLE SET
(14)	Creative Mirror & Shower	CUSTOM	INTERIOR	6'-8" X 1'-9"	SHOWER	GLASS	UNLACQUERED BRASS PULL

WINDOW SCHEDULE					
SYMBOL	MANUFACTURER	SIZE	TYPE	MATERIAL	QUANTITY
(A)	MARVIN	4'-2" X 4'-6"	FIXED	STAINED GLASS	2
(B)	MARVIN	3'-2" X 5'-0"	SINGLE HUNG	WOOD/GLASS	22
(C)	MARVIN	2'-7" X 5'-0"	SINGLE HUNG	WOOD/GLASS	2



02 SECOND FLOOR PLAN
SCALE: 1/4" = 1'-0"




UNIVERSITY OF GEORGIA
TXMI 4300 STUDIO V: RICH
RESIDENTIAL DUPLEX CD SET
MONICA MAZUREK

REVISIONS:
DATE: 11.20.25

SCALE: $\frac{1}{4}" = 1' - 0"$

ROOF & SITE PLAN
SITE-3

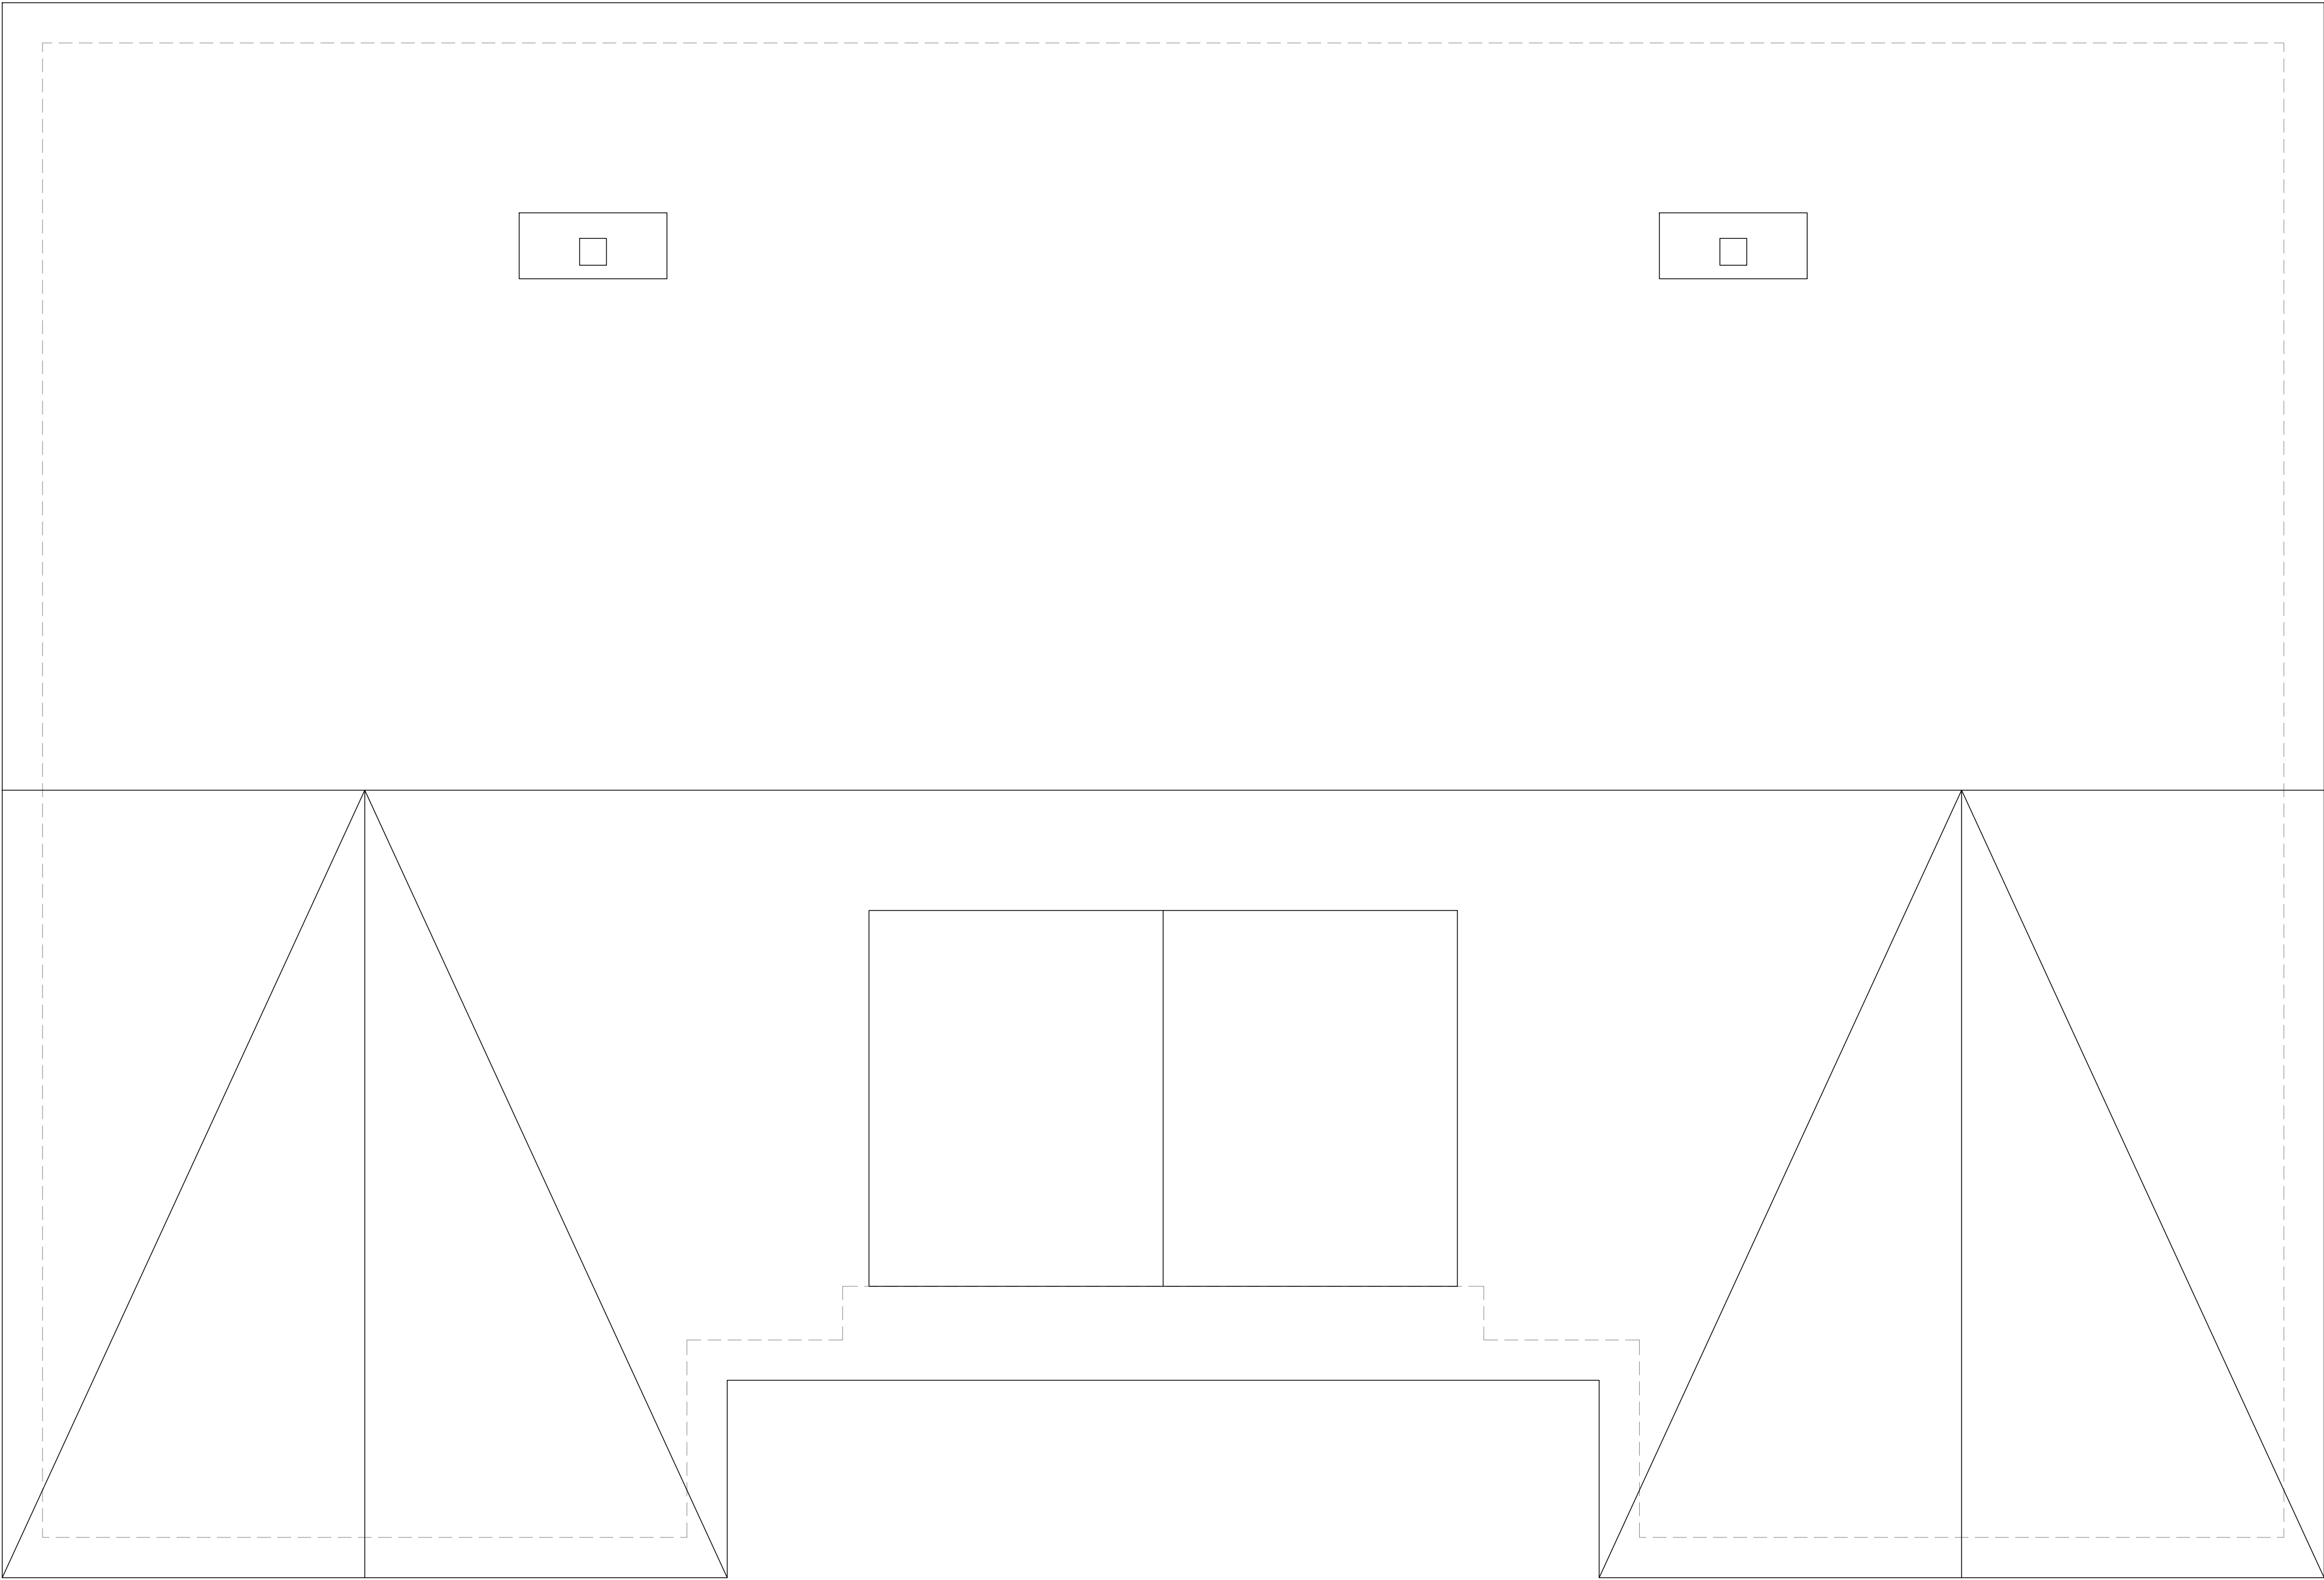

01 ROOF & SITE PLAN
SCALE: 1/4" = 1'-0"




UNIVERSITY OF GEORGIA
TXMI 4300 STUDIO V: RICH
RESIDENTIAL DUPLEX CD SET
MONICA MAZUREK

REVISIONS:
DATE: 11.20.25

SCALE: $\frac{1}{4}" = 1' - 0"$

FIRST FLOOR
FURNITURE PLAN
FF&E-4

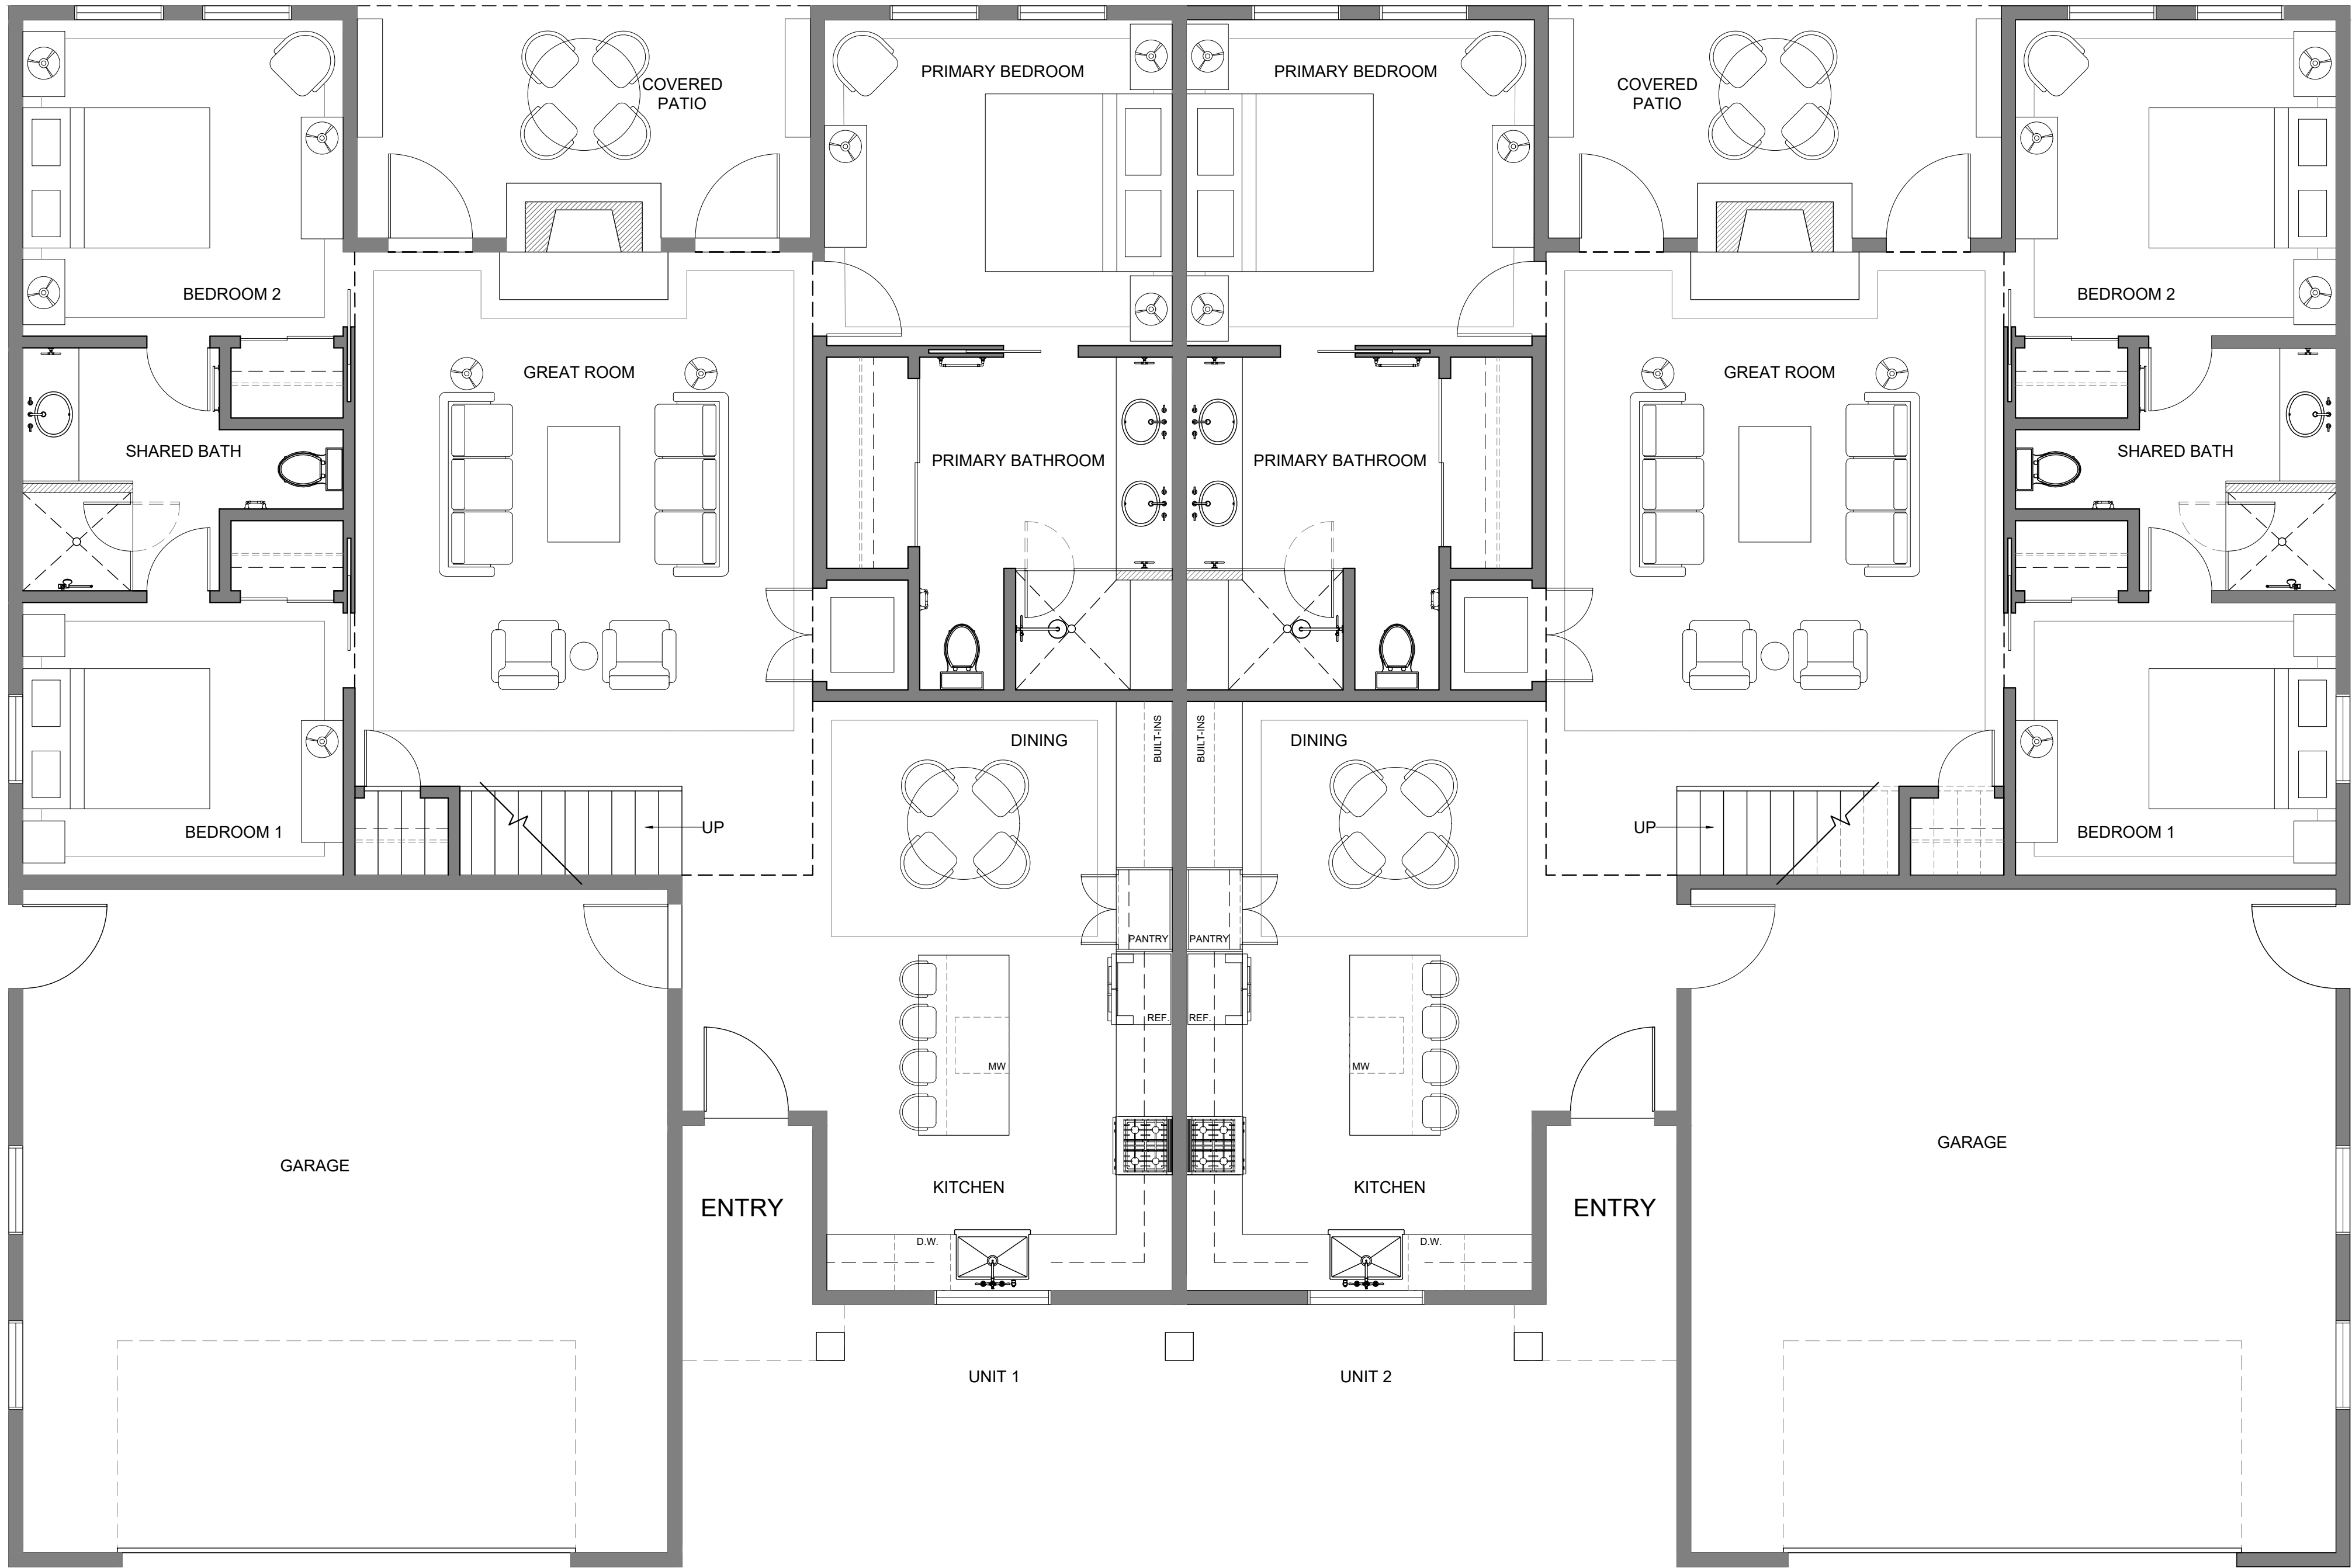

01 FIRST FLR. FURNITURE PLAN
SCALE: $\frac{1}{4}" = 1' - 0"$



UNIVERSITY OF GEORGIA
TXMI 4300 STUDIO V: RICH
RESIDENTIAL DUPLEX CD SET
MONICA MAZUREK

REVISIONS:
DATE: 11.20.25

SCALE: $\frac{1}{4}" = 1' - 0"$

SECOND FLOOR
FURNITURE PLAN
FF&E-5



02 SECOND FLR. FURNITURE PLAN
SCALE: $\frac{1}{4}" = 1' - 0"$




UNIVERSITY OF GEORGIA
TXMI 4300 STUDIO V: RICH
RESIDENTIAL DUPLEX CD SET
MONICA MAZUREK

REVISIONS:
DATE: 11.20.25

SCALE: $\frac{1}{4}" = 1' - 0"$

FIRST FLOOR
ELECTRICAL PLAN
ELEC-6

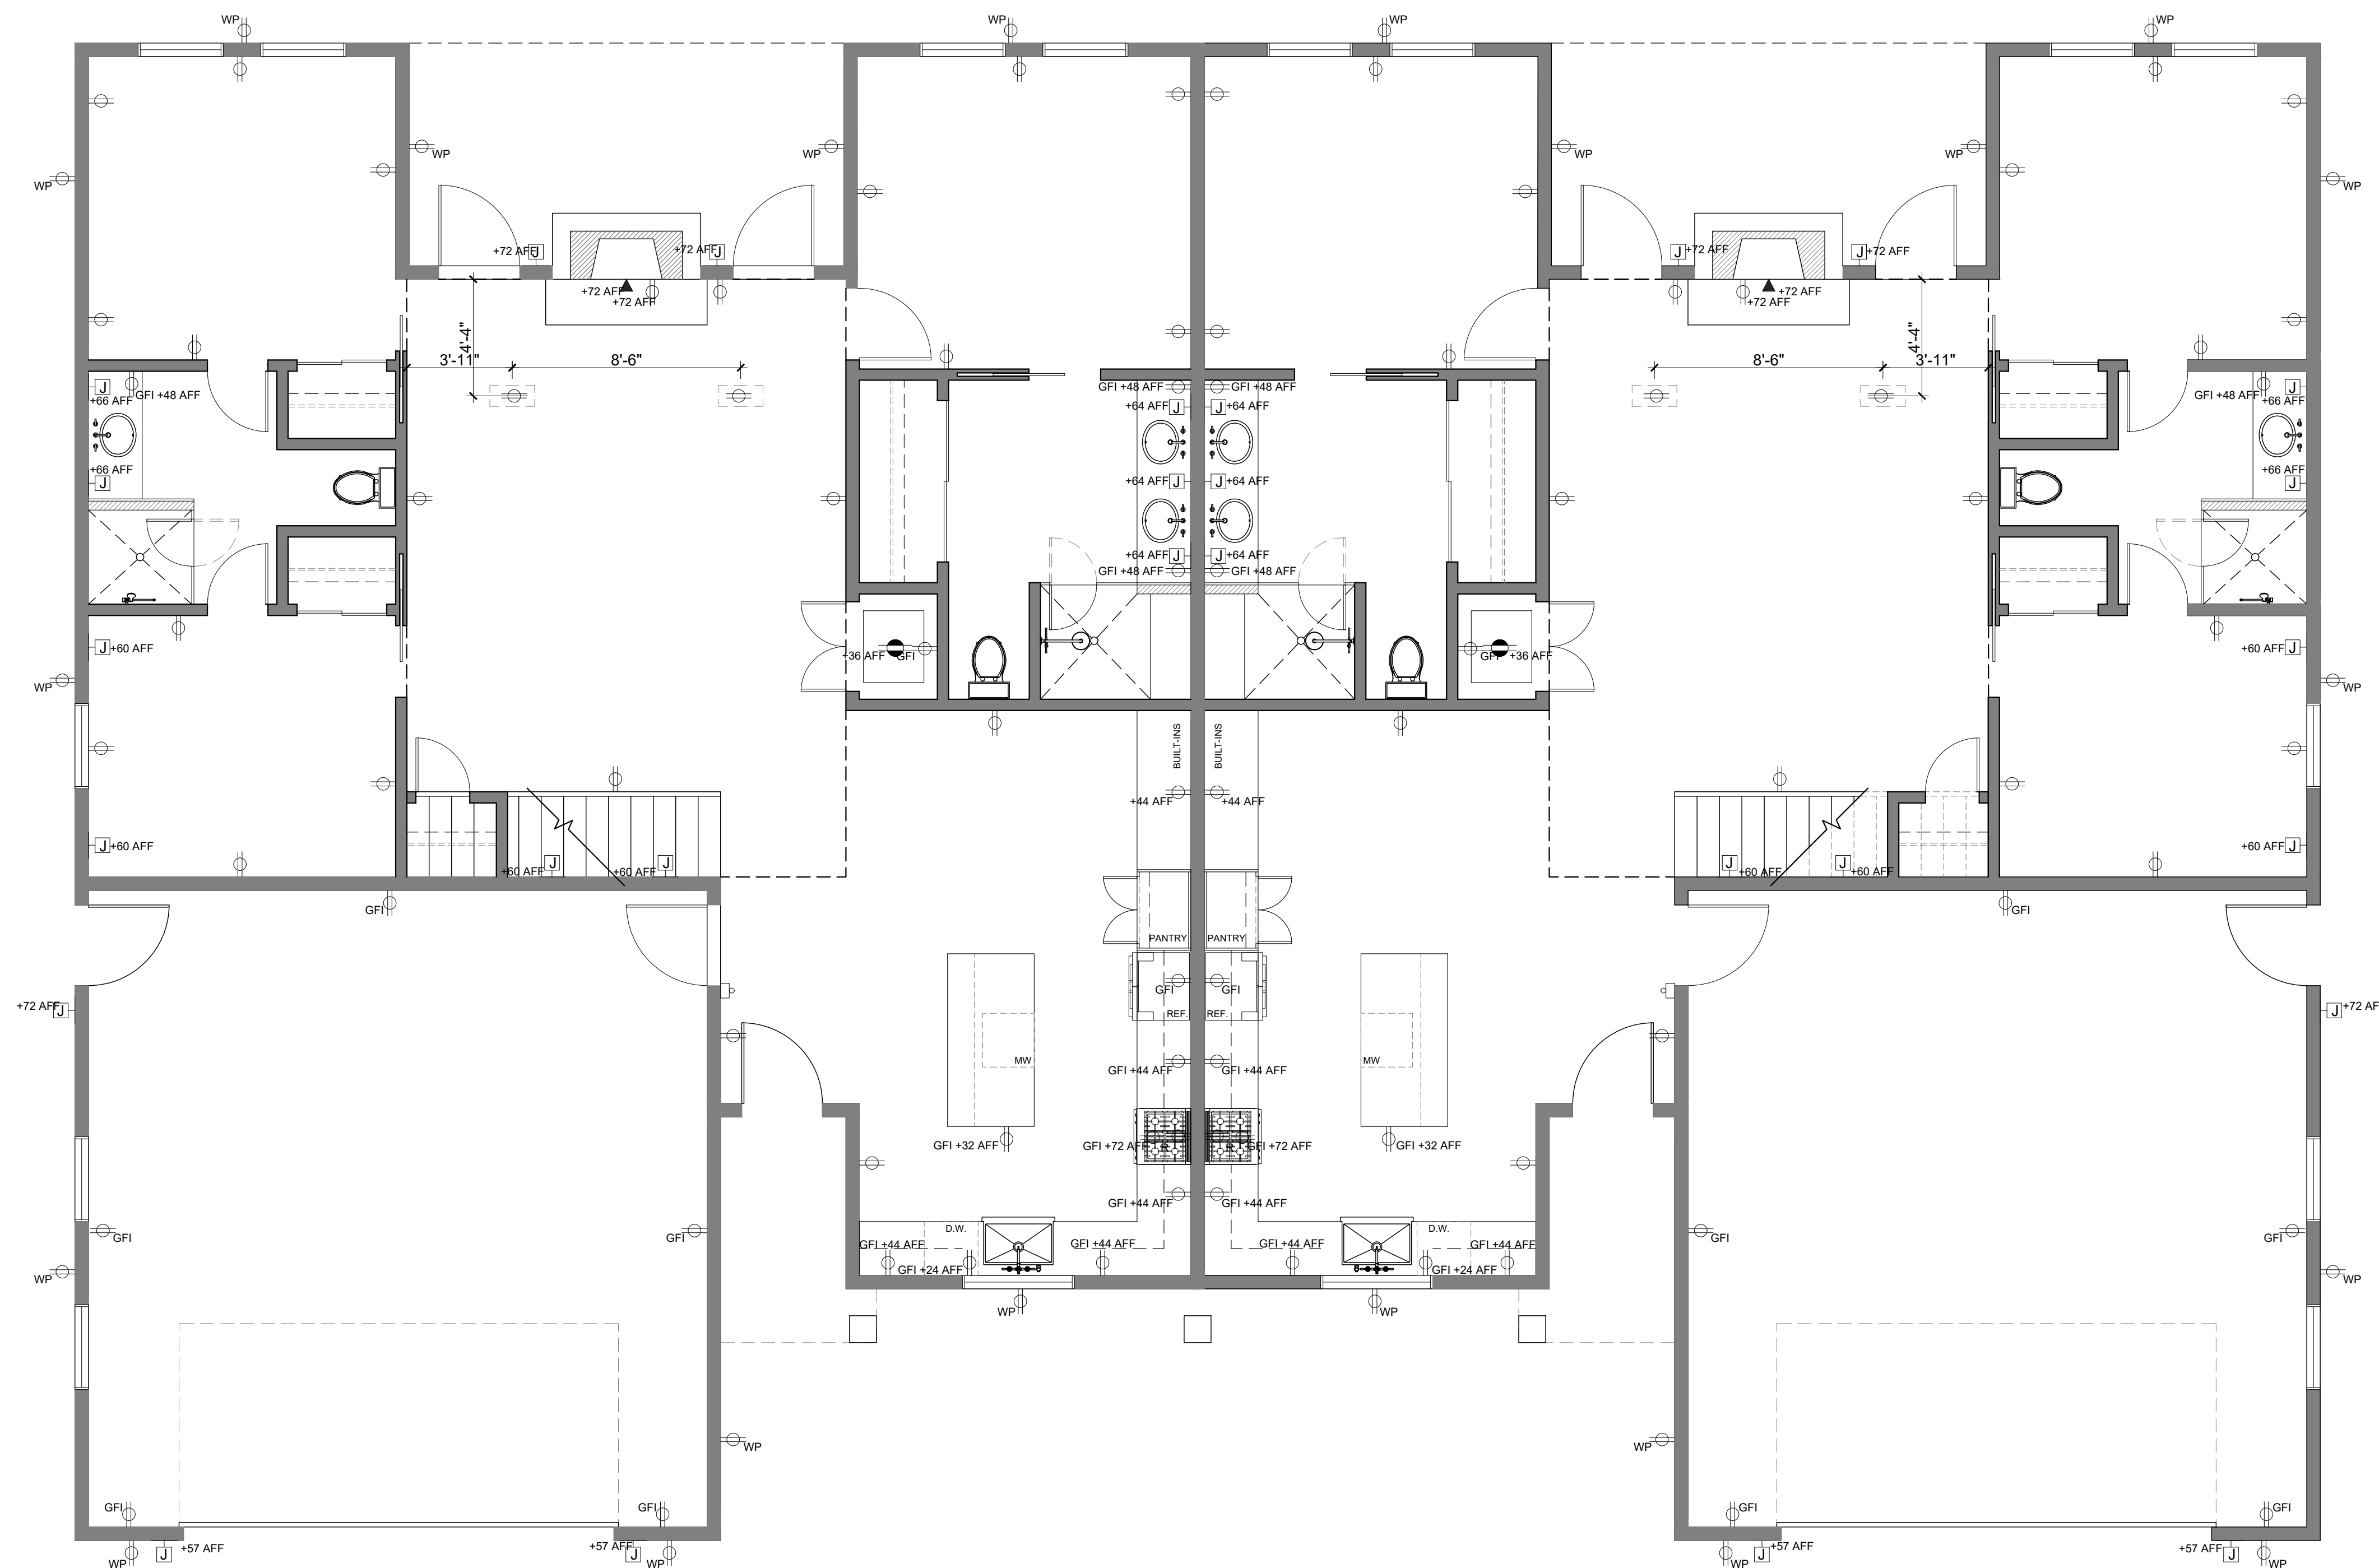

ELECTRICAL LEGEND	
	WALL MOUNTED DUPLEX CONVENIENCE OUTLET
	WALL MOUNTED DUPLEX OUTLET WITH GROUND FAULT INTERRUPTER
	240 DUPLEX CONVENIENCE OUTLET
	SPECIALTY OUTLET (DRYER ONLY)
	RECESSED FLOOR OUTLET
	CABLE OUTLET
	WALL MOUNTED JUNCTION BOX (INDICATE HEIGHT)
	EXTERIOR WATERPROOF DUPLEX OUTLET
	DOOR BELL CHIME (INDOORS ONLY NEAR LIVING ROOM)
NOTE: ALL HEIGHTS INDICATED AS +AFF ON PLAN	




UNIVERSITY OF GEORGIA
TXMI 4300 STUDIO V: RICH
RESIDENTIAL DUPLEX CD SET
MONICA MAZUREK

REVISIONS:
DATE: 11.20.25

SCALE: $\frac{1}{4}" = 1' - 0"$

SECOND FLOOR
ELECTRICAL PLAN
ELEC-7

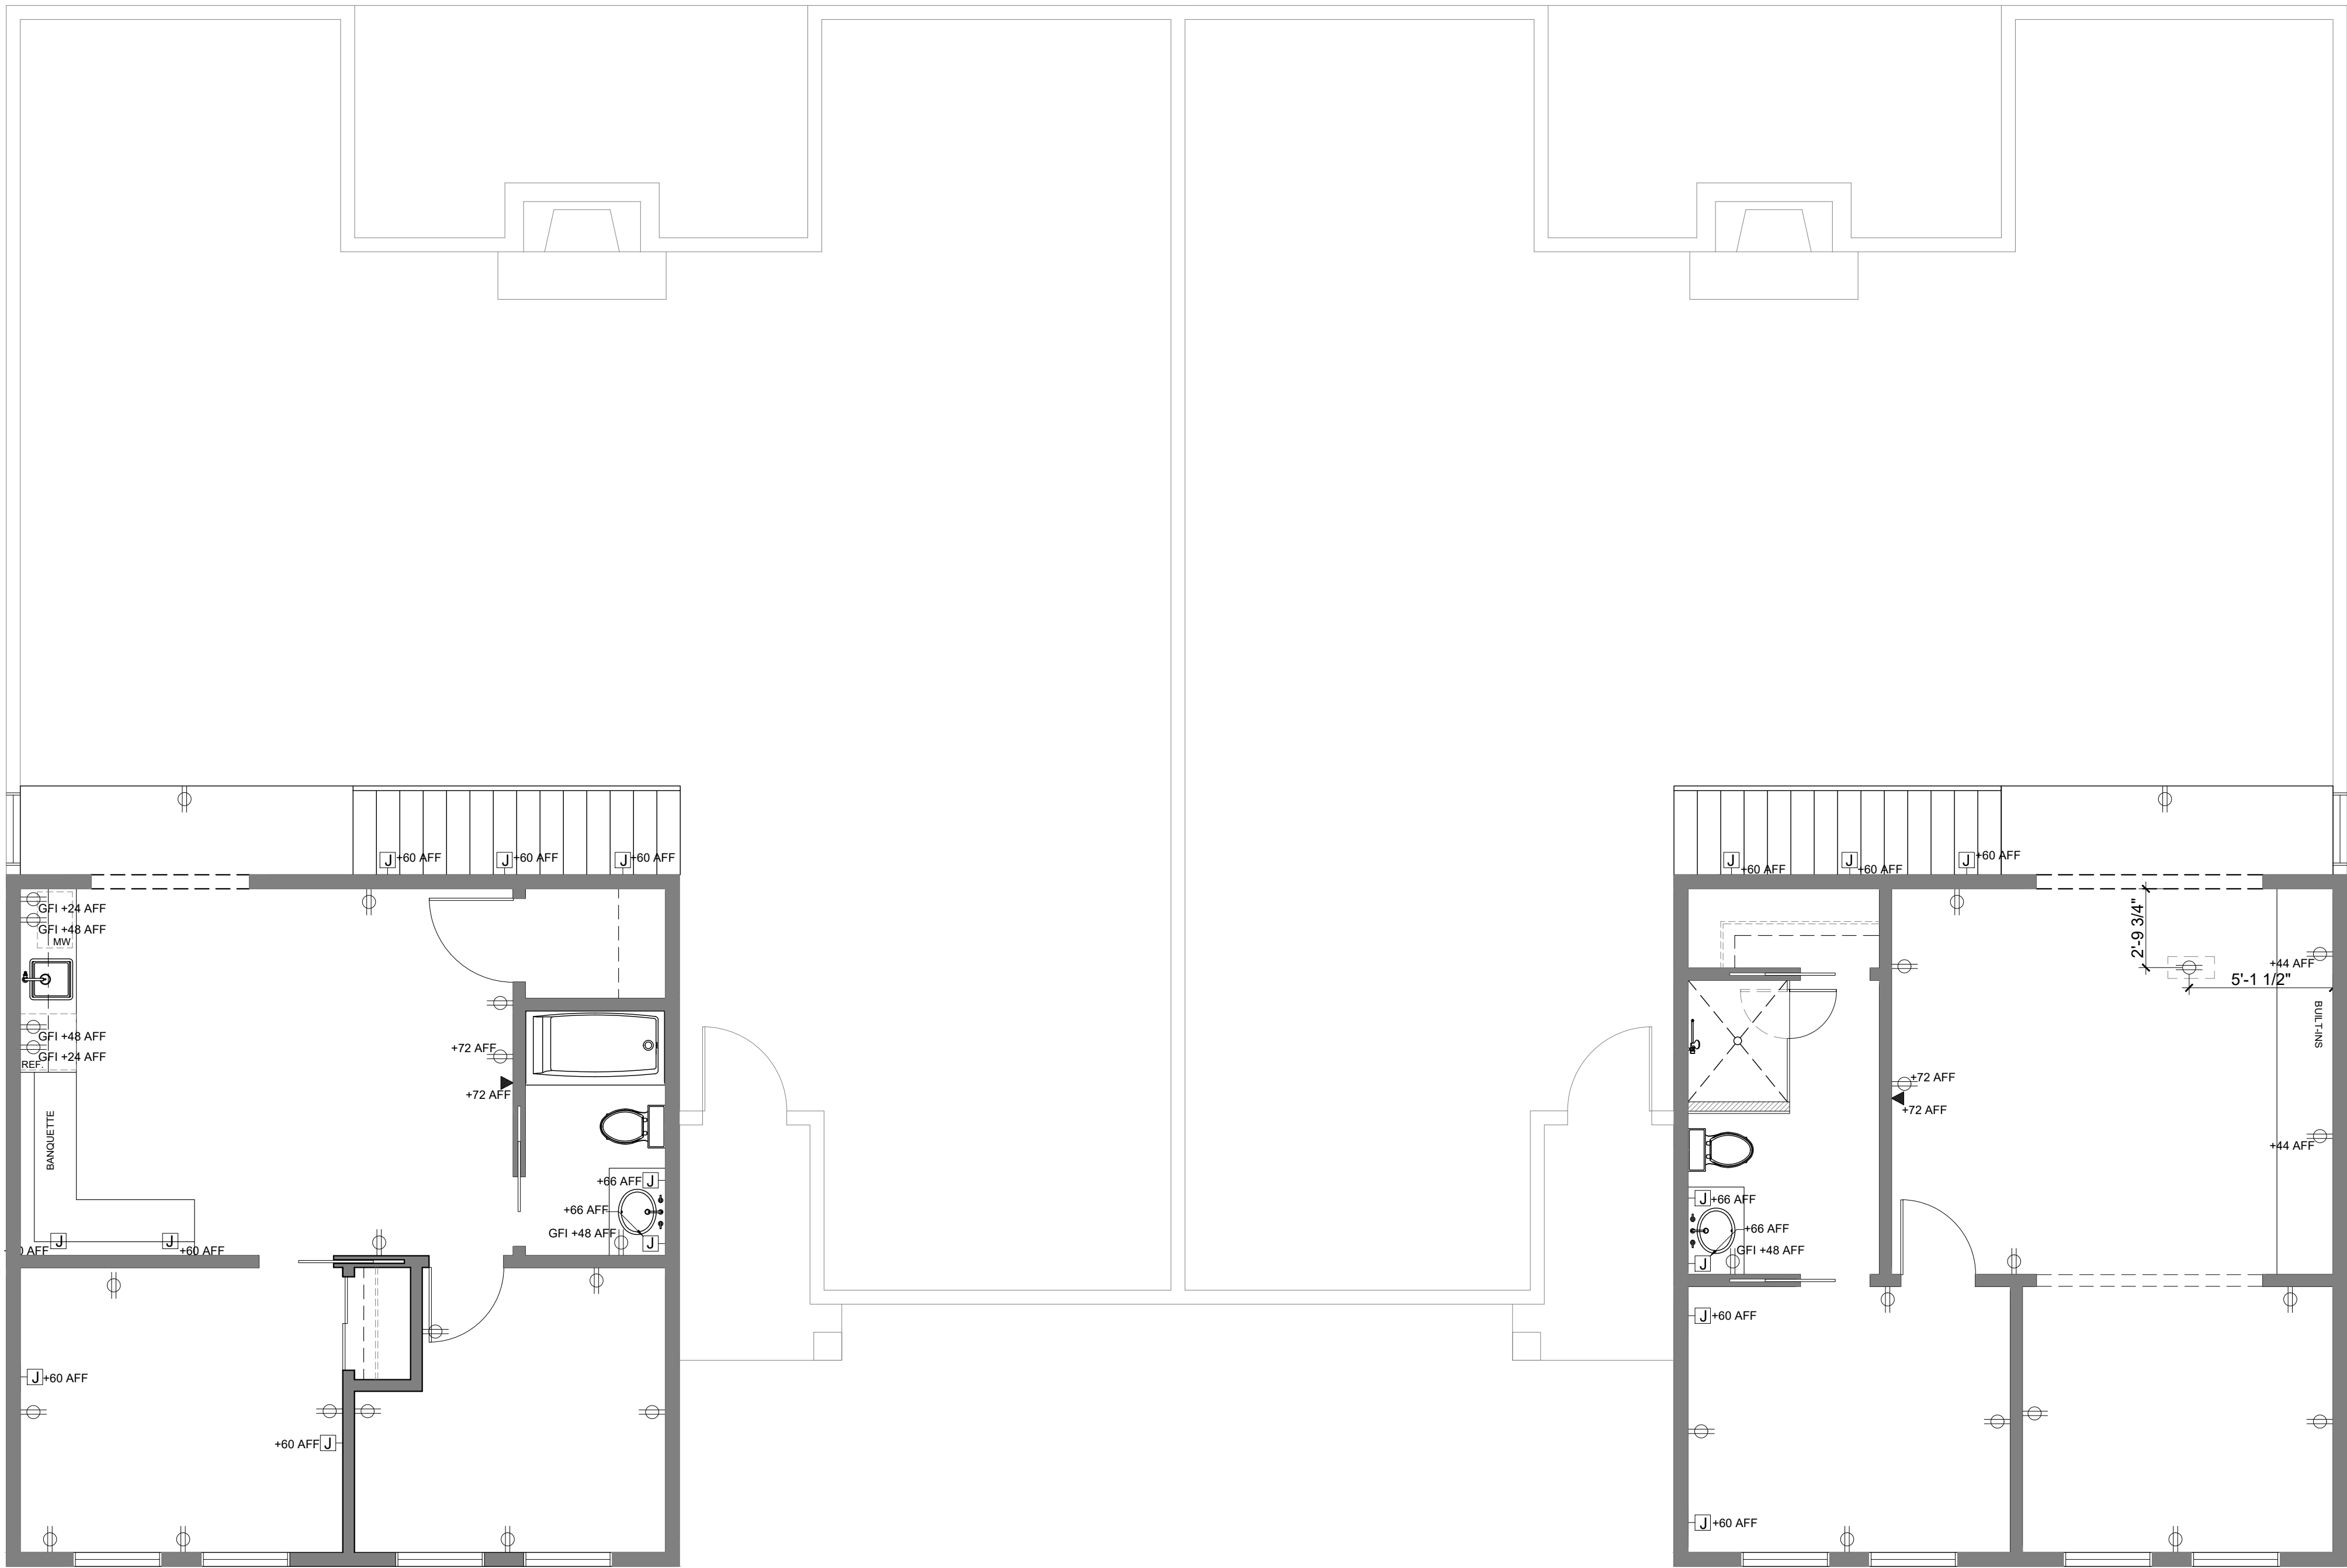

ELECTRICAL LEGEND	
	WALL MOUNTED DUPLEX CONVENIENCE OUTLET
	WALL MOUNTED DUPLEX OUTLET WITH GROUND FAULT INTERRUPTER
	240 DUPLEX CONVENIENCE OUTLET
	SPECIALTY OUTLET (DRYER ONLY)
	RECESSED FLOOR OUTLET
	CABLE OUTLET
	WALL MOUNTED JUNCTION BOX (INDICATE HEIGHT)
	EXTERIOR WATERPROOF DUPLEX OUTLET
	DOOR BELL CHIME (INDOORS ONLY NEAR LIVING ROOM)


NOTE: ALL HEIGHTS INDICATED AS +AFF ON PLAN

02 SECOND FLR. ELECTRICAL PLAN
SCALE: $\frac{1}{4}" = 1' - 0"$



REVISIONS:
DATE: 11.20.25

SCALE: $\frac{1}{4}" = 1' - 0"$

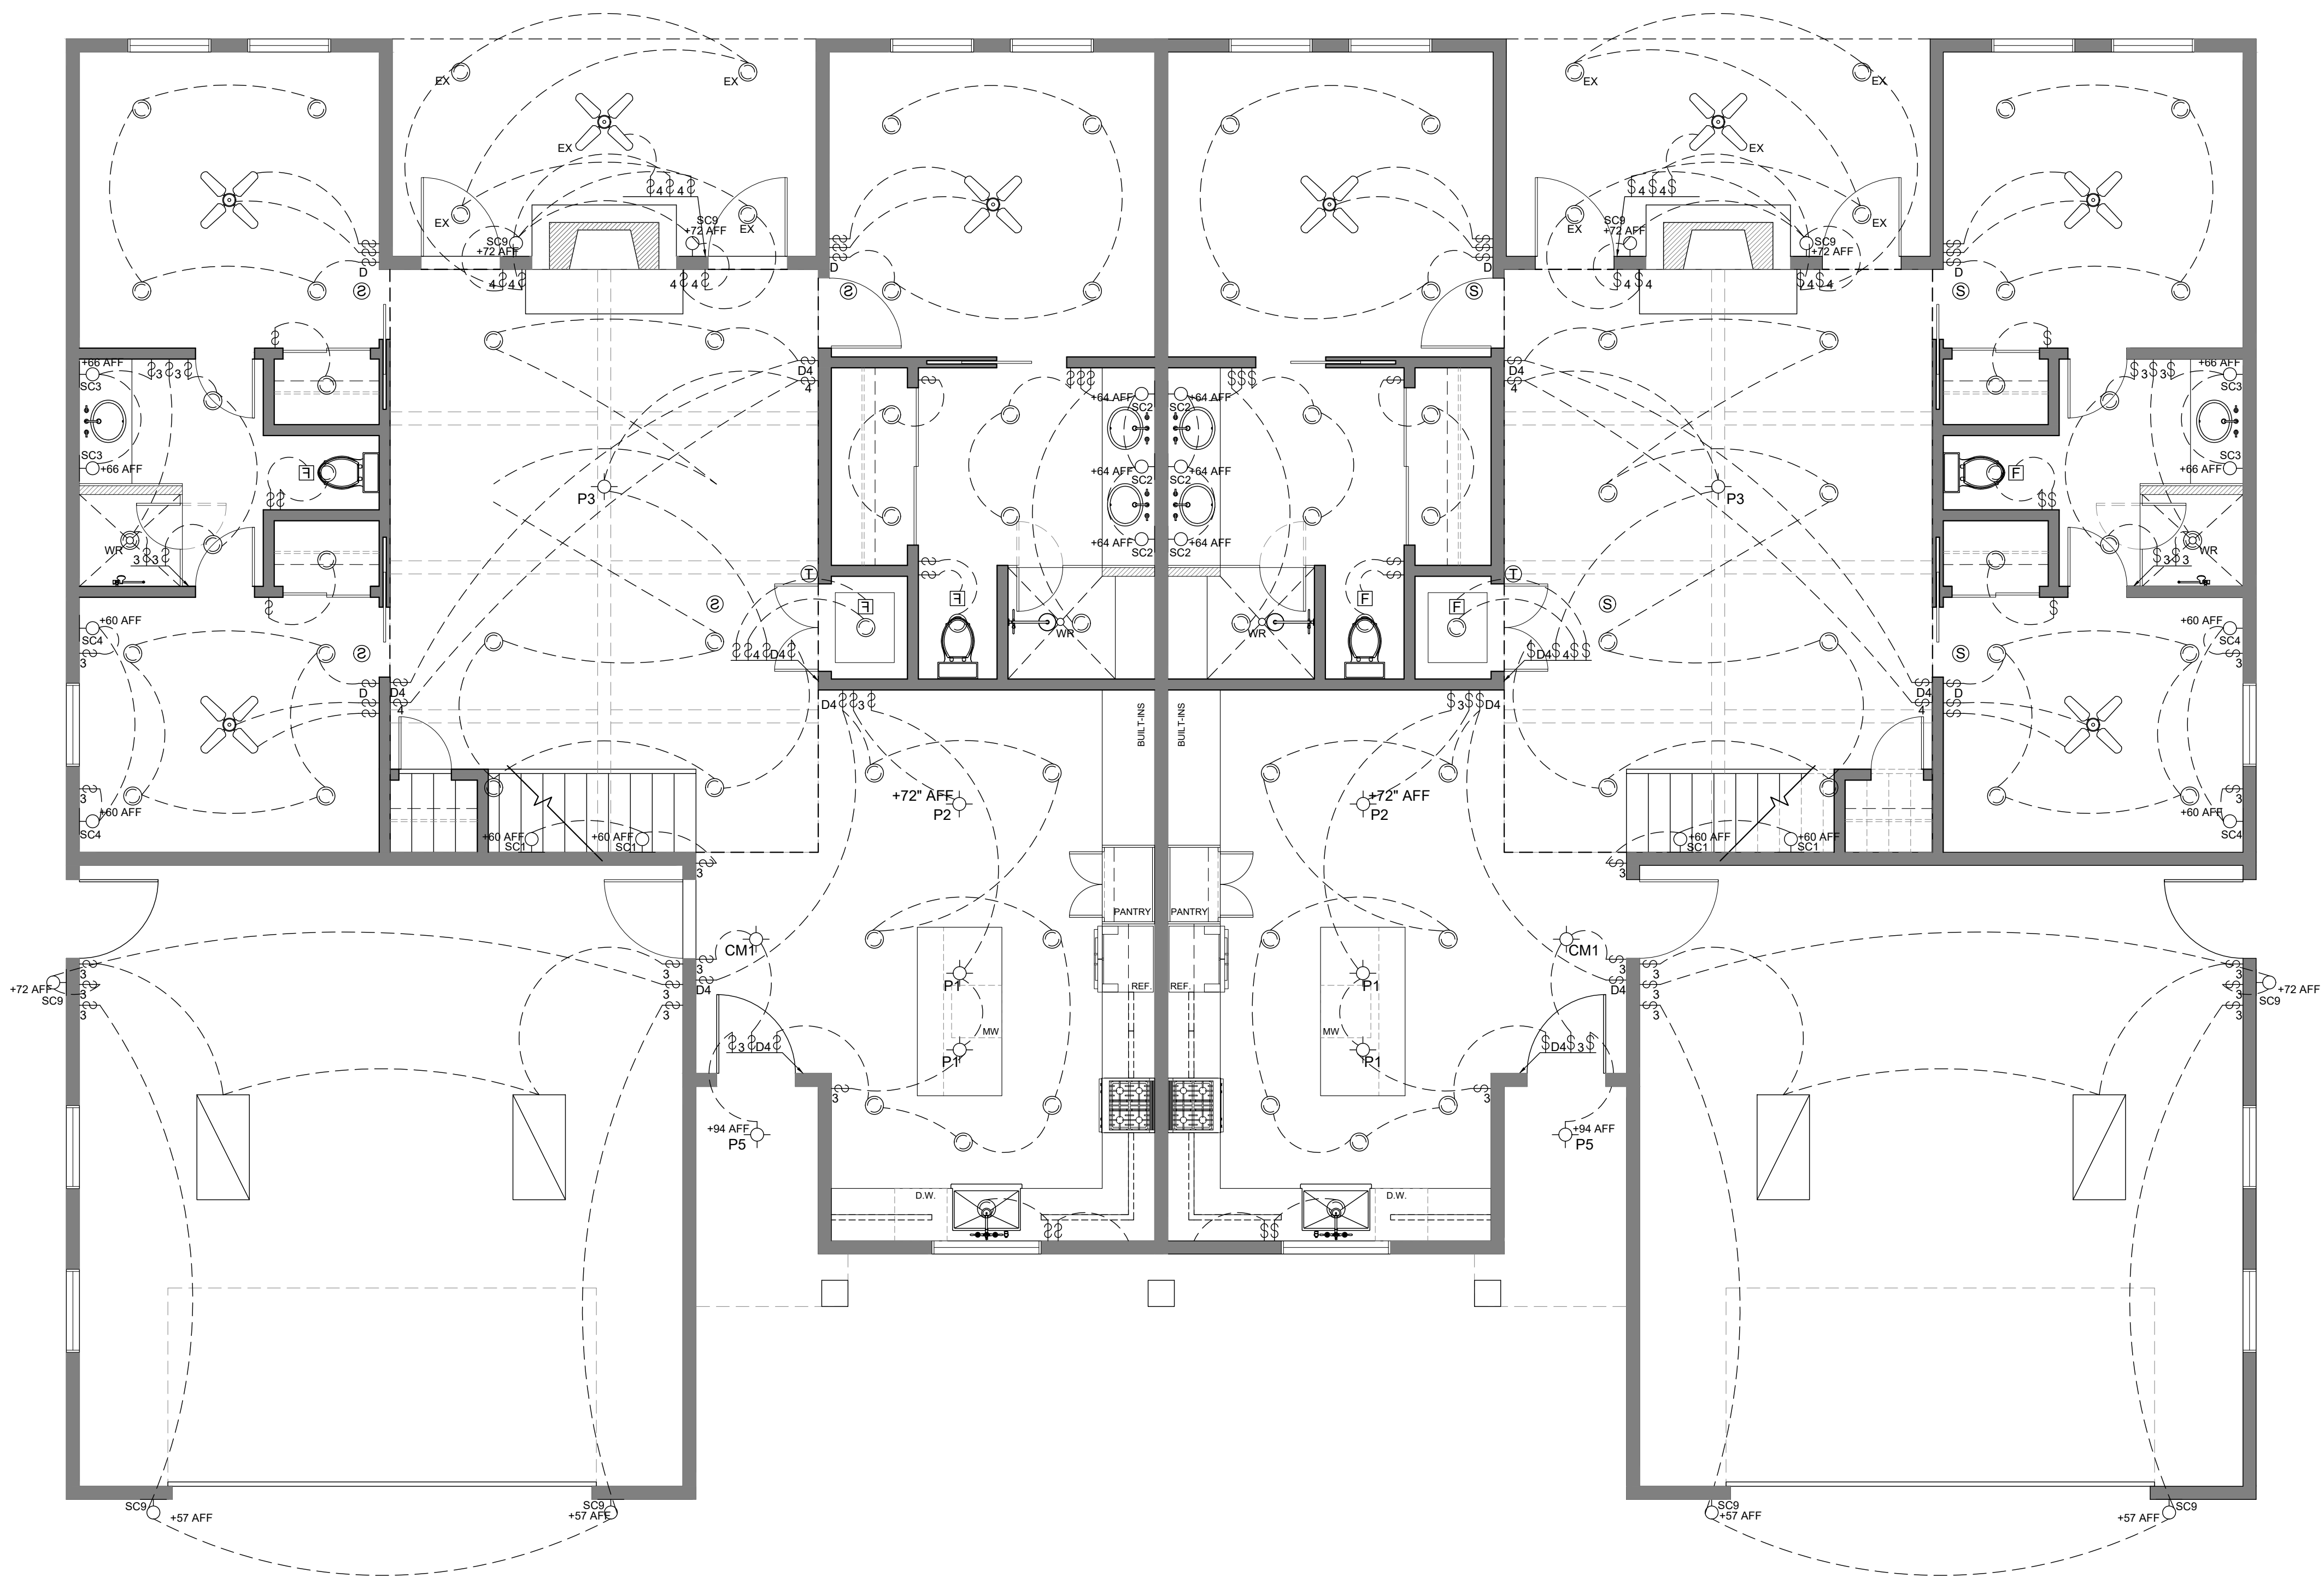

01 FIRST FLR. LIGHTING PLAN
SCALE: $\frac{1}{4}" = 1' - 0"$

LIGHTING LEGEND	
	HIDDEN STRIP LED
	CEILING FLUSH-MOUNTED FIXTURE
	LED PENDANT FIXTURE
	EXHAUST FAN
	WALL SCONCE/WALL MOUNTED LIGHT FIXTURE
	LED DOWNLIGHT - RECESSED
	EXTERIOR RATED LED DOWNLIGHT - RECESSED
	WET RATED LED DOWNLIGHT - RECESSED
	CEILING FAN WITH LIGHT KIT
	EXTERIOR RATED CEILING FAN
	2X4 TROFFER
	STANDARD SINGLE POLE SWITCH
	STANDARD THREE-WAY SWITCH (USE WHEN YOU HAVE 2 SWITCHES AND 1 LIGHT)
	STANDARD FOUR-WAY SWITCH (USE WHEN YOU HAVE 3 SWITCHES AND 1 OR MORE LIGHTS)
	DIMMER SWITCH
	THERMOSTAT
	SMOKE DETECTOR


LIGHTING SCHEDULE					
SYMBOL	MANUFACTURER	MODEL #	LOCATION	QUANTITY	NOTES
	COOPER LIGHTING	HL6RSMF	THROUGHOUT	52	Halo LED 6" Microedge Direct Mount Downlight
	COOPER LIGHTING	H5ICAT	SHOWERS	6	Halo 5" Shower Light Flat Frosted Glass Lens, White Trim
	FERGUSON HOME	FM-05RN-930-BZ	COVERED PATIO	8	WAC Lighting Round 5" Wide LED Indoor / Outdoor Flush Mount Ceiling Fixture / Wall Sconce
	URBAN ELECTRIC	MA-9839HS	KITCHEN	4	Dover Bell Hanging Pendant size small, hewn brass lacquered finish with clear glass, 72 AFF
	URBAN ELECTRIC	UE-2248HR	DINING ROOM	2	Tulle Hanging Pendant, heirloom finish with white linen pleated shade, 72 AFF
	URBAN ELECTRIC	UE-8100HR	GREAT ROOM	2	Campion Hanging Pendant, heirloom finish with antique brass accents, 85 AFF
	URBAN ELECTRIC	MA-2040HR	LOUNGE	1	Disc Semi-Flush Mount, size small in antique brass finish with polished brass lacquered accents, 72 AFF
	VISUAL COMFORT	CHO 5161FR-CG	EXTERIOR	2	Fremont Medium Hanging Lantern
	VISUAL COMFORT	SL 4121HAB-WG	ENTRY	2	Edmond Flush Mount, Hand-Rubbed Antique Brass
	URBAN ELECTRIC	UE-2270HR	KITCHENETTE	1	Hooper Flush Mount tarnished brass finish with bronze accents. Shade in bronze finish with matching interior
	VISUAL COMFORT	TOB 4220GI	MEDIA ROOM 2	1	Enrique Flush Mount, Gilded Iron
	VISUAL COMFORT	3HCKR60HABD	THROUGHOUT	12	Hicks 60" LED Ceiling Fan, Hand Rubbed Antique Brass
	FERGUSON HOME	F753-KA	COVERED PATIO	2	MinkaAire Java 54" 3 Blade Indoor / Outdoor Ceiling Fan with Remote Included
	VISUAL COMFORT	BBL 2036EBO-L	STAIR WELL	6	Refined Rib Sconce, Ebony Resin and Brass, Linen Shade, 60 AFF
	VISUAL COMFORT	TOB 2022HAB-WG	PRIMARY BATH	6	Bryant Glass Sconce, Hand-Rubbed Antique Brass, 64 AFF
	VISUAL COMFORT	TOB2140	SHARED BATH	4	Dresser Short Glass Rod Light, Hand-Rubbed Antique Brass, 60 AFF
	URBAN ELECTRIC	UE-2096WR	BEDROOM 1	4	Agnes Wall Sconce, blackened pewter finish with heirloom accents and a white linen shade, 60 AFF
	URBAN ELECTRIC	MA-1697WR	BEDROOM 3	2	Mel Wall Sconce, bronze finish with a cream silk shade, 60 AFF
	VISUAL COMFORT	TOB22256	UPSTAIRS BATH 1 & 2	4	Katie Small Conical Sconce, Hand-Rubbed Antique Brass, 60 AFF
	URBAN ELECTRIC	MA-1697WR	BEDROOM 4	2	Audley Wall Sconce, found brass finish with UECo. Signature Color Ivy Green accents and shade SH-197E (UECo. Curated Shade Varykino by Decors Barbarea.), 60 AFF
	URBAN ELECTRIC	UE-2122WR	KITCHENETTE	2	Niles Wall Sconce, hewn brass lacquered finish with a moss paper shade, 60 AFF
	VISUAL COMFORT	CHO 2086BZ	EXTERIOR	10	Darlana Small Tall Bracketed Wall Lantern, Bronze, Exterior Rated, 72 AFF
	COOPER LIGHTING	APS-NS232	KITCHEN, KITCHENETTE	1	APS-NS Series, 21 Linear Feet
	FERGUSON HOME	FV-0709VB1	ALL BATHROOMS AND LAUNDRY	8	Panasonic EcoVent 70 - 90 CFM 0.3, 0.7, 1.5 Sone Ceiling Mounted Energy Star Certified Bath Fan
	COOPER LIGHTING	22GR4340D 2	GARAGE	4	Metalux AP -GR --2X4, TM21

NOTE: SCHEDULE AT $\frac{3}{8}"$ SCALE



REVISIONS:
DATE: 11.20.25

SCALE: $\frac{1}{4}" = 1' - 0"$

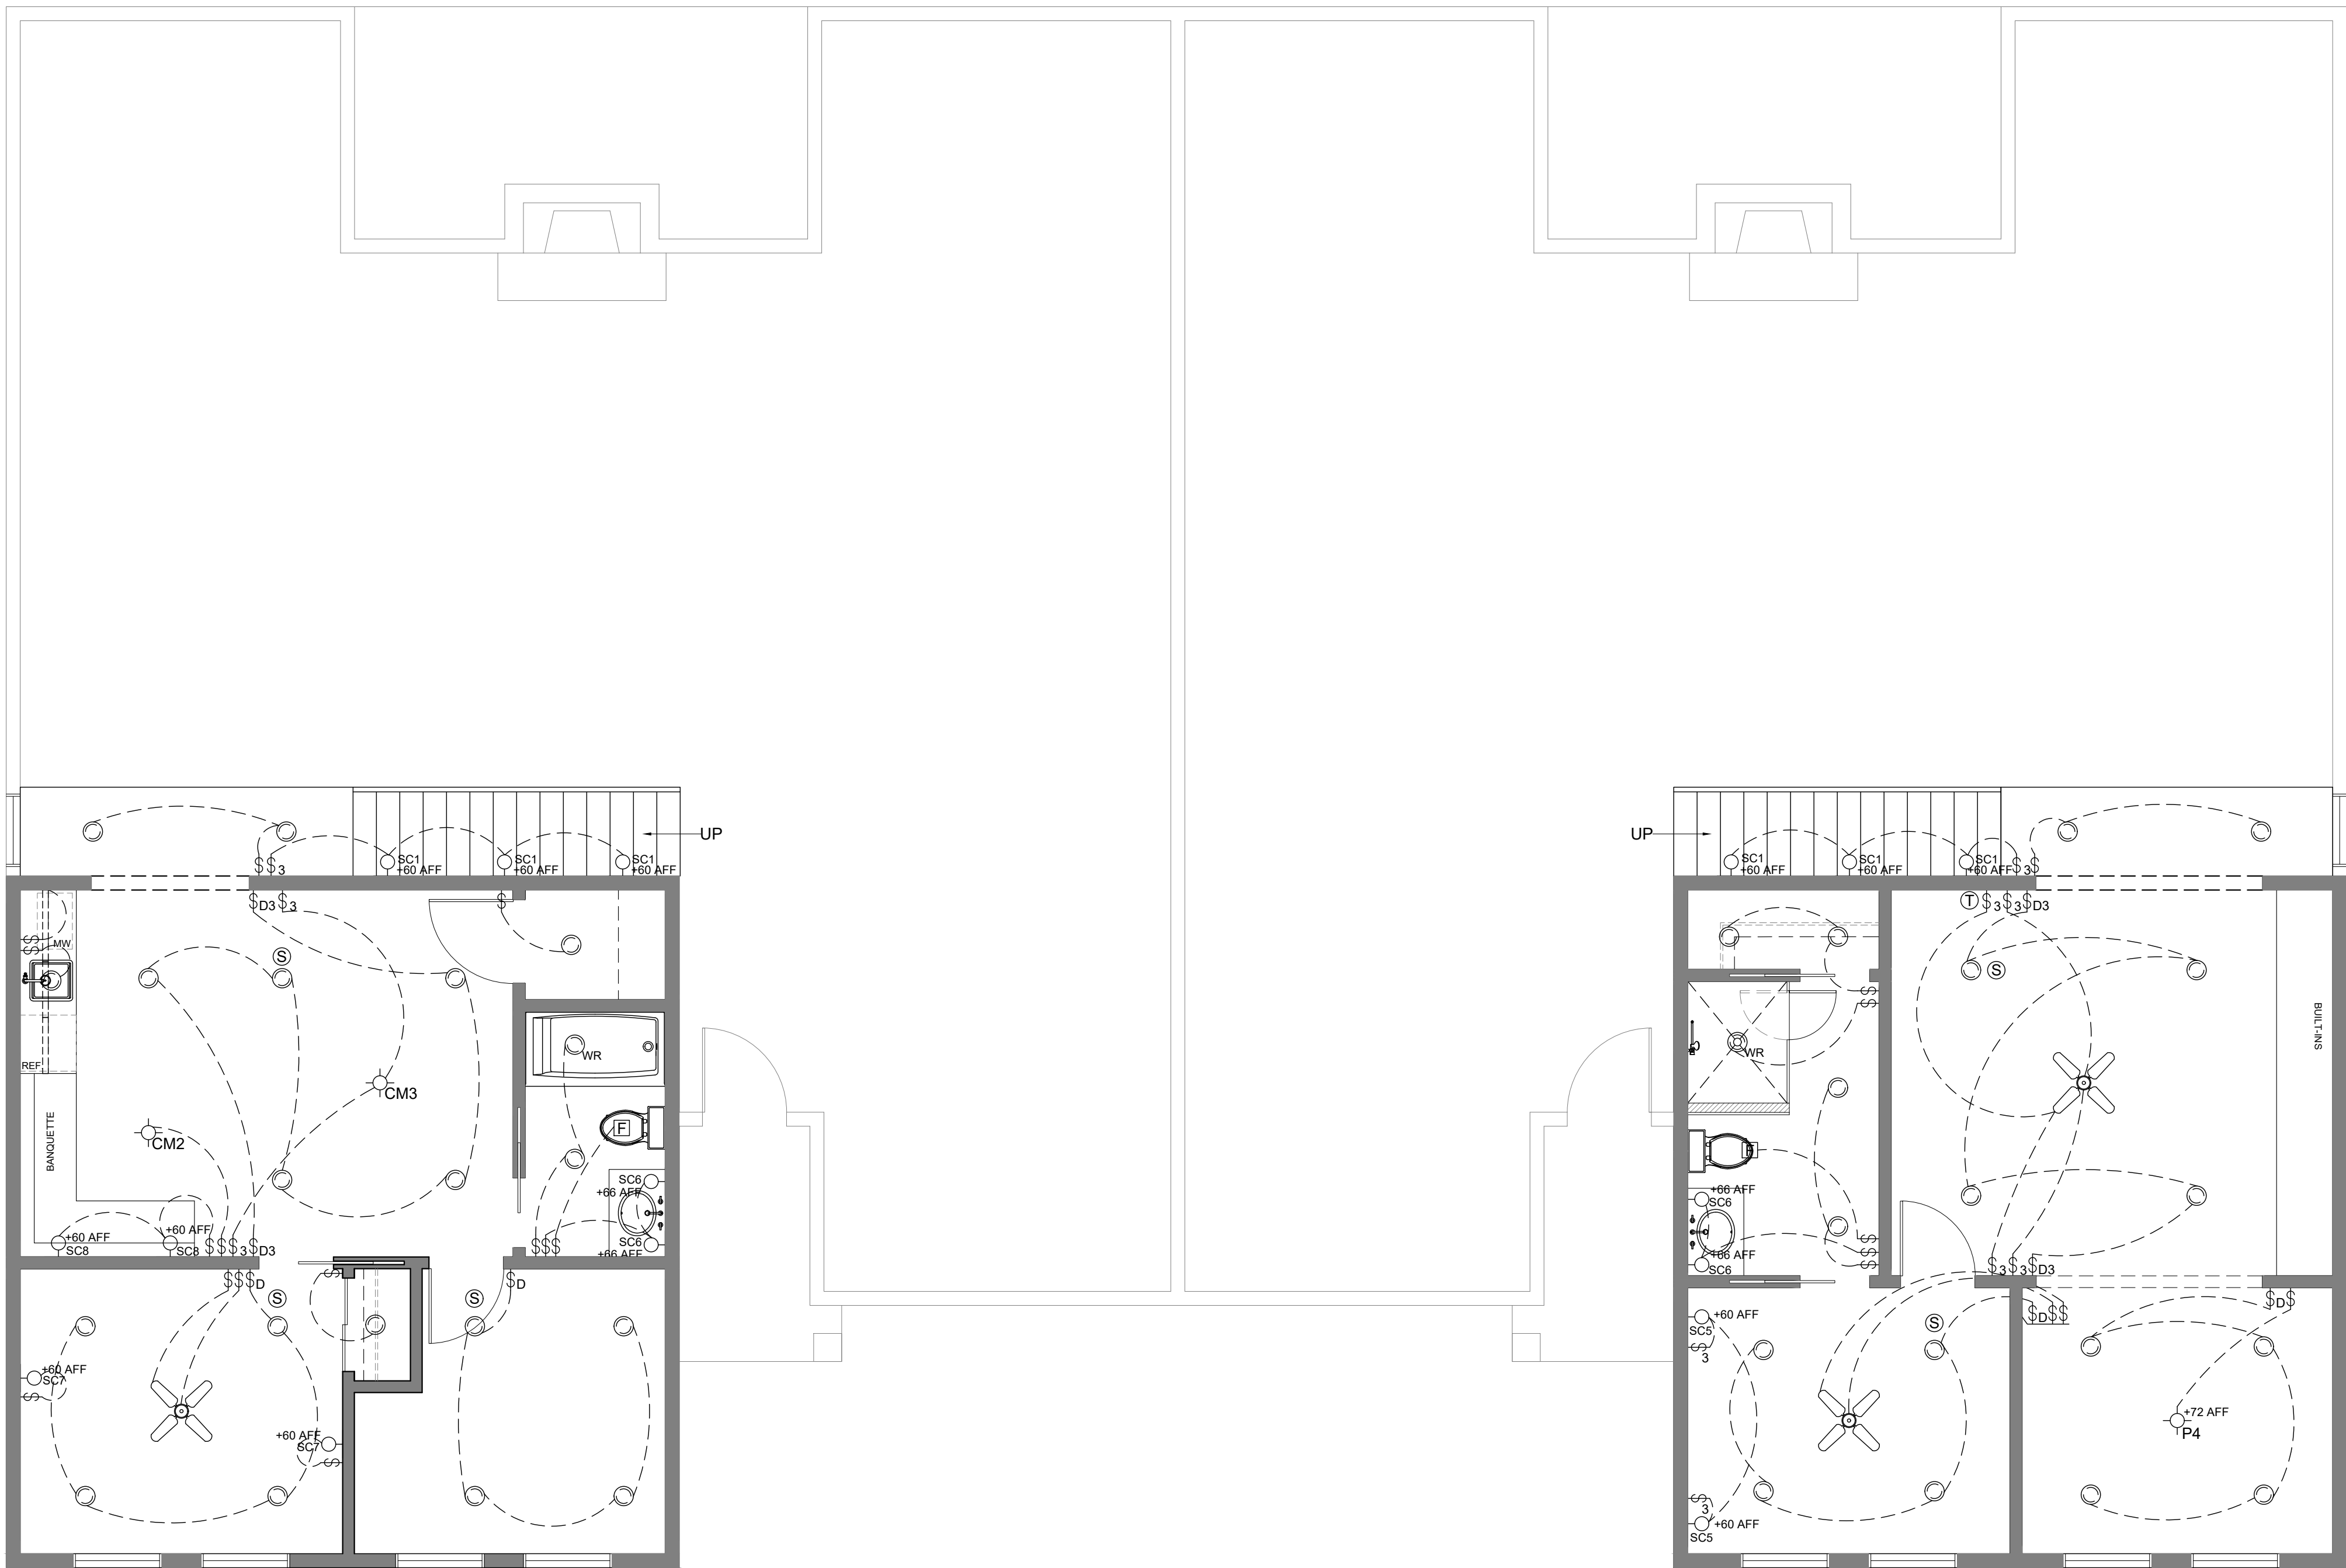

LIGHTING LEGEND	
	HIDDEN STRIP LED
	CEILING FLUSH-MOUNTED FIXTURE
	LED PENDANT FIXTURE
	EXHAUST FAN
	WALL SCONCE/WALL MOUNTED LIGHT FIXTURE
	LED DOWNLIGHT - RECESSED
	EXTERIOR RATED LED DOWNLIGHT - RECESSED
	WET RATED LED DOWNLIGHT - RECESSED
	CEILING FAN WITH LIGHT KIT
	EXTERIOR RATED CEILING FAN
	2X4 TROFFER
	STANDARD SINGLE POLE SWITCH
	STANDARD THREE-WAY SWITCH (USE WHEN YOU HAVE 2 SWITCHES AND 1 LIGHT)
	STANDARD FOUR-WAY SWITCH (USE WHEN YOU HAVE 3 SWITCHES AND 1 OR MORE LIGHTS)
	DIMMER SWITCH
	THERMOSTAT
	SMOKE DETECTOR

LIGHTING SCHEDULE					
SYMBOL	MANUFACTURER	MODEL #	LOCATION	QUANTITY	NOTES
	COOPER LIGHTING	HL6RSMF	THROUGHOUT	52	Halo LED 6" Microedge Direct Mount Downlight
	COOPER LIGHTING	H5ICAT	SHOWERS	6	Halo 5" Shower Light Flat Frosted Glass Lens, White Trim
	FERGUSON HOME	FM-05RN-930-BZ	COVERED PATIO	8	WAC Lighting Round 5" Wide LED Indoor / Outdoor Flush Mount Ceiling Fixture / Wall Sconce
	URBAN ELECTRIC	MA-9839HS	KITCHEN	4	Dover Bell Hanging Pendant, heirloom finish with white linen pleated shade, 72 AFF
	URBAN ELECTRIC	UE-2248HR	DINING ROOM	2	Tulle Hanging Pendant, heirloom finish with white linen pleated shade, 72 AFF
	URBAN ELECTRIC	UE-8100HR	GREAT ROOM	2	Campion Hanging Pendant, heirloom finish with antique brass accents, 85 AFF
	URBAN ELECTRIC	MA-2040HR	LOUNGE	1	Disc Semi-Flush Mount, size small in antique brass finish with polished brass lacquered accents, 72 AFF
	VISUAL COMFORT	CHO 5161FR-CG	EXTERIOR	2	Fremont Medium Hanging Lantern
	VISUAL COMFORT	SL 4121HAB-WG	ENTRY	2	Edmond Flush Mount, Hand-Rubbed Antique Brass
	URBAN ELECTRIC	UE-2270HR	KITCHENETTE	1	Hooper Flush Mount tarnished brass finish with bronze accents. Shade in bronze finish with matching interior
	VISUAL COMFORT	TOB 4220GI	MEDIA ROOM 2	1	Enrique Flush Mount, Gilded Iron
	VISUAL COMFORT	3HCKR60HABD	THROUGHOUT	12	Hicks 60" LED Ceiling Fan, Hand Rubbed Antique Brass
	FERGUSON HOME	F753-KA	COVERED PATIO	2	MinkaAire Java 54" 3 Blade Indoor / Outdoor Ceiling Fan with Remote Included
	VISUAL COMFORT	BBL 2036EBO-L	STAIR WELL	6	Refined Rib Sconce, Ebony Resin and Brass, Linen Shade, 60 AFF
	VISUAL COMFORT	TOB 2022HAB-WG	PRIMARY BATH	6	Bryant Glass Sconce, Hand-Rubbed Antique Brass, 64 AFF
	VISUAL COMFORT	TOB2140	SHARED BATH	4	Dresser Short Glass Rod Light, Hand-Rubbed Antique Brass, 60 AFF
	URBAN ELECTRIC	UE-2096WR	BEDROOM 1	4	Agnes Wall Sconce, blackened pewter finish with heirloom accents and a white linen shade, 60 AFF
	URBAN ELECTRIC	MA-1697WR	BEDROOM 3	2	Mel Wall Sconce, bronze finish with a cream silk shade, 60 AFF
	VISUAL COMFORT	TOB22256	UPSTAIRS BATH 1 & 2	4	Katie Small Conical Sconce, Hand-Rubbed Antique Brass, 60 AFF
	URBAN ELECTRIC	MA-1697WR	BEDROOM 4	2	Audley Wall Sconce, found brass finish with UECOs. Signature Color Ivy Green accents and shade SH-197E (UECO. Curated Shade Varykino by Decors Barbares.), 60 AFF
	URBAN ELECTRIC	UE-2122WR	KITCHENETTE	2	Niles Wall Sconce, hewn brass lacquered finish with a moss paper shade, 60 AFF
	VISUAL COMFORT	CHO 2086BZ	EXTERIOR	10	Darfana Small Tall Bracketed Wall Lantern, Bronze, Exterior Rated, 72 AFF
	COOPER LIGHTING	APS-NS232	KITCHEN, KITCHENETTE	1	APS-NS Series, 21 Linear Feet
	FERGUSON HOME	FV-0709VB1	ALL BATHROOMS AND LAUNDRY	8	Panasonic EcoVent 70 - 90 CFM 0.3, 0.7, 1.5 Sone Ceiling Mounted Energy Star Certified Bath Fan
	COOPER LIGHTING	22GR4340D 2	GARAGE	4	Metalux AP -GR -2X4, TM21

 
NOTE: SCHEDULE AT $\frac{3}{8}"$ SCALE



SCALE: $\frac{1}{4}" = 1' - 0"$

FIN-10

FIN-10



LOCATION: ALL BATHROOMS



REVISIONS:
DATE: 11.20.25

SCALE: 1/4" = 1' - 0"

FINISH PLAN NOTES FOR DUPLEX, RESIDENCE

- CONTRACTOR TO FIELD VERIFY ALL EXISTING CONDITIONS PRIOR TO PRICING. ALL CARPET SEAMS TO BE CENTERED IN DOORWAY IN CLOSED POSITION.
- PROVIDE AND INSTALL APPROPRIATE TRANSITION STRIP AT MATERIAL TRANSITIONS.
- ALL MATERIAL QUANTITIES ARE 'ACTUAL' BASED ON MEASUREMENTS WITHIN AUTOCAD.

FLOOR COVERING

F1 WOOD: FINLEY LOCKING WHITE OAK
TYPE: WIRE-BRUSHED ENGINEERED HARDWOOD
MFG: FLOOR & DECOR
SKU: 101138380
COLOR: NATURAL
NOTE: THROUGHOUT U.N.O
QTY: TBD

F2 TILE: CRAFTSMAN CERAMIC GLAZE TILE
MFG: PRATT AND LARSON
SIZE: 4" X 4"
COLOR: C27
VARIATION: V2
GROUT: MAIPEI
COLOR: 108 BAMBOO
NOTE: GROUT LINES 1/2"
LOCATION: PRIMARY BATHROOM ONLY.
SEE DETAIL 01/FIN-10
QTY: TBD

F3 TILE: CRAFTSMAN CERAMIC GLAZE TILE
MFG: PRATT AND LARSON
SIZE: 4" X 4"
COLOR: C54
VARIATION: V2
GROUT: MAIPEI
COLOR: 108 BAMBOO
NOTE: GROUT LINES 1/2"
LOCATION: PRIMARY BATHROOM ONLY.
SEE DETAIL 01/FIN-10
QTY: TBD

F4 TILE: CRAFTSMAN CERAMIC GLAZE TILE
MFG: PRATT AND LARSON
SIZE: 4" X 4"
COLOR: C25
VARIATION: V2
GROUT: MAIPEI
COLOR: 108 BAMBOO
NOTE: GROUT LINES 1/2"
LOCATION: PRIMARY BATH (SEE DETAIL 01/FIN-10).
SHARED BATH, UPSTAIRS BATHROOMS 1&2
QTY: TBD

F5 TILE: CARRARA VENATO MARBLE 12X12"
HONED FLOOR AND WALL TILE
MFG: THE BUILDER DEPOT
ITEM NO: CVH-12X12-TILE
SIZE: 12" X 12"
GROUT: MAIPEI
COLOR: 38 AVALANCHE
NOTE: GROUT LINES 1/2"
LOCATION: PRIMARY BATHROOM ONLY.
SEE DETAIL 01/FIN-10
QTY: TBD

BASE

B1 WOOD
MFG: WINDSOR ONE
SKU: WOCM003
SIZE: 3/4" X 7-1/4"
TYPE: BASE MOLDING
FINISH: UNFINISHED, ST1
NOTE: USE THROUGHOUT U.N.O.

TRIM

TR1 WOOD
MFG: WINDSOR ONE
SKU: WOCM005
SIZE: 3/4" X 4-9/16"
TYPE: GROWN MOLDING
FINISH: UNFINISHED, ST1
NOTE: USE THROUGHOUT U.N.O.

TR2 WOOD
MFG: WINDSOR ONE
SKU: WOCM003
SIZE: 3/4" X 4-1/4"
TYPE: DOOR & WINDOW CASING
FINISH: UNFINISHED, ST1
NOTE: USE THROUGHOUT U.N.O.

TR3 WOOD
MFG: WINDSOR ONE
SKU: WOHC001
SIZE: 1-5/16" X 2-1/4"
TYPE: DOOR & WINDOW HEADER CAP
FINISH: UNFINISHED, ST1
NOTE: USE THROUGHOUT U.N.O.

TR4 WOOD
MFG: WINDSOR ONE
SKU: 1X5 S4SSE
SIZE: 3/4" X 4-1/2"
TYPE: DOOR & WINDOW HEADER FRIEZE
FINISH: UNFINISHED, ST1
NOTE: USE THROUGHOUT U.N.O.

TR5 WOOD
MFG: WINDSOR ONE
SKU: WOPB001
SIZE: 1-3/8" X 8"
TYPE: DOOR PLINTH
FINISH: UNFINISHED, ST1
NOTE: USE THROUGHOUT U.N.O.

TR6 WOOD
MFG: WINDSOR ONE
SKU: WOV5002
SIZE: 4-5/8" X 4-1/4"
TYPE: WINDOW SILL
FINISH: UNFINISHED, ST1
NOTE: USE THROUGHOUT U.N.O.

TR6 WOOD
MFG: WINDSOR ONE
SKU: WOV5002
SIZE: 4-5/8" X 4-1/4"
TYPE: WINDOW SILL
FINISH: UNFINISHED, ST1
NOTE: USE THROUGHOUT U.N.O.

MANTLE TRIM

MT1 WOOD
MFG: WINDSOR ONE
SKU: 1X5 S4SSE
SIZE: 3/4" X 4-1/2"
FINISH: UNFINISHED, ST1
NOTE: SEE FIREPLACE ELEVATION

MT2 WOOD
MFG: WINDSOR ONE
SKU: WOCM005
SIZE: 3/4" X 4-9/16"
FINISH: UNFINISHED, ST1
NOTE: SEE FIREPLACE ELEVATION

MT3 WOOD
MFG: WINDSOR ONE
SKU: WOST001
SIZE: 7/16" X 1-1/16"
FINISH: UNFINISHED, ST1
NOTE: SEE FIREPLACE ELEVATION

PAINT/STAIN GRADE

ST1 STAIN
MFG: MINWAX
TYPE: MINWAX POLYSHADES
FINISH: SATIN
COLOR: MW 273 ESPRESSO
NOTE: ALL DOORS, TRIM, & BASE

WALL FINISHES

W1 PAINT
MFG: BENJAMIN MOORE
TYPE: REGAL SELECT WATERBORNE
COLLECTION: OFF WHITE COLLECTION
FINISH: EGGSHELL
COLOR: WHITE DOVE OC-17
PRODUCT LINE CODE: 0549
NOTE: USE THROUGHOUT U.N.O.

WC1 WALLCOVERING
MFG: MORRIS & CO.
PATTERN: CHRYSANTHEMUM TOILE
WALLPAPER
COLOR: EGGSHELL/GOLD
PRODUCT REF: DM0VCH104
NOTE: DINING ROOM ONLY

WC2 WALLCOVERING
MFG: YORK WALLCOVERINGS
PATTERN: FLUME DYNASTY
COLOR: TAUPE/MULTI
SKU: AC9104
NOTE: STAIR HALL ONLY

WT-1 WALL TILE
MFG: MOSAIC TILE
TYPE: DIAMOND & CROSS | PINNACLE
HEXAGON PATTERNS
SHEET SIZE: .85 SQFT (11.75" X 10.25")
COLOR: CALFSKIN ON PARCHEMENT
GROUT: MAIPEI
COLOR: 108 BAMBOO
NOTE: GROUT LINES 1/2", PRIMARY BATHROOM SHOWER NICHE

WT-2 WALL TILE
MFG: MOSAIC TILE
TYPE: DIAMOND & CROSS | PINNACLE
HEXAGON PATTERNS
SHEET SIZE: .85 SQFT (11.75" X 10.25")
COLOR: CALFSKIN ON PARCHEMENT
GROUT: MAIPEI
COLOR: 108 BAMBOO
NOTE: GROUT LINES 1/2", PRIMARY BATHROOM SHOWER NICHE

WT-3 WALL TILE
TILE: CRAFTSMAN CERAMIC GLAZE TILE
MFG: PRATT AND LARSON
SIZE: 4" X 4"
COLOR: C54
VARIATION: V2
GROUT: MAIPEI
COLOR: 108 BAMBOO
NOTE: GROUT LINES 1/2"
LOCATION: PRIMARY BATHROOM SHOWER ONLY

WT-4 WALL TILE
TILE: CRAFTSMAN CERAMIC GLAZE TILE
MFG: PRATT AND LARSON
SIZE: 4" X 4"
COLOR: C27
VARIATION: V2
GROUT: MAIPEI
COLOR: 108 BAMBOO
NOTE: GROUT LINES 1/2"
LOCATION: SHARED BATH, UPSTAIRS BATHROOMS 1&2

CEILING
C1 GYPSUM WALLBOARD
SIZE: 5" THICK
NOTE: USE THROUGHOUT U.N.O., PT-1

C2 WOOD CEILING PANELS
MFG: ARCHITECTURAL DEPOT
TYPE: SKINIES WOOD PANEL
MATERIAL: WHITE OAK
FINISH: UNFINISHED, ST1
SIZE: 5 1/2"W X 11 3/8"D X 47 1/2"L
ITEM NUMBER: TL00960
LOCATION: LIVING ROOM VAULTED CEILING ONLY

C3 WOOD BEAMS
MFG: ARCHITECTURAL DEPOT
TYPE: TRUEWOOD REAL WOOD SMOOTH, 3-SIDED (J-BEAM), STAIN GRADE KNOTTY ALDER
MATERIAL: WHITE OAK
FINISH: UNFINISHED, ST1
ITEM NUMBER: BMWMS300400X0400X120WOUF
LOCATION: LIVING ROOM VAULTED CEILING & KITCHEN HEADER

PT-1 CEILING PAINT

MFG: BENJAMIN MOORE
TYPE: WATERBORNE CEILING PAINT
FINISH: ULTRA FLAT
COLOR: SIMPLY WHITE, 2143-70
PRODUCT LINE CODE: 0508
NOTE: THROUGHOUT ENTIRE HOUSE

SOLID SURFACES

SS1 STONE SLAB
MFG: WILSON ART ENGINEERED SURFACES
MATERIAL: QUARTZ
COLOR: GLENCOE
PRODUCT NUMBER: Q4077
LOCATION: KITCHEN, KITCHENETTE, AND FIREPLACE ONLY
NOTE: COUNTERTOP, BACK SPLASH, AND FIREPLACE SURROUND

SS2 STONE SLAB
MFG: WILSON ART ENGINEERED SURFACES
MATERIAL: QUARTZ
COLOR: CALACATTA OLYMPUS
PRODUCT NUMBER: Q4067
LOCATION: ALL BATHROOMS
NOTE: FOR COUNTERTOPS, & SHOWER BENCH IN PRIMARY BATHROOM

HEARTH

H1 STONE VENEER
MFG: BEDROSIAANS
MATERIAL: MARBLE STONE
COLOR: MALIBOU WHITE
ITEM CODE: 100006766
LOCATION: FIREPLACE HEARTH


MILLWORK

WD-1 UPPER CABINETRY
MFG: KRAFTMAID
STYLE: TAFT
WOOD: QUARTERSAWN OAK
FINISH: MOLASSES
PRODUCT NUMBER: Q4077
HARDWARE: REJUVENATION
COLLECTION: CLAYBOURNE CABINET COLLECTION
TYPE: CABINET KNOB
FINISH: UNLACQUERED BRASS
SKU: 7201075
QTY: TBD
LOCATION: KITCHEN, KITCHENETTE

WD-2 BASE CABINETRY
MFG: KRAFTMAID
STYLE: TAFT
WOOD: QUARTERSAWN OAK
FINISH: MOLASSES
PRODUCT NUMBER: Q4077
HARDWARE: REJUVENATION
COLLECTION: CLAYBOURNE CABINET COLLECTION
TYPE: DRAWER PULL
SIZE: 4"
FINISH: UNLACQUERED BRASS
SKU: 7370275
QTY: TBD
HARDWARE: REJUVENATION
COLLECTION: CLAYBOURNE CABINET COLLECTION
TYPE: DRAWER PULL
SIZE: 6"
FINISH: UNLACQUERED BRASS
SKU: 5486151
QTY: TBD
HARDWARE: REJUVENATION
COLLECTION: CLAYBOURNE CABINET COLLECTION
TYPE: BIN PULL
SIZE: 4"
FINISH: UNLACQUERED BRASS
SKU: 2551545
QTY: TBD
LOCATION: KITCHEN, KITCHENETTE

WD-3 APPLIANCE PANELS
MFG: KRAFTMAID
STYLE: TAFT
WOOD: QUARTERSAWN OAK
FINISH: MOLASSES
PRODUCT NUMBER: Q4077
HARDWARE: REJUVENATION
COLLECTION: CLAYBOURNE CABINET COLLECTION
TYPE: APPLIANCE PULL
SIZE: 12"
FINISH: UNLACQUERED BRASS
SKU: 1977341
QTY: TBD
LOCATION: KITCHEN

WD-4 VANITY CABINETRY
MFG: KRAFTMAID
STYLE: TAFT
WOOD: QUARTERSAWN OAK
FINISH: MOLASSES
PRODUCT NUMBER: Q4077
HARDWARE: REJUVENATION
COLLECTION: CLAYBOURNE CABINET COLLECTION
TYPE: CABINET KNOB
FINISH: UNLACQUERED BRASS
SKU: 7201075
QTY: TBD
HARDWARE: REJUVENATION
COLLECTION: CLAYBOURNE CABINET COLLECTION
TYPE: DRAWER PULL
SIZE: 4"
FINISH: UNLACQUERED BRASS
SKU: 7370275
QTY: TBD
LOCATION: ALL BATHROOMS

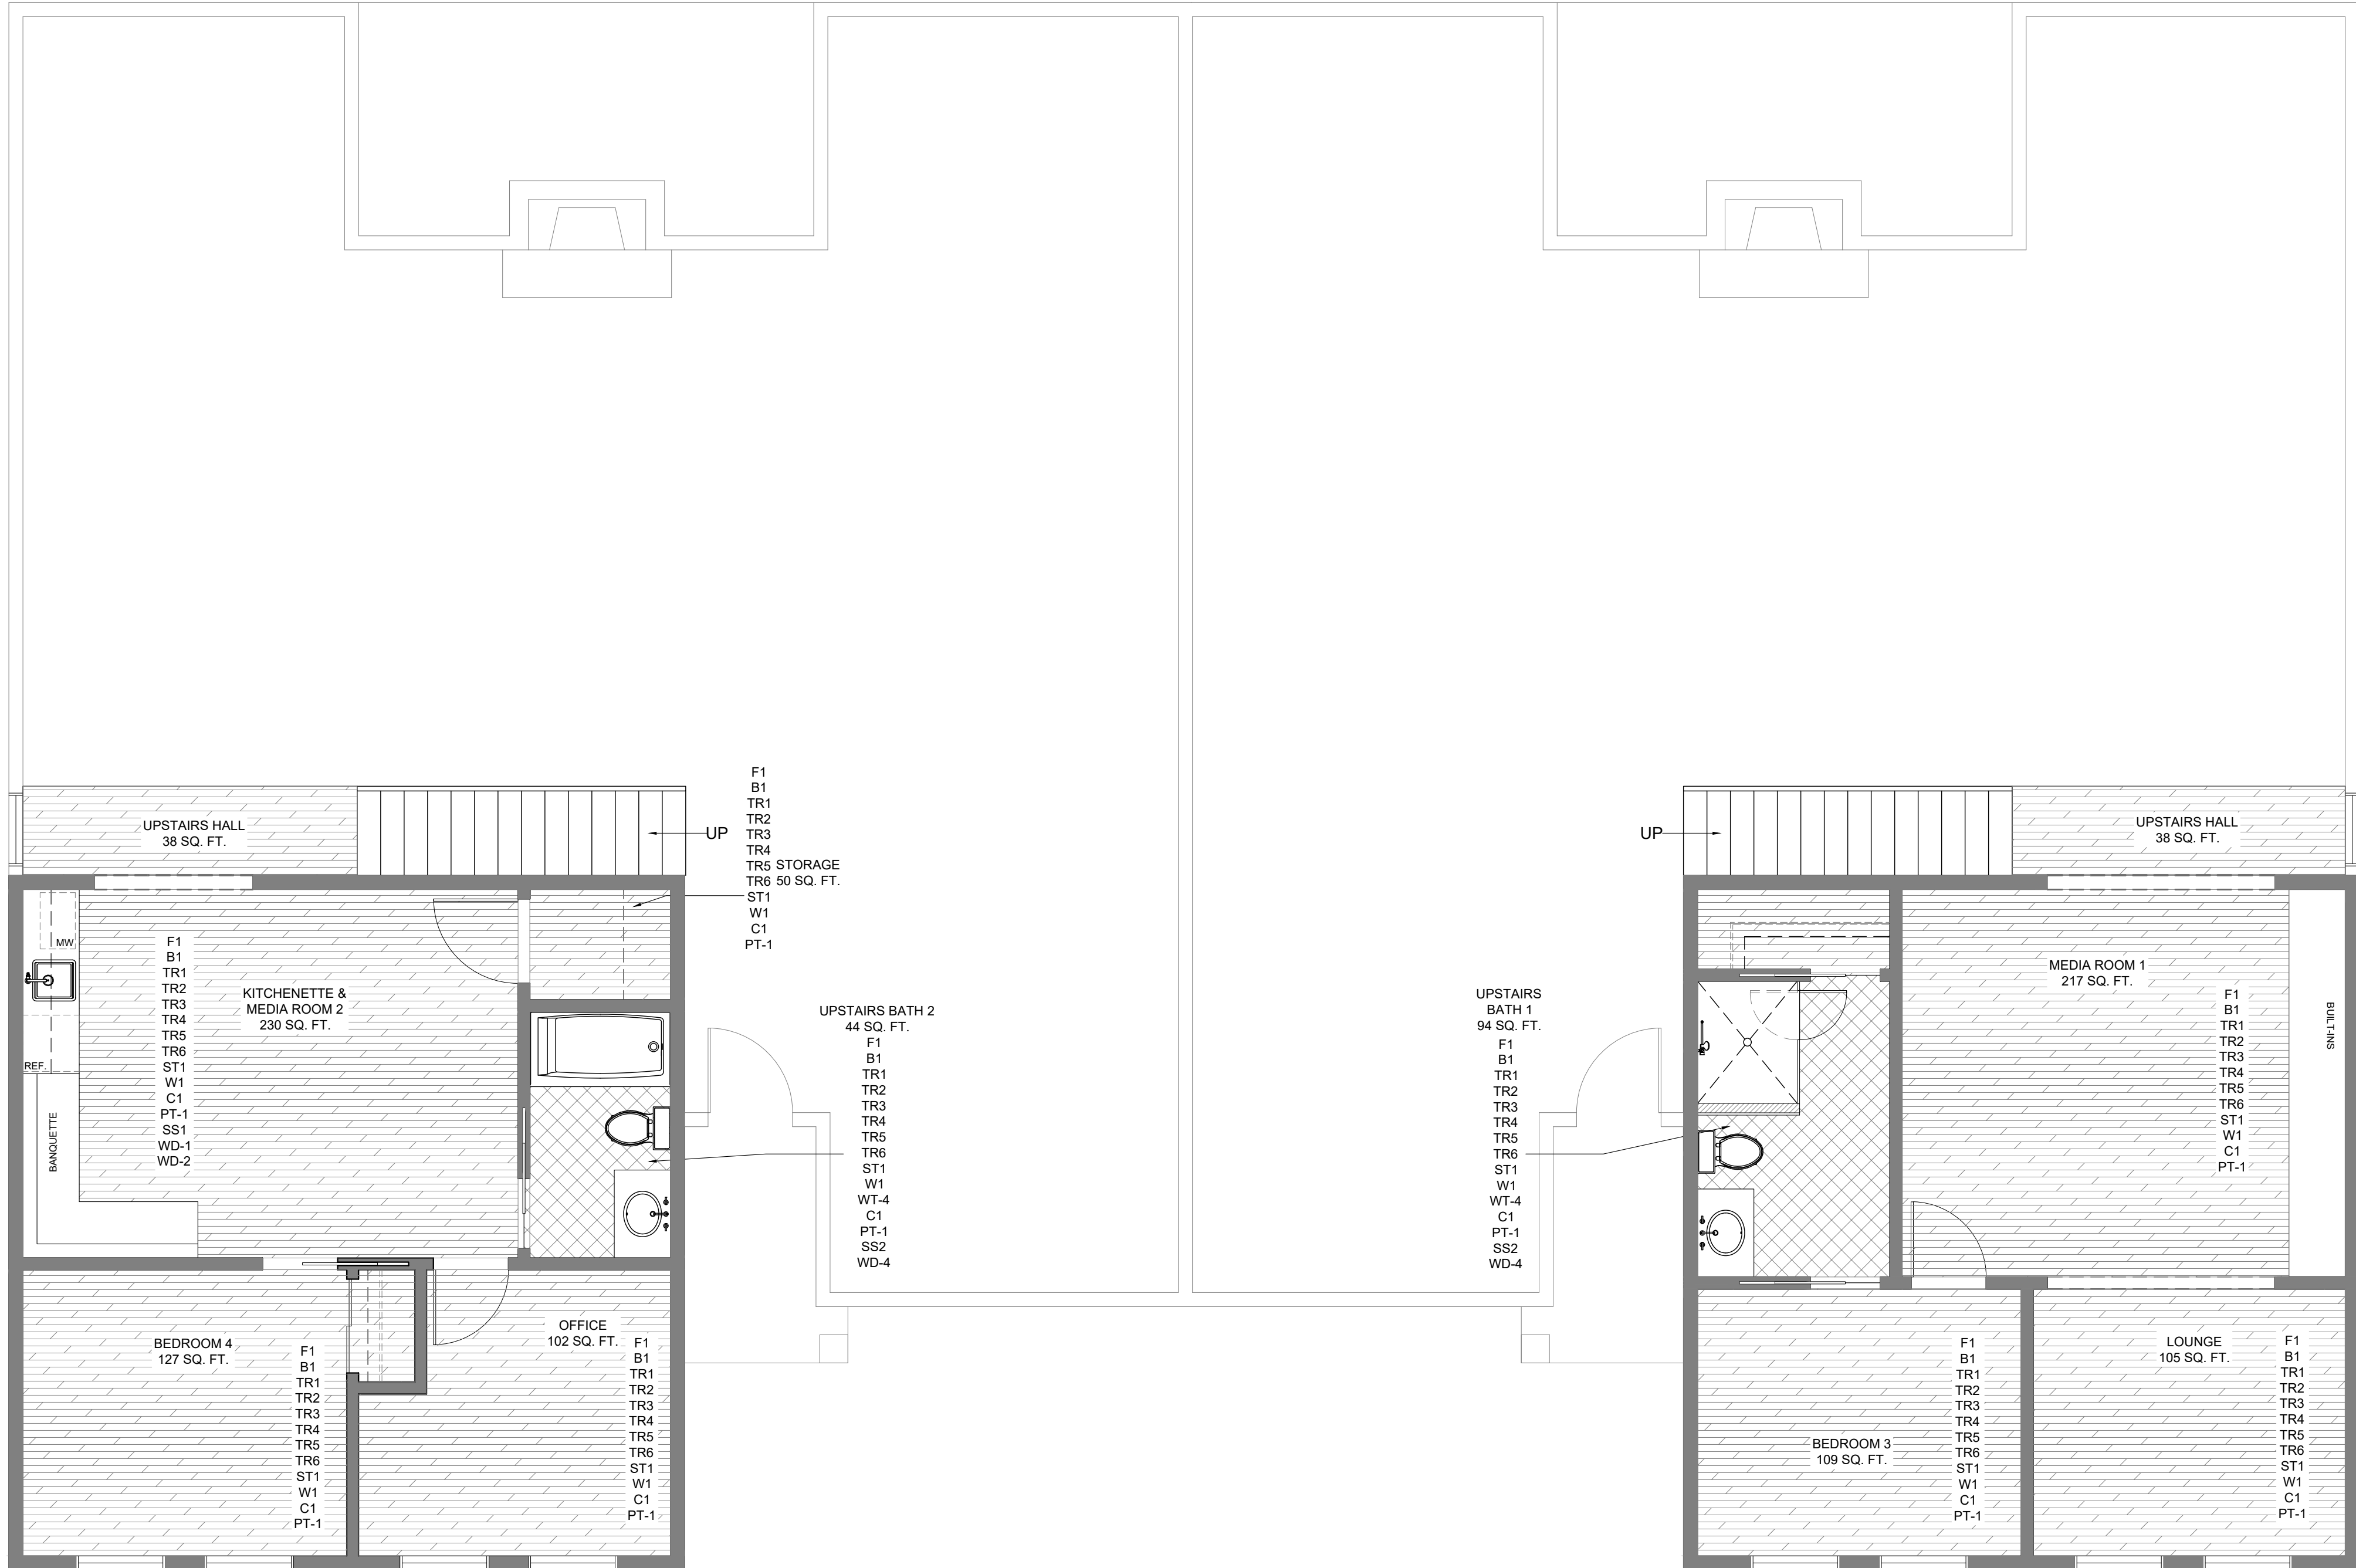




UNIVERSITY OF GEORGIA
TXMI 4300 STUDIO V: RICH
RESIDENTIAL DUPLEX CD SET
MONICA MAZUREK

REVISIONS:
DATE: 11.20.25


SCALE: $\frac{1}{4}" = 1' - 0"$

INTERIOR ELEVATIONS
& DETAILS


DET-12

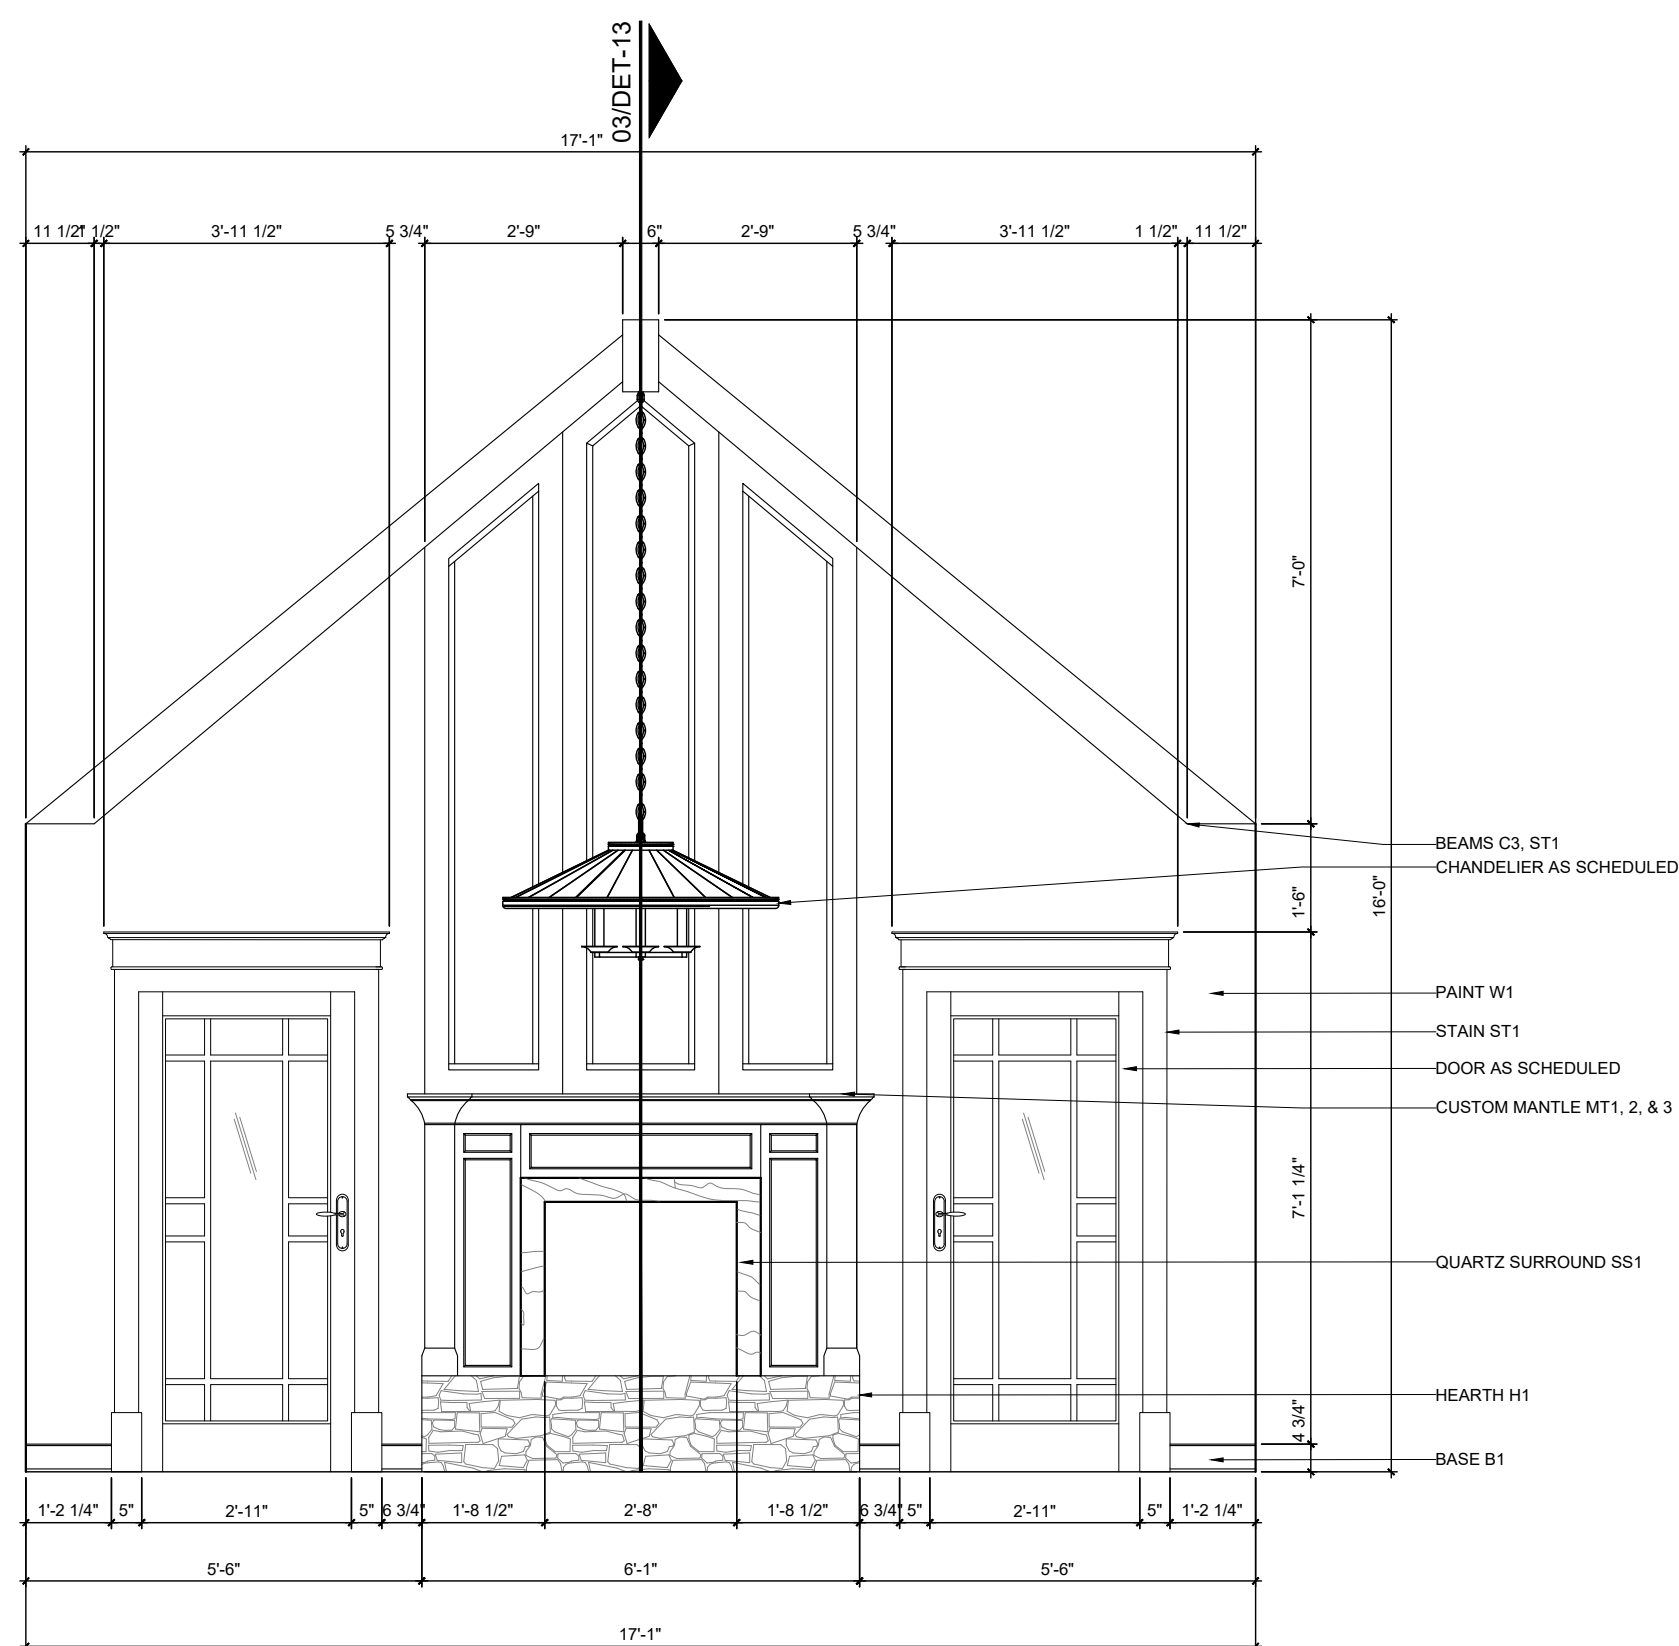


H FIREPLACE ELEVATION
SCALE: $\frac{1}{8}" = 1' - 0"$

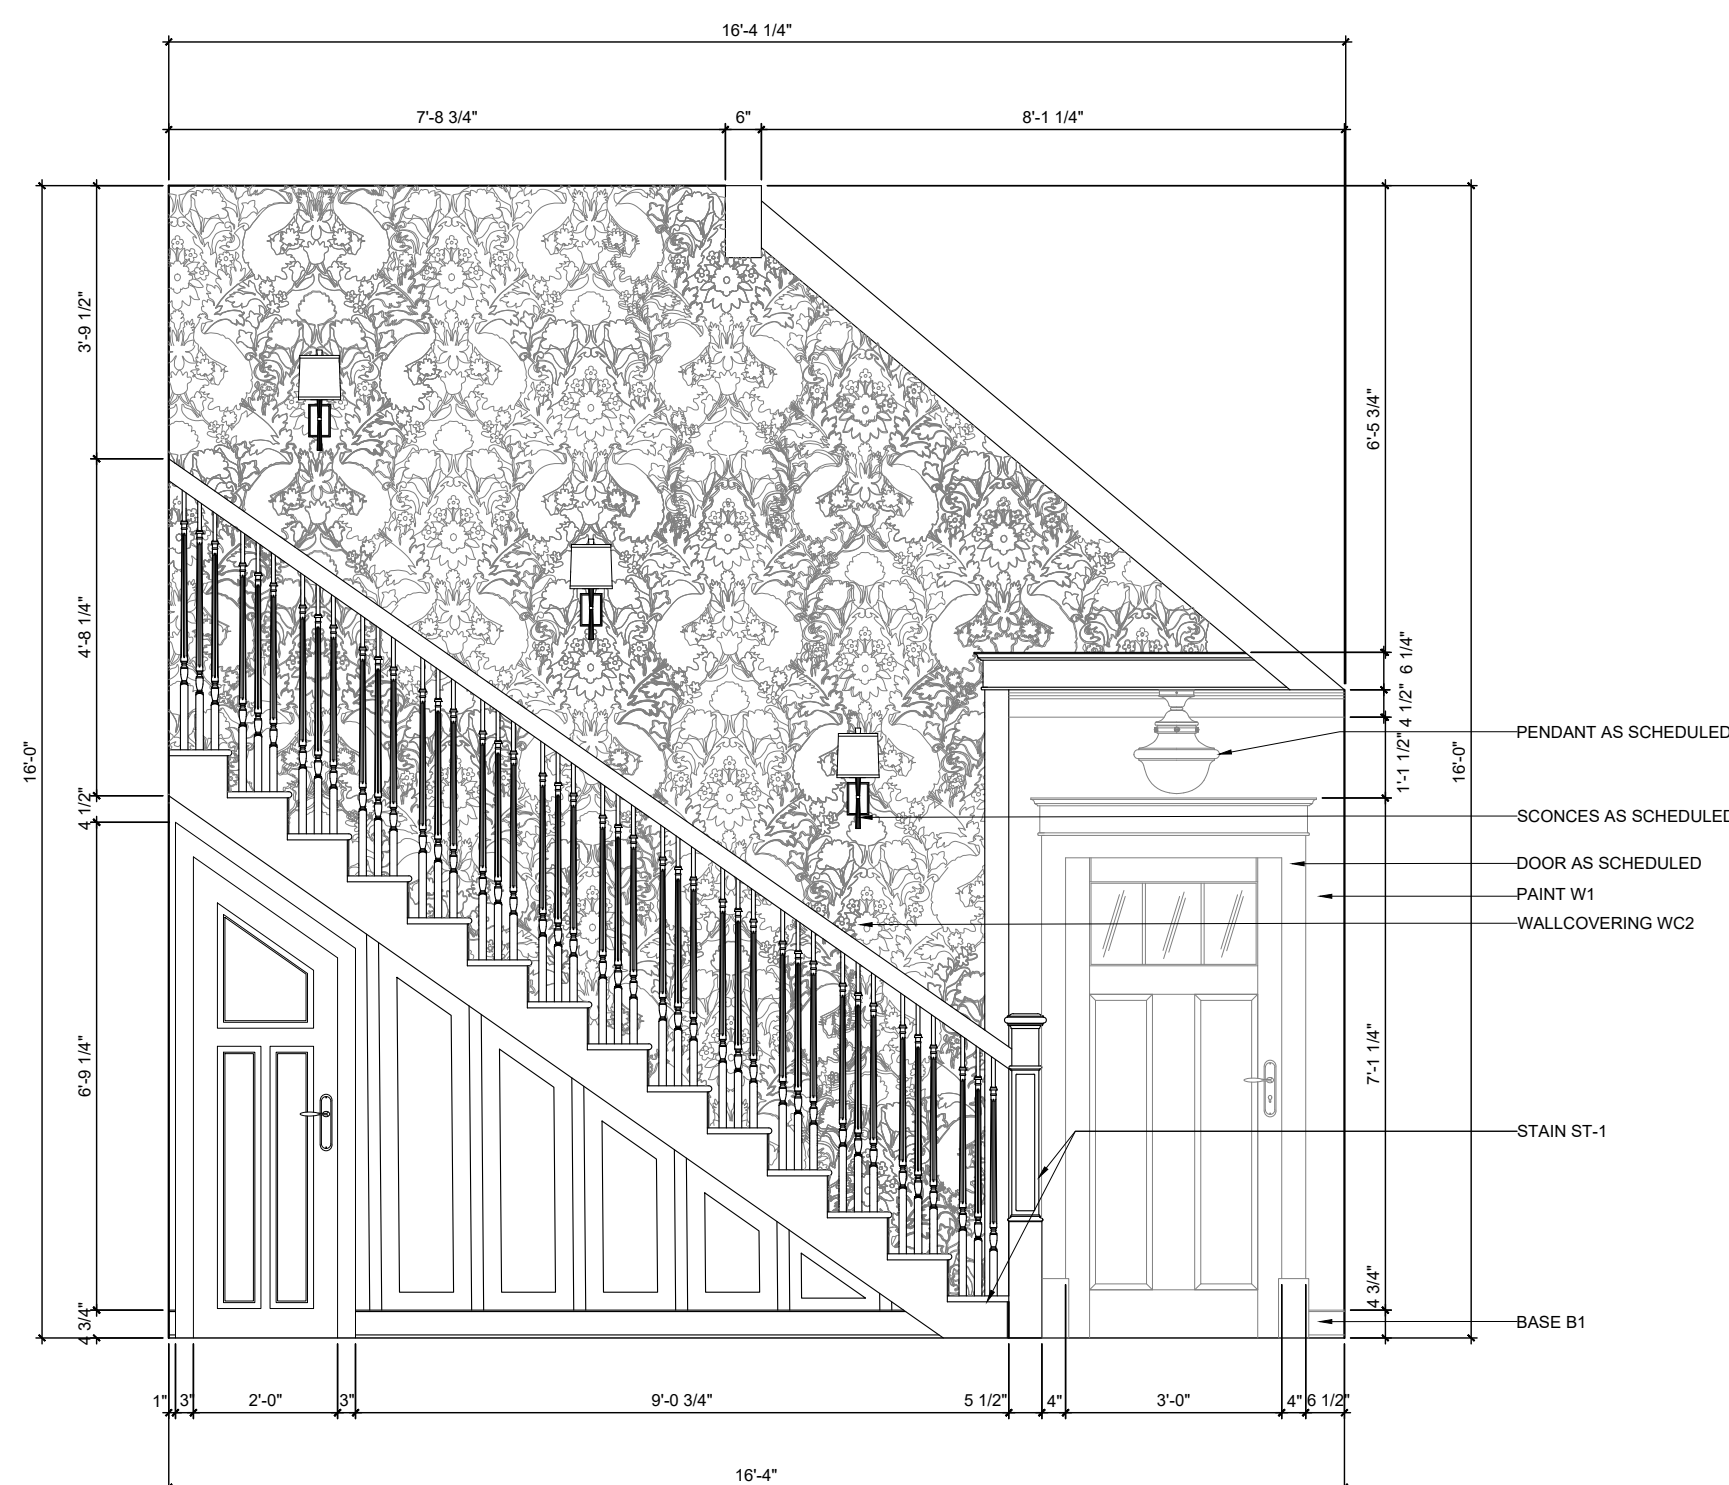


G STAIR ELEVATION
SCALE: $\frac{1}{8}" = 1' - 0"$

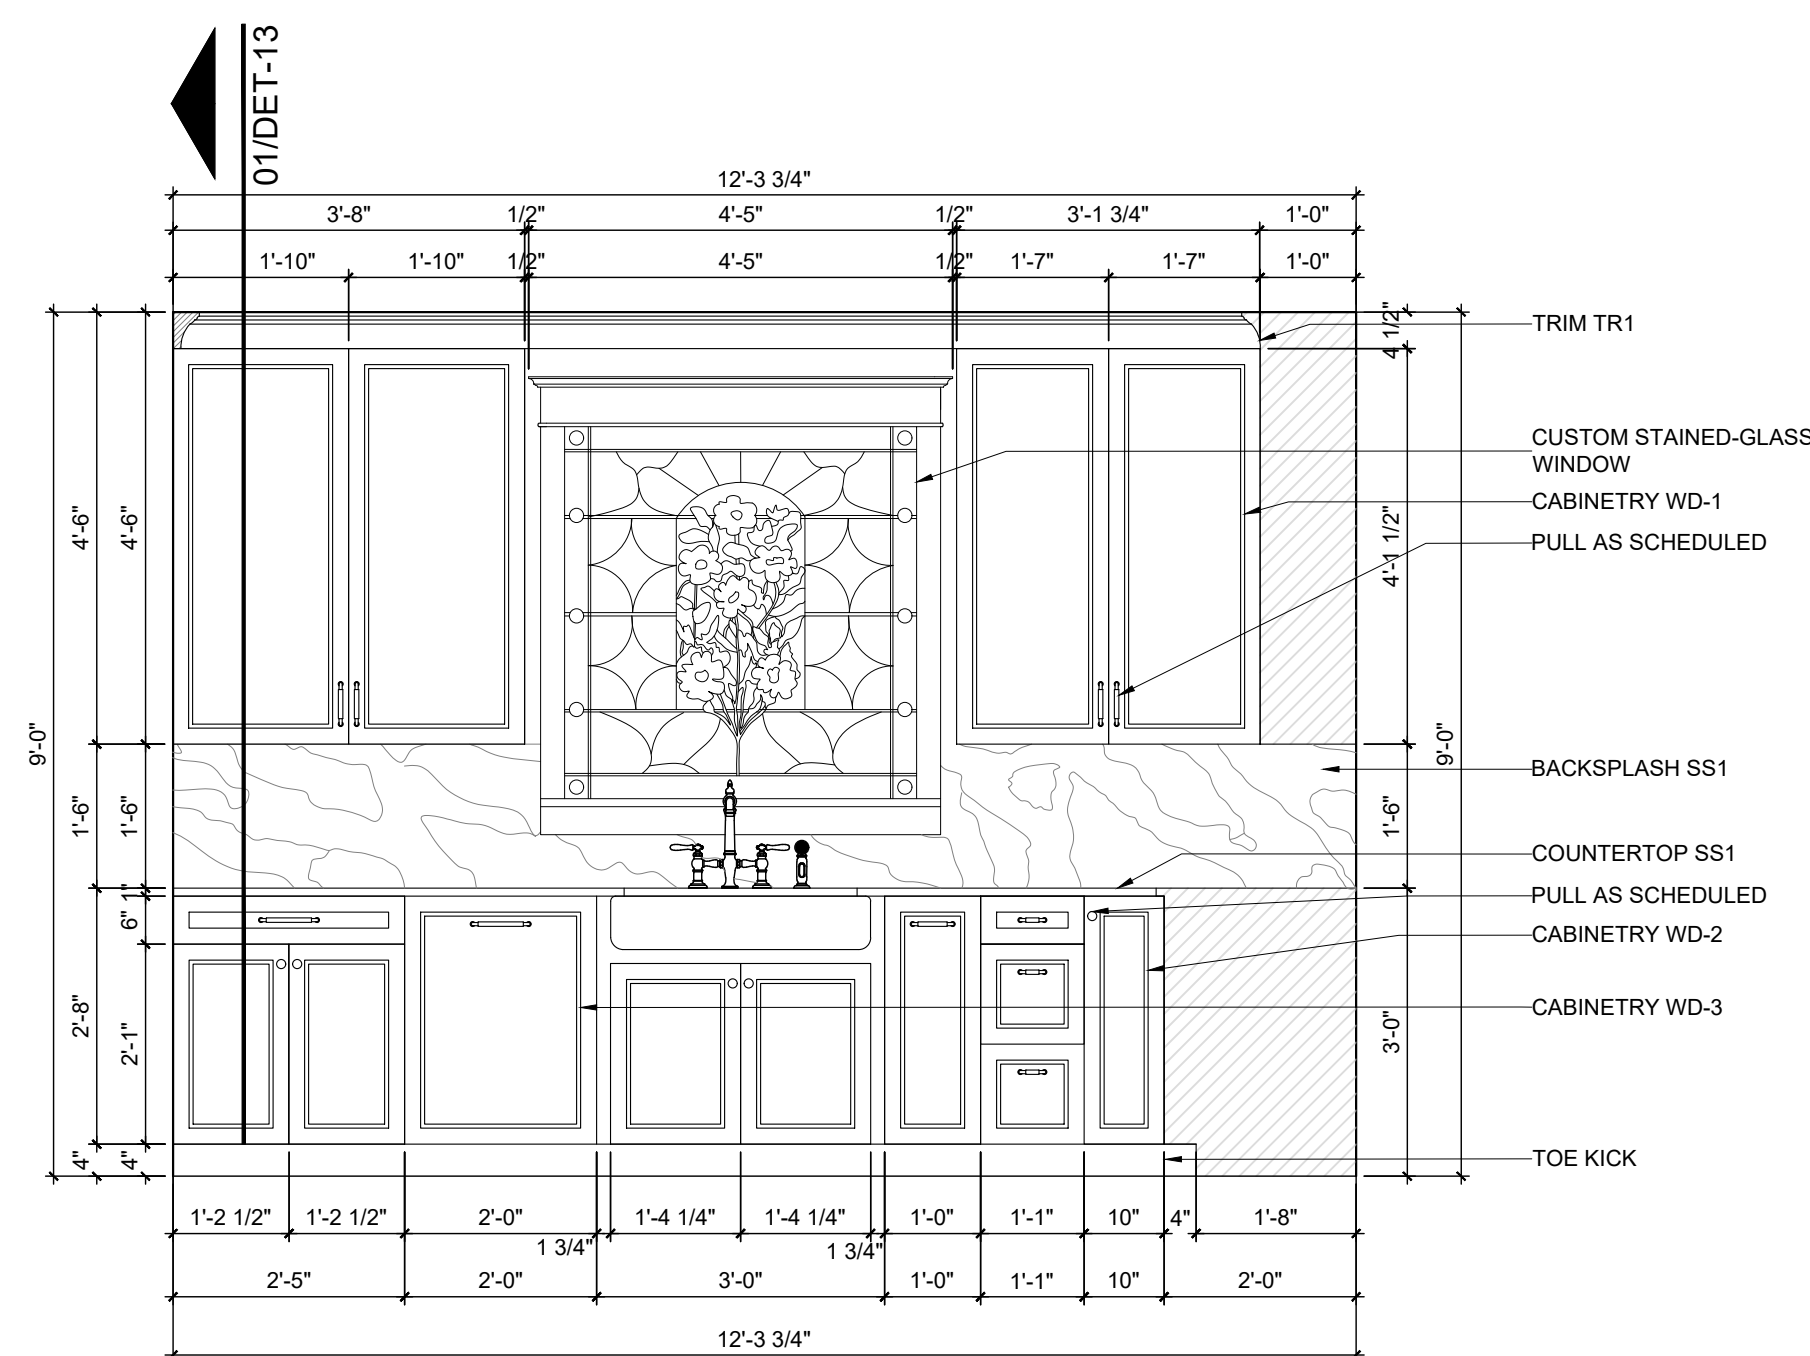


B KITCHEN SINK ELEVATION
SCALE: $\frac{1}{8}" = 1' - 0"$

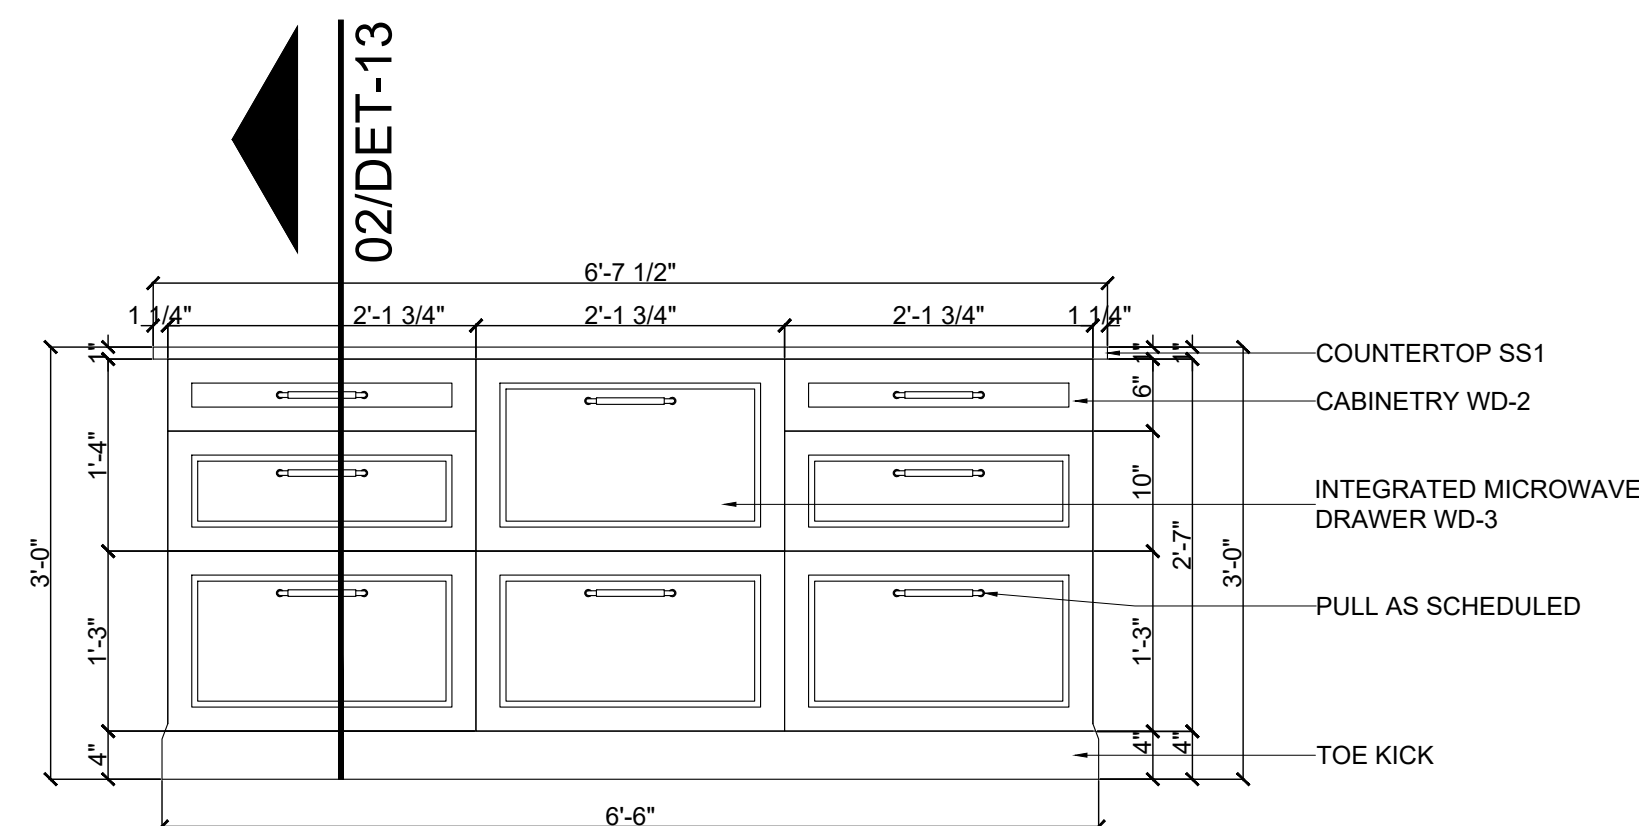


F FRONT ISLAND ELEV.
SCALE: $\frac{1}{8}" = 1' - 0"$

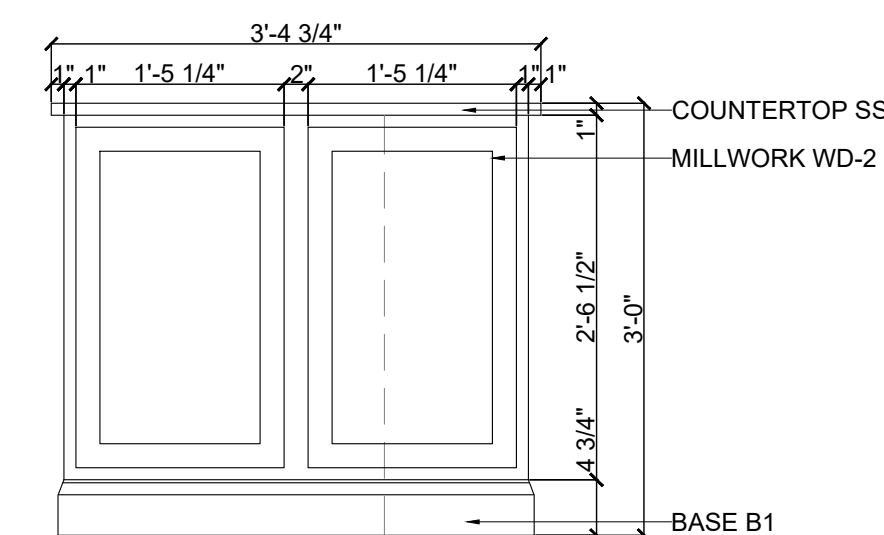


E SIDE ISLAND ELEV.
SCALE: $\frac{1}{8}" = 1' - 0"$

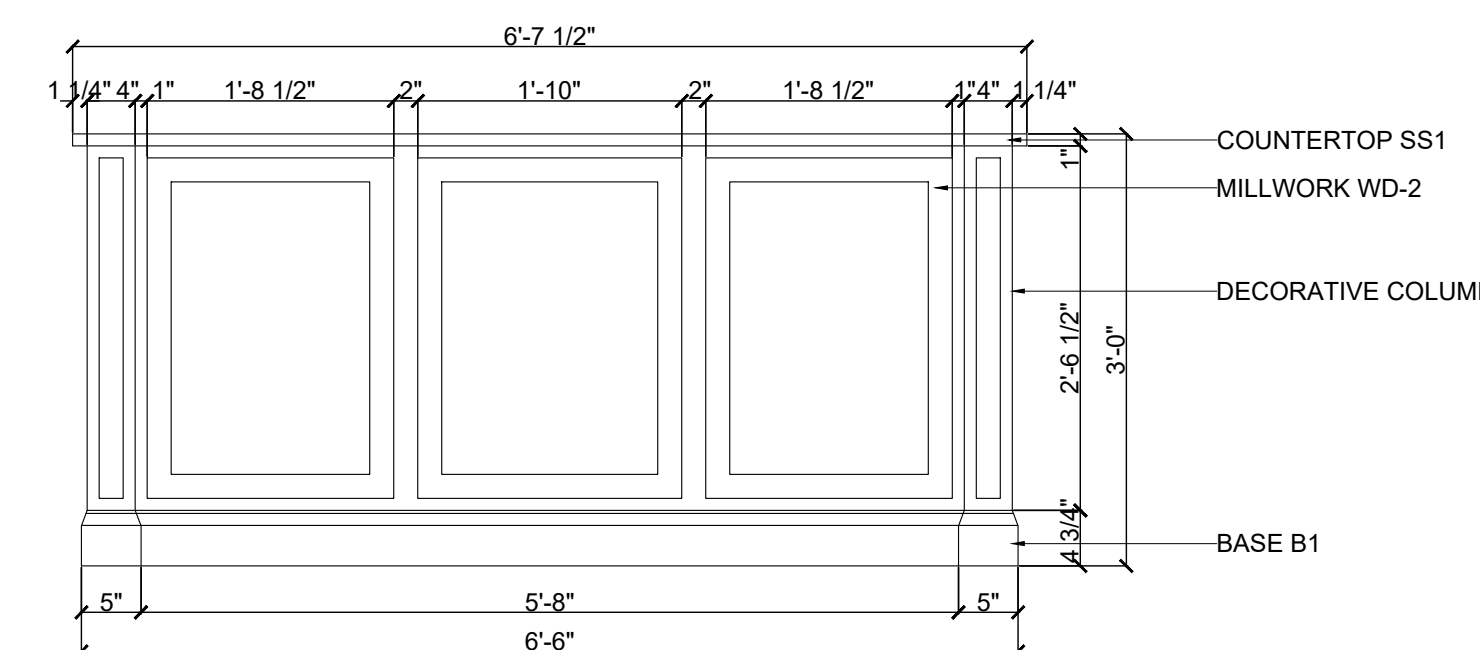

D BACK ISLAND ELEV.
SCALE: $\frac{1}{8}" = 1' - 0"$

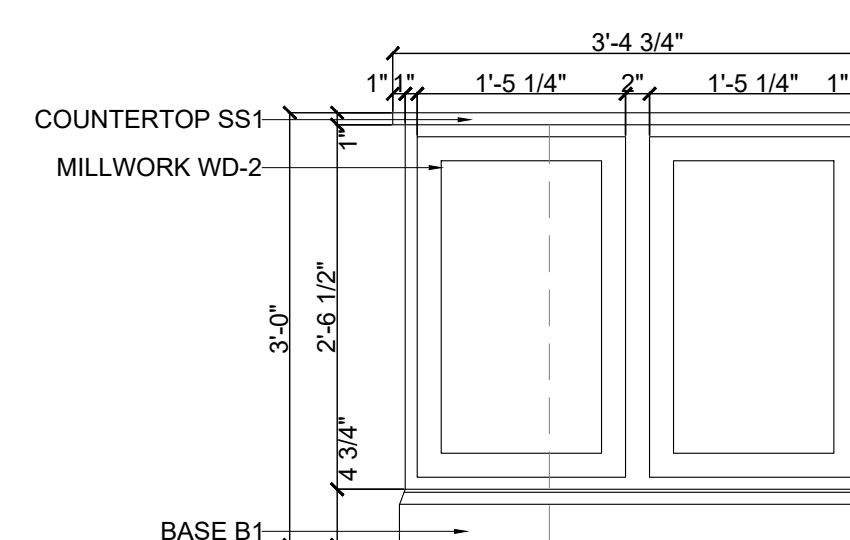

C SIDE ISLAND ELEV.
SCALE: $\frac{1}{8}" = 1' - 0"$

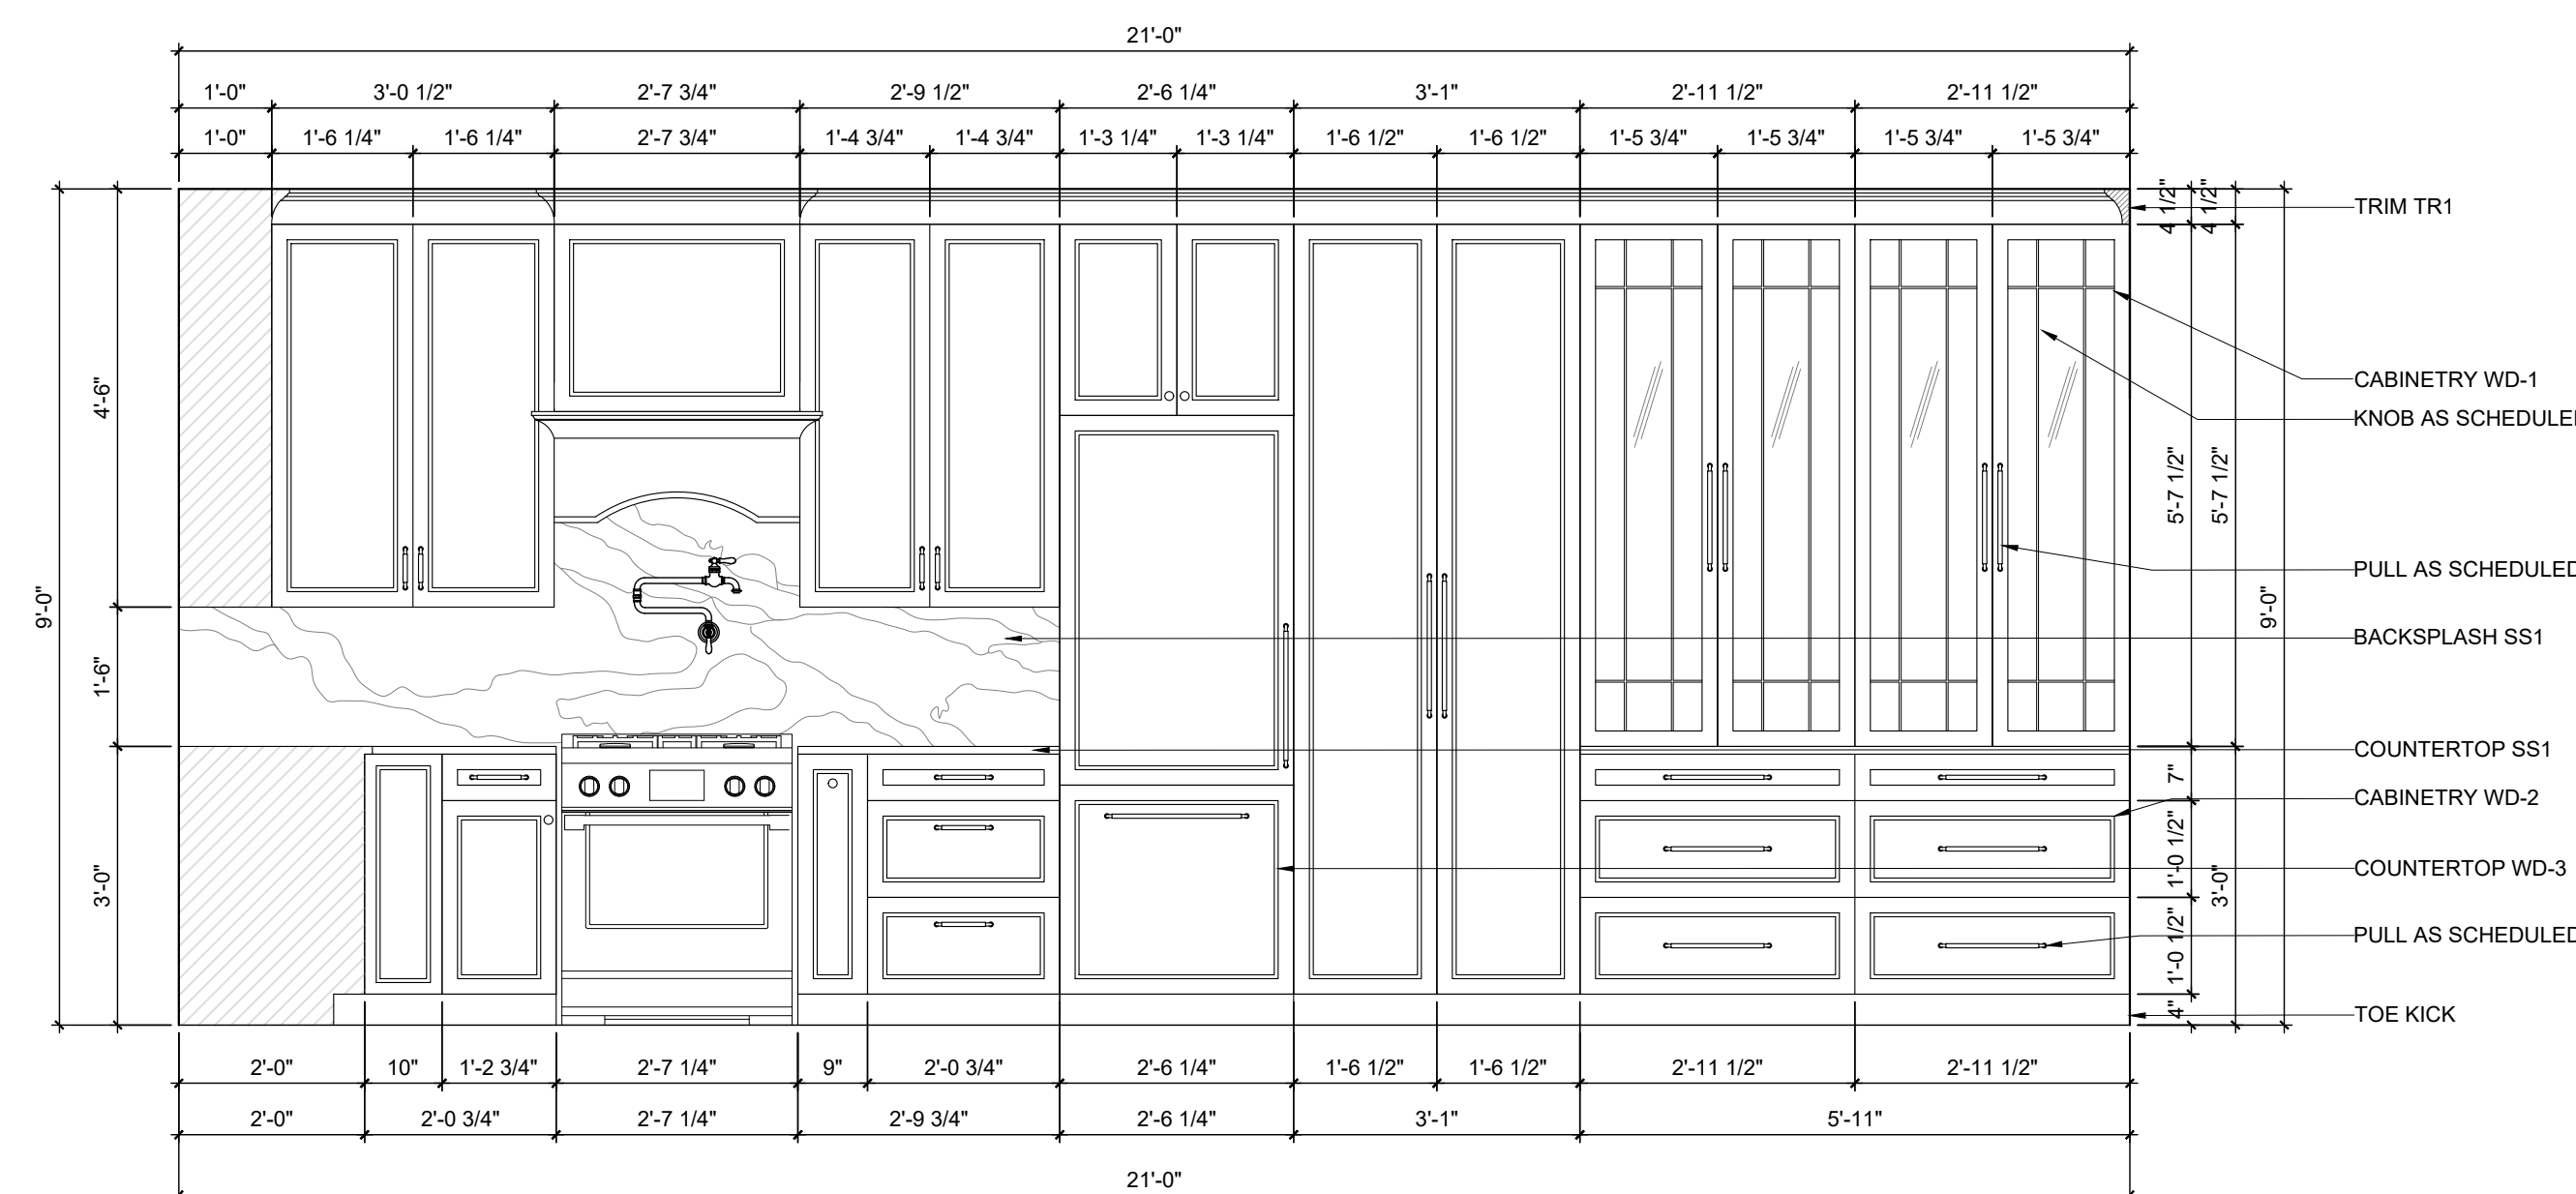

A KITCHEN STOVE ELEVATION
SCALE: $\frac{1}{8}" = 1' - 0"$




UNIVERSITY OF GEORGIA
TXMI 4300 STUDIO V: RICH
RESIDENTIAL DUPLEX CD SET
MONICA MAZUREK

REVISIONS:
DATE: 11.20.25

SCALE: $\frac{1}{4}" = 1' - 0"$

INTERIOR ELEVATIONS
& DETAILS
DET-13

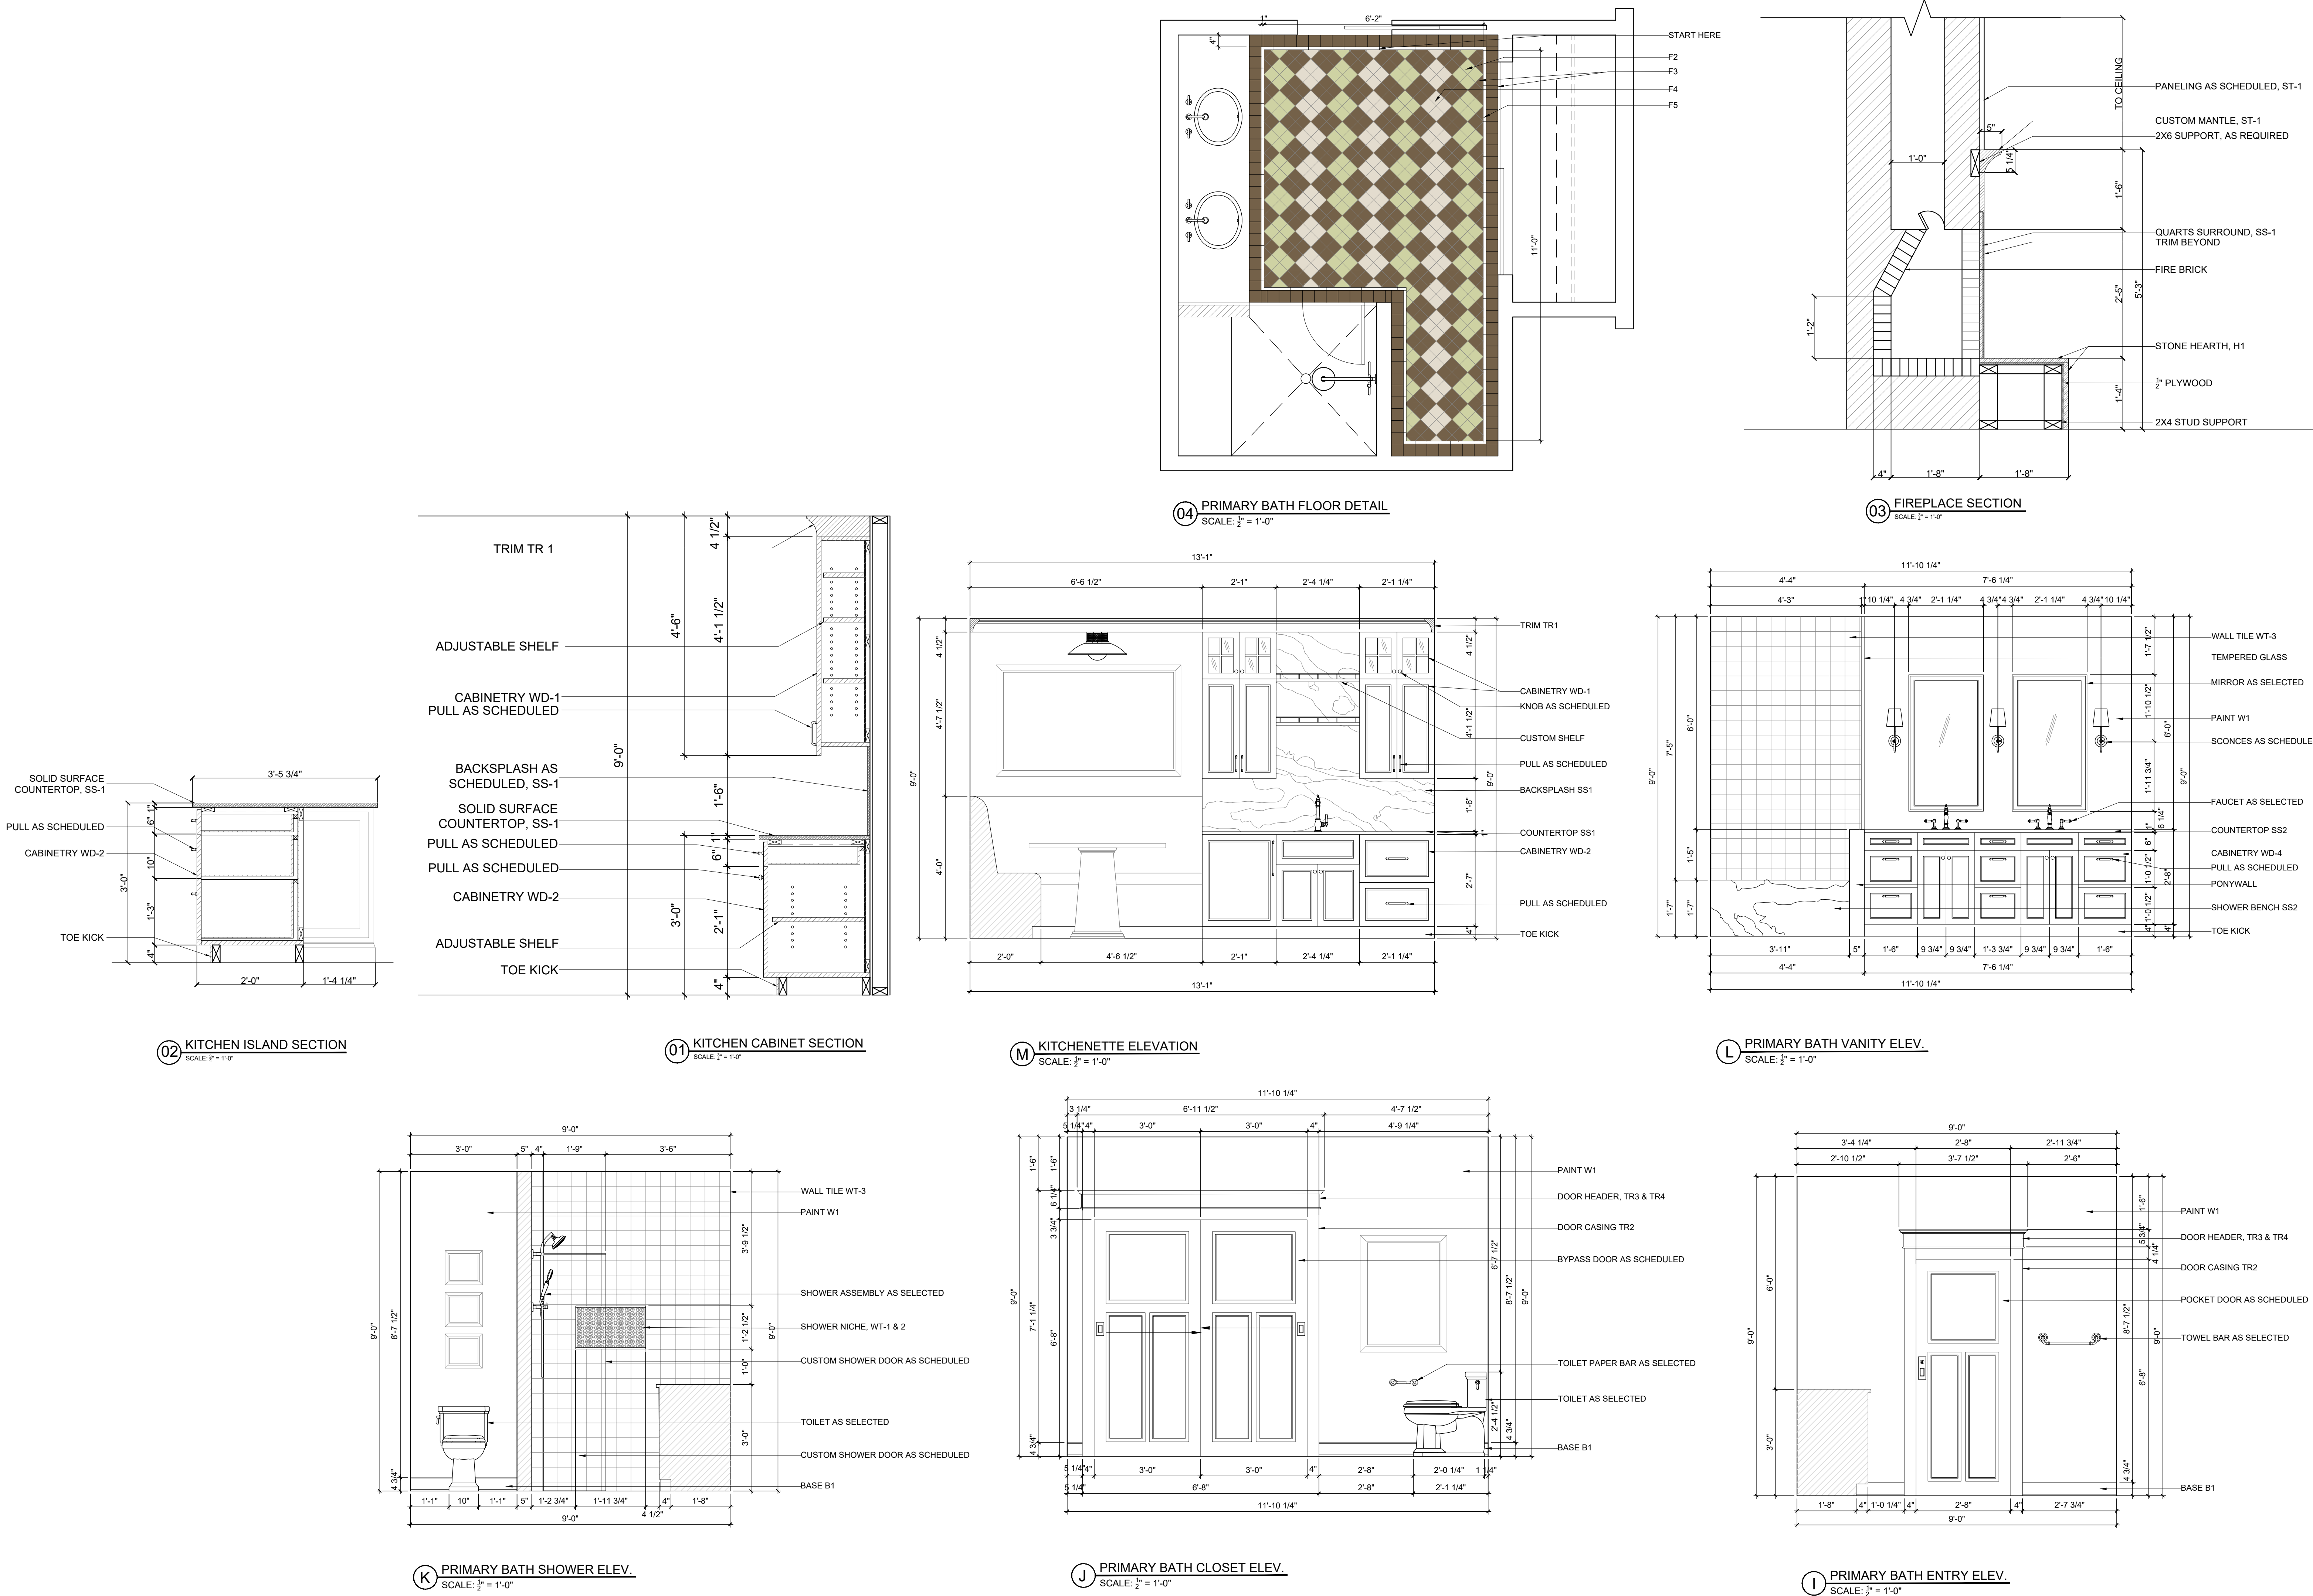



UNIVERSITY OF GEORGIA
TXMI 4300 STUDIO V: RICH
RESIDENTIAL DUPLEX CD SET
MONICA MAZUREK

REVISIONS:
DATE: 11.20.25

SCALE: $\frac{1}{4}" = 1' - 0"$

EXTERIOR
ELEVATIONS &
DETAILS

DET-13



N EXTERIOR ELEVATION
SCALE: $\frac{1}{2}" = 1' - 0"$

CRAFTSMAN INSPIRED DUPLEX SUPPORT BOARDS



FLOORING





COUNTERTOP



PAINT

KITCHEN/DINING

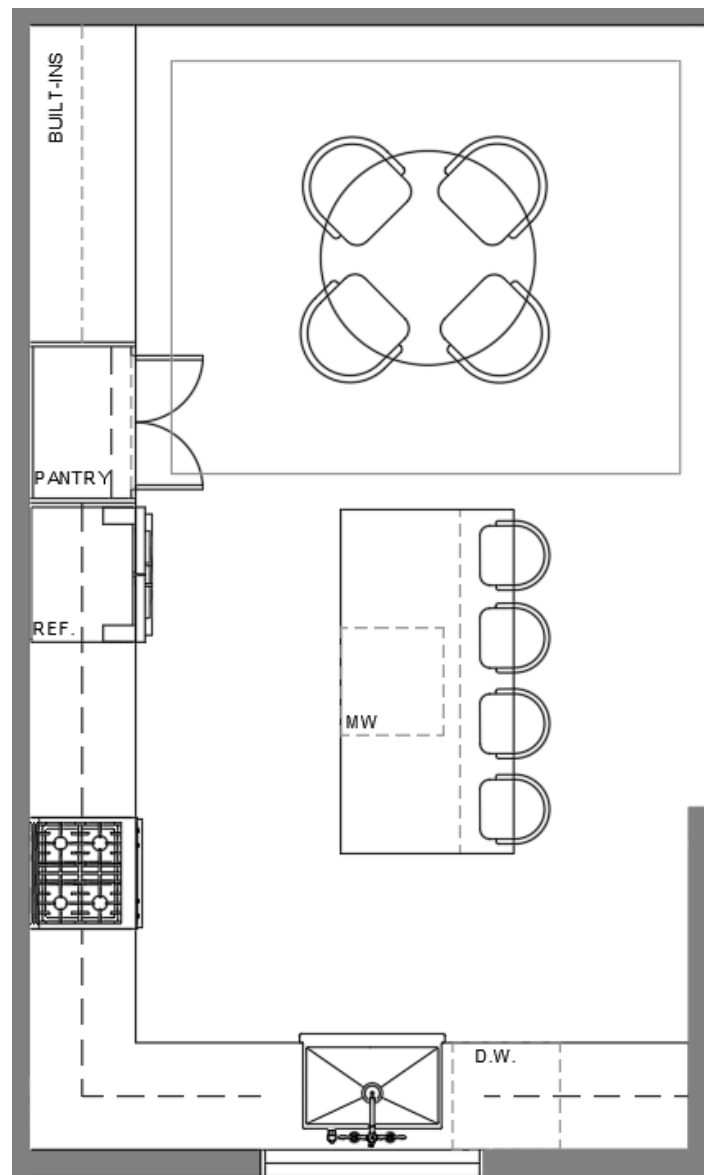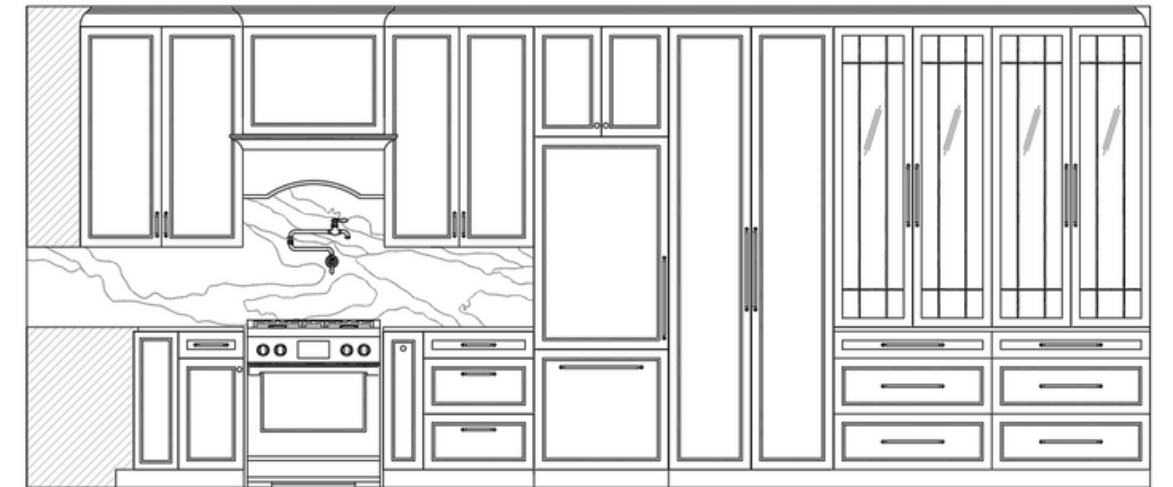

DINING WALLPAPER




GREAT ROOM/STAIRCASE



FLOORING



PAINT

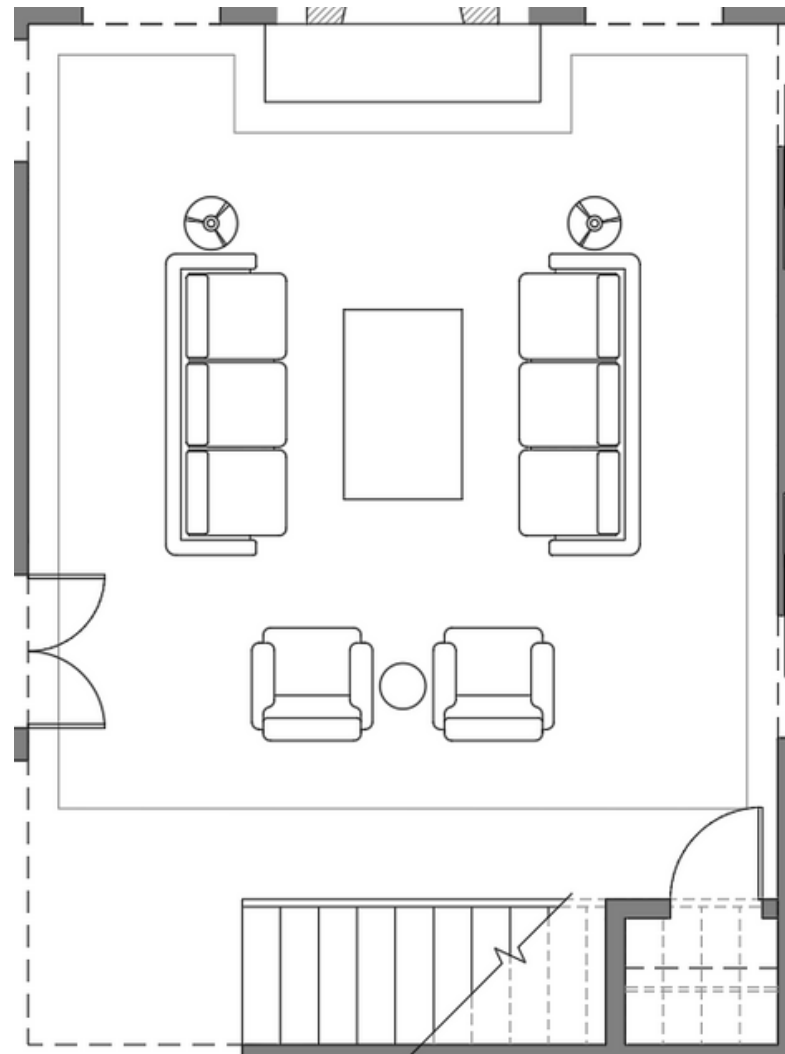

WALLCOVERING




FLOORING



PAINT

PRIMARY BEDROOM

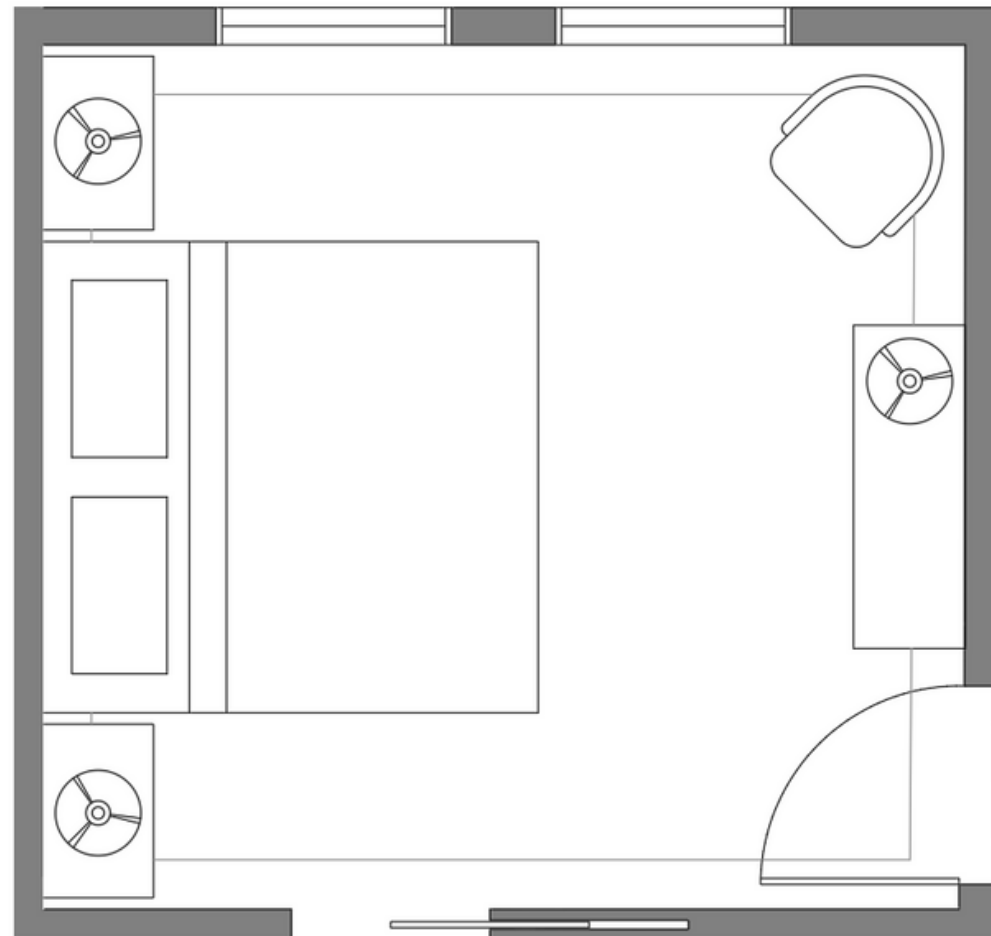



PRIMARY BATHROOM



COUNTERTOP



PAINT

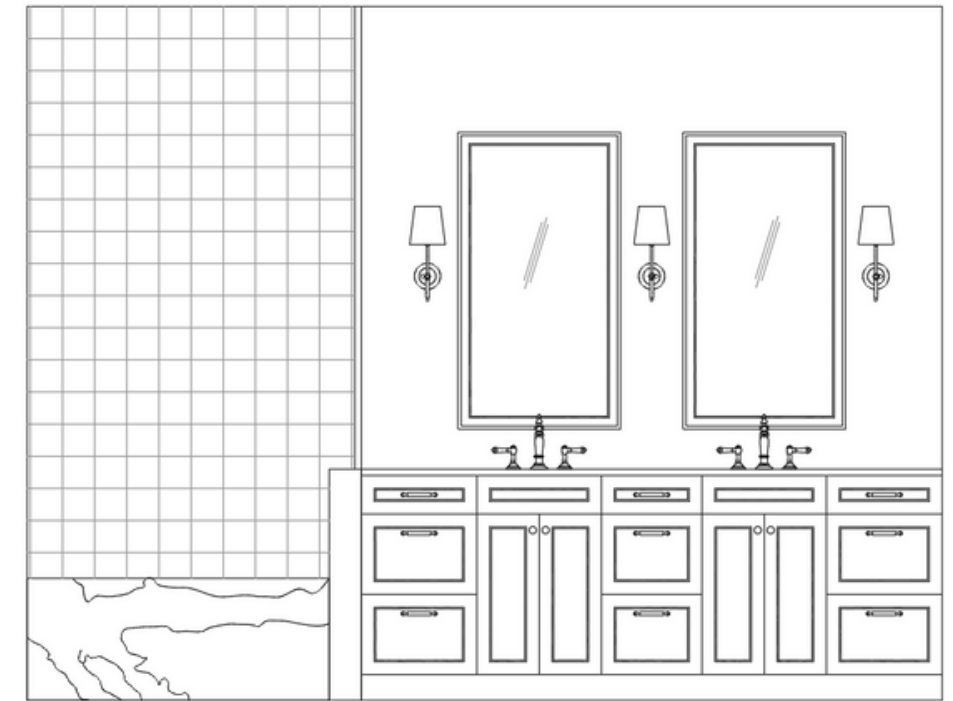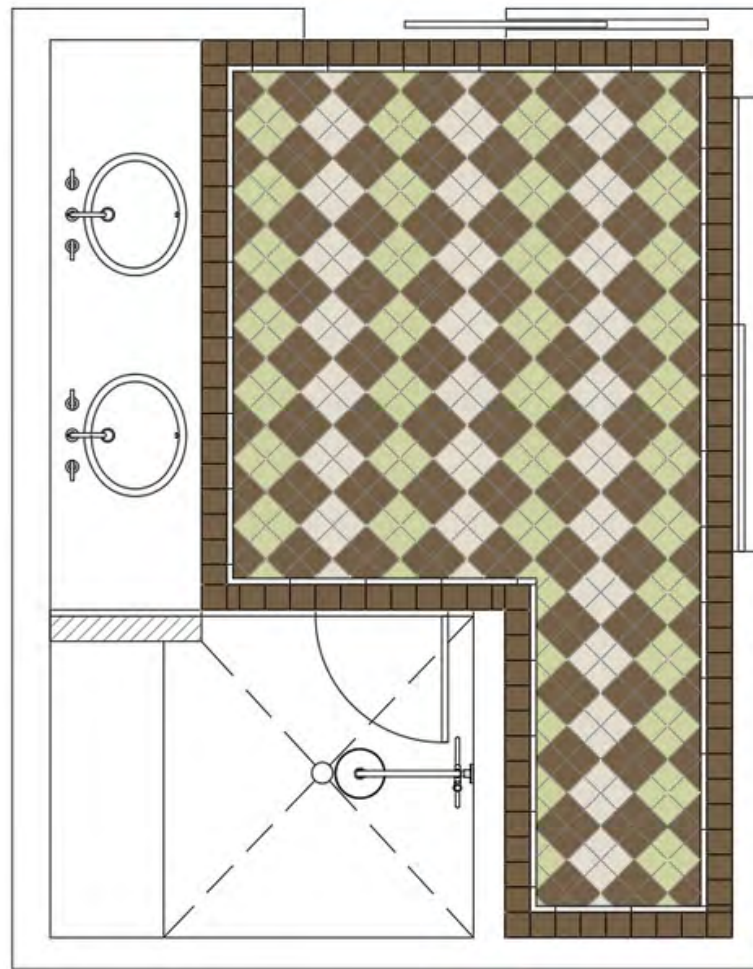



FLOORING



COUNTERTOP



PAINT

KITCHENETTE

