 


Type Mark	Family and Type	Rough Opening		Count
		Width	Height	
01	Ultra-Crank-Out-Casement-2wide: 2Ft 8In W x 6Ft H (KUS26) 2	2'-8"	6'-0"	29
06	Ultra-Crank-Out-Casement-3wide: 4Ft W x 6Ft H (KUS36) 2	4'-0"	6'-0"	2
07	Ultra-Crank-Out-Casement-3054x5: 5Wide: 12Ft L x 594x4 W x 6Ft 0In H (30KUS36-36-16) 2	12'-0"	1155/6"	6"
08	Ultra-Crank-Out-Casement-4wide: 8Ft W x 4Ft H (KUW46) 3	8'-0"	4'-0"	3
09	Ultra-Crank-Out-Casement-3wide: 4Ft W x 6Ft H (KUS36) 3	4'-0"	6'-0"	1
12	Ultra-Crank-Out-Casement-4wide: 8Ft W x 4Ft H (KUW46) 4	8'-0"	4'-6"	1



Brown Residence Door Schedule					
Door Number	To Room: Name	Family and Type	Height	Width	Count
15	FOYER	Casing, 18739; Casing, 18739 2 (6" WIDE)	7'-0"	6'-0"	1
15	BEDROOM 1	F02281, EN, Avenue-Hinge-Door:2019; 0.80 x 2.10	6'-0" 11/16"	2'-7 1/2"	1
16	DINING	Casing, 18739; Casing, 18739 2 (4" WIDE) 2	7'-0"	4'-0"	1
16	HALLWAY	F02281, EN, Avenue-Hinge-Door:2019; 0.80 x 2.10	6'-0" 11/16"	2'-7 1/2"	1
17	BEDROOM 2	F02281, EN, Avenue-Hinge-Door:2019; 0.80 x 2.10	6'-0" 11/16"	2'-7 1/2"	1
18	LIVING ROOM	Casing, 18739; Casing, 18739 2 (4" WIDE) 2	7'-0"	4'-0"	1
18	BEDROOM 2	Bolt4 - 4 Panels: 72" x 84"	7'-0"	6'-0"	1
19	SHARED BATH	F02281, EN, Avenue-Hinge-Door:2019; 0.80 x 2.10	6'-0" 11/16"	2'-7 1/2"	1
20	HALLWAY	F02281, EN, Avenue-Hinge-Door:2019; 0.80 x 2.10	6'-0" 11/16"	2'-7 1/2"	1
20	WC	Door-Interior-Single-1, Panel-Wood: 24" x 80"	6'-8"	2'-0"	1
21	PRIMARY CLOSET	Door-Interior-Double-Pocket-2, Panel-Wood: 72" x 80" 2	6'-8"	6'-0"	1
22	PRIMARY BEDROOM	F02281, EN, Avenue-Hinge-Door:2019; 0.80 x 2.10	6'-0" 11/16"	2'-7 1/2"	1
23	FOYER	Ornamental, Front, Door, 17745, Adjustable	7'-0"	3'-0"	1
48	KITCHEN	Casing, 18739; Casing, 18739 2 (4" WIDE) 3	7'-0"	4'-0"	1
49	LIVING ROOM	Casing, 18739; Casing, 18739 2 (6" WIDE)	7'-0"	6'-0"	1

Room Schedule:

Room Number	Room Name	Area (SF)
1	CL 1	11
2	CL 2	23
3	CL 3	11
4	CL 4	35
5	CL 5	19
6	CL 6	21
7	CL 7	11
8	CL 8	11
9	CL 9	11
10	CL 10	11
11	CL 11	11
12	HALLWAY	358
13	PLAYROOM	323
14	CL 12	23
15	BEDROOM 1	349
16	BEDROOM 2	355
17	SHARED BATH	130
18	WC	18
19	CL 13	11
20	BEDROOM 3	355
21	CL 14	21
22	PRIMARY BEDROOM	388
23	PRIMARY CLOSET	98
24	PRIMARY BATH	116

① Second Floor Dimension Plan
1/4" = 1'-0"



John Brown
New Residence
Second Floor Plan


Project number	2025-3
Date	12.02.25
Drawn by	E. ACKERMAN
Checked by	Checker
A2	
Scale	1/4" = 1'-0"



Consultant
Address
Address
Phone
Fax
e-mail

[illegible]

Project number	2025-3
Date	12.02.25
Drawn by	E. ACKERMAN
Checked by	Checker
A3	
Scale	1/4" = 1'-0"

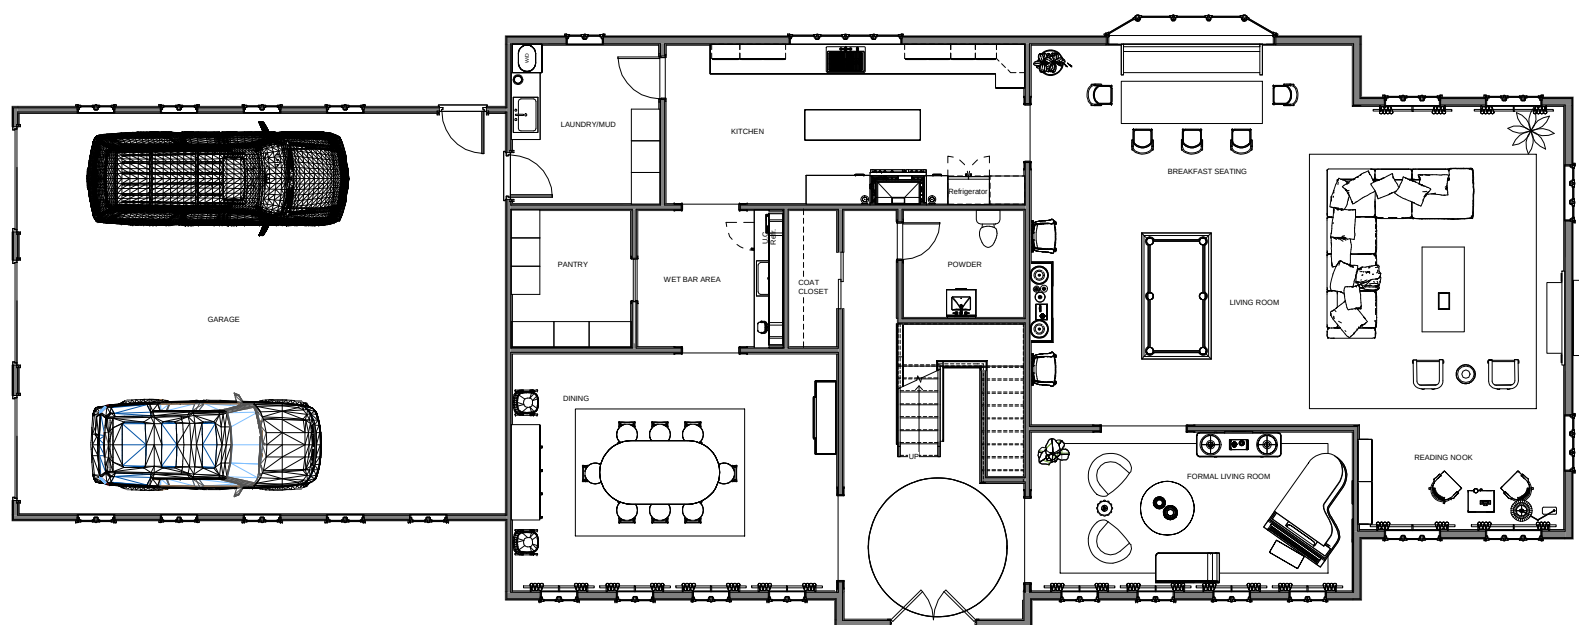

① First Floor Furniture Plan
1/4" = 1'-0"




Consultant
Address
Address
Phone
Fax
e-mail

Consultant
Address
Address
Phone
Fax
e-mail

Consultant
Address
Address
Phone
Fax
e-mail

Consultant
Address
Address
Phone
Fax
e-mail

Consultant
Address
Address
Phone
Fax
e-mail

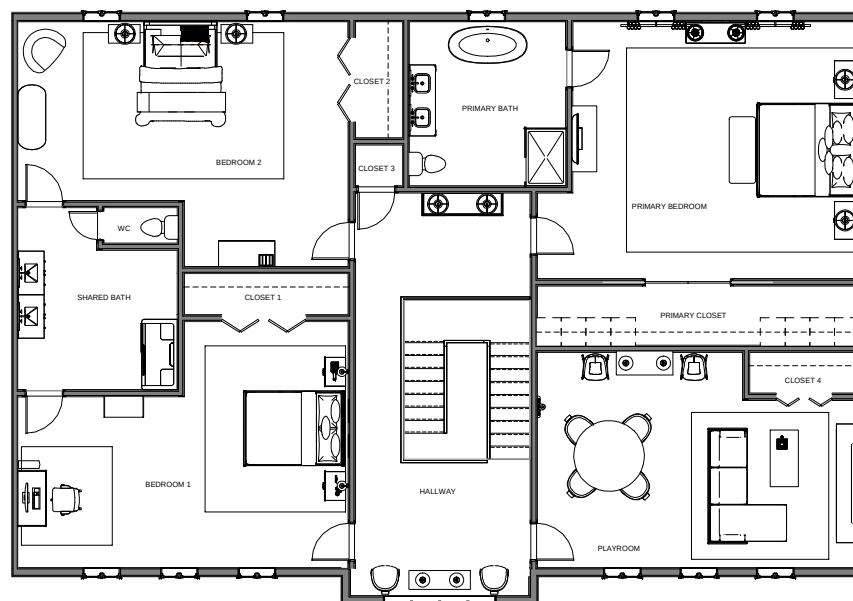

① Second Floor Furniture Plan
1/4" = 1'-0"

[illegible]

John Brown
New Residence
Second Floor Furniture Plan

Project number	2025-3
Date	12.02.25
Drawn by	E. ACKERMAN
Checked by	Checker
A4	
Scale	1/4" = 1'-0"



Consultant	
Address	
Address	
Phone	
Fax	
e-mail	

Consultant
Address
Address
Phone
Fax
e-mail

Consultant:
Address:
Address:
Phone:
Fax:
e-mail:


Consultant:
Address:
Address:
Phone:
Fax:
e-mail:

Consultant
Address
Address
Phone
Fax
e-mail

[illegible]

John Brown
New Residence
Roof-Site Plan

Project number	2025-3
Date	12.02.25
Drawn by	E. ACKERMAN
Checked by	Checker
A5	
Scale	1" = 10'-0"

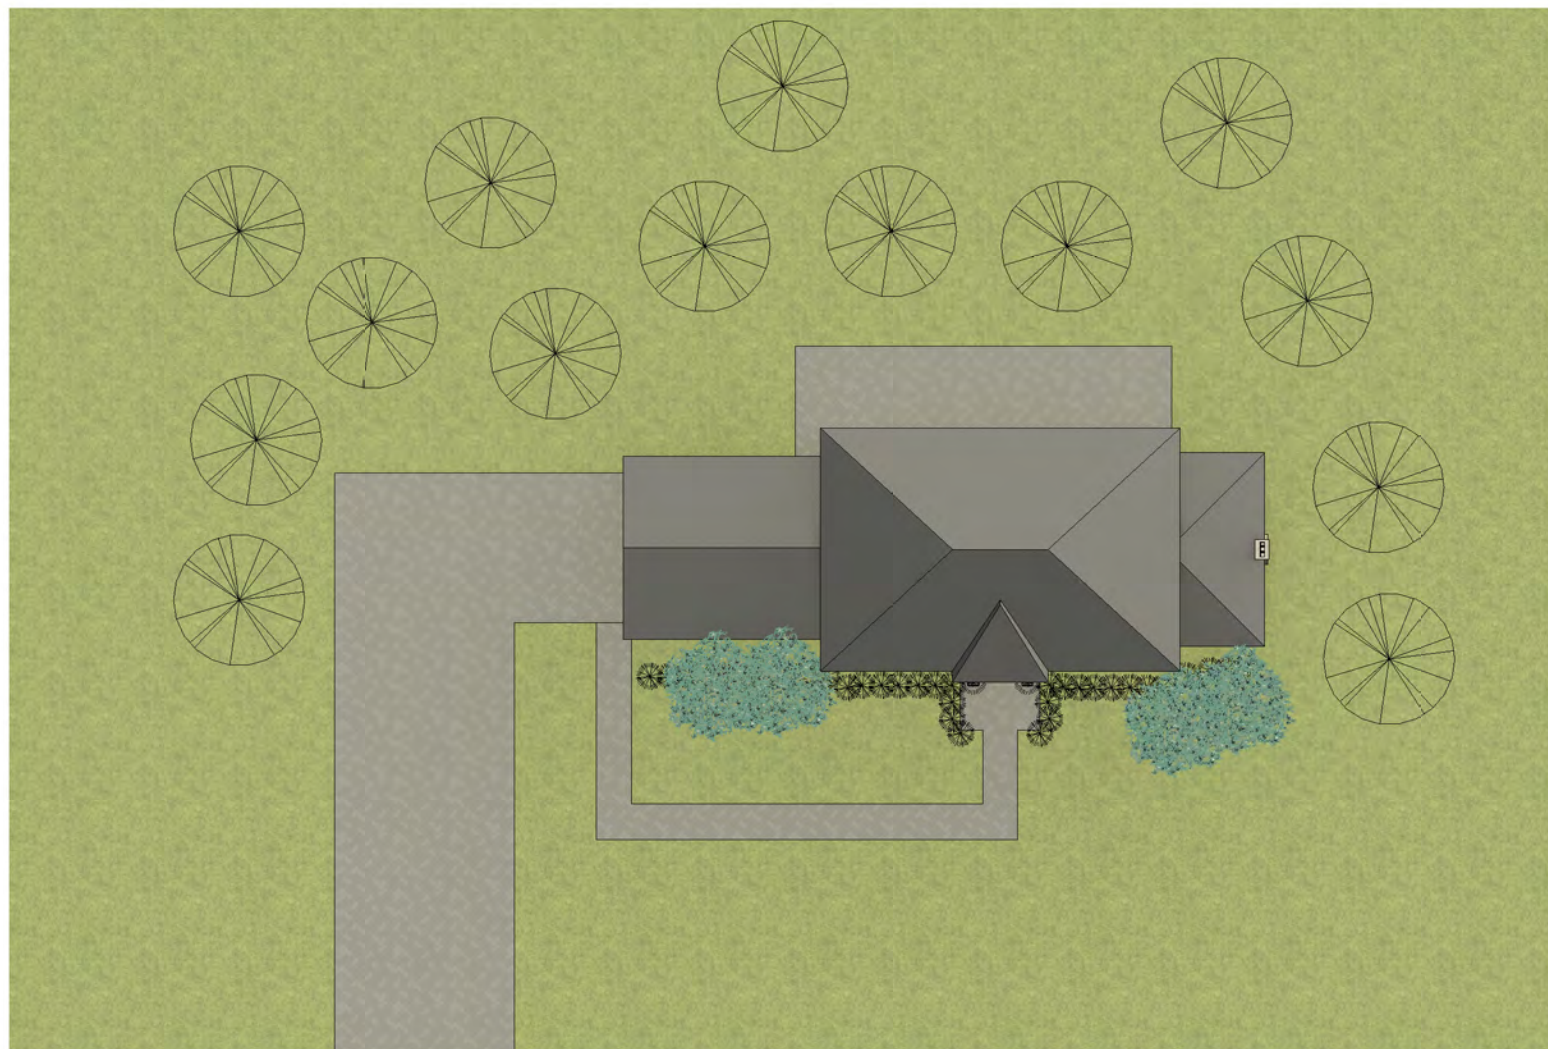[illegible]

① Site Plan
1" = 10'-0"



Consultant
Address
Address
Phone
Fax
e-mail

Consultant
Address
Address
Phone
Fax
e-mail

Consultant
Address
Address
Phone
Fax
e-mail

Consultant
Address
Address
Phone
Fax
e-mail

Consultant:
Address:
Address:
Phone:
Fax:
e-mail:

[illegible]


John Brown
New Residence
First Floor Electrical

Project number	2025-3
Date	12.02.25
Drawn by	E. ACKERMAN
Checked by	Checker
A6	
Scale	1/4" = 1'-0"

Brown Residence Electrical Fixture Schedule		
Family and Type		Count
Kitchen Built-In Dishwasher - HAFELE Florence: Smart Mate 495.06.530		1
Outlet-Floor: Duplex: Single		1
Outlet-Communications: CATV		3
Outlet-Duplex: Single		62
Outlet-GFI: Single		26
Outlet-GFI: Single 2		1
Outlet-Range: Single		1
Outlet-Triplic: Triplex		1
Switch-Double: Double		3
Switch-Single: Single		13
Switch-Three Way: Three Way		17
Weather Proof receptacle, Standard		10

ELECTRICAL LEGEND

	STANDARD DUPLEX OUTLET
	STANDARD GFI OUTLET
	240 RANGE OUTLET
	SPECIALTY OUTLET
	TV JACK/OUTLET
	WEATHERPROOF OUTLET
	RECESSED DUPLEX OUTLET

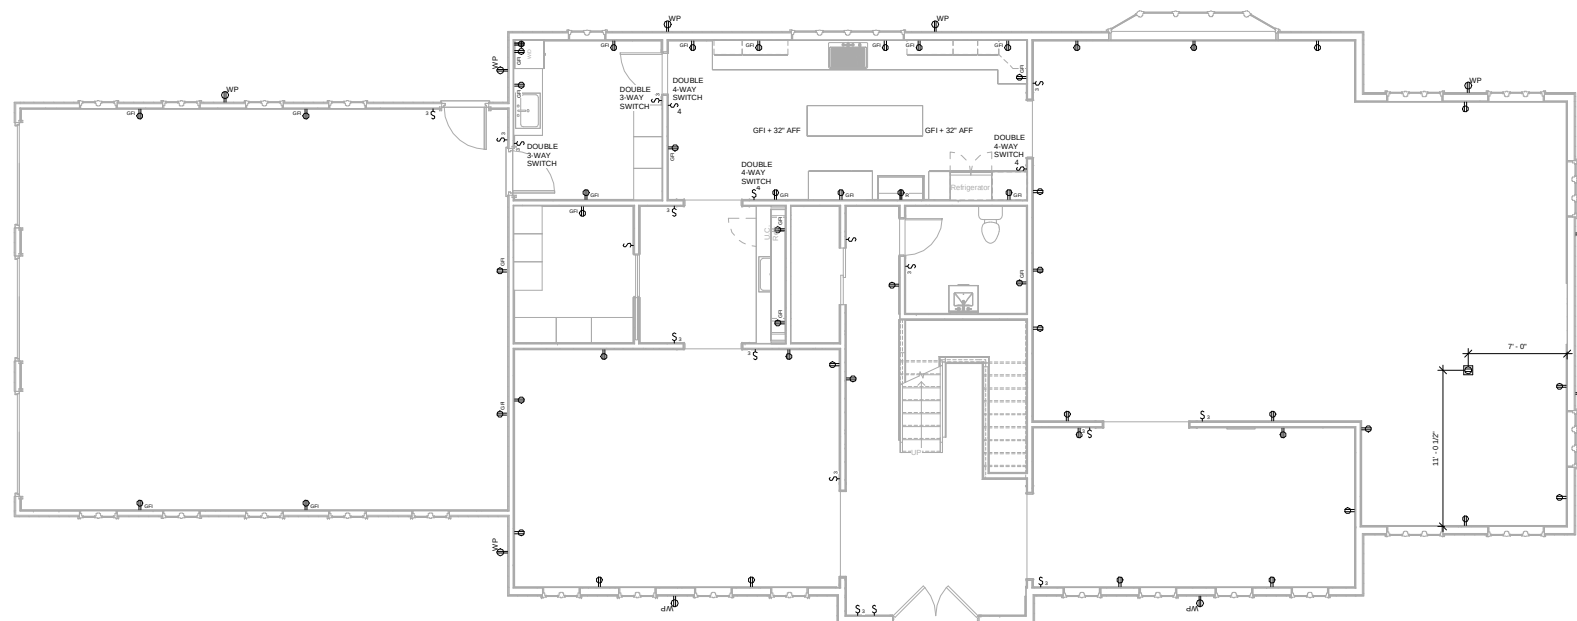

① First Floor Electrical
1/4" = 1'-0"



Consultant
Address
Address
Phone
Fax
e-mail

Consultant
Address
Address
Phone
Fax
e-mail

Consultant
Address
Address
Phone
Fax
e-mail

Consultant
Address
Address
Phone
Fax
e-mail

Consultant
Address
Address
Phone
Fax
e-mail


[illegible]

John Brown
New Residence
Second Floor Electrical

Project number	2025-3
Date	12.02.25
Drawn by	E. ACKERMAN
Checked by	Checker
A7	
Scale	1/4" = 1'-0"

Brown Residence Electrical Fixture Schedule		
Family and Type		Count
Kitchen, Built-In Dishwasher	HAFELE Florence: Smart Mate	495.06.530
Outlet-Floor: Single		1
Outlet-Communications: CATV		3
Outlet-Duplex: Single		62
Outlet-GFI: Single		26
Outlet-GFI: Single 2		1
Outlet-Range: Single		1
Outlet-Tripex: Tripex		1
Switch-Double: Double		3
Switch-Single: Single		13
Switch-Three Way: Three Way		17
Weather Proof Exterior: Standard		10

ELECTRICAL LEGEND	
	STANDARD DUPLEX OUTLET
	STANDARD GFI OUTLET
	240 RANGE OUTLET
	SPECIALTY OUTLET
	TV JACK/OUTLET
	WEATHERPROOF OUTLET
	RECESSED DUPLEX OUTLET

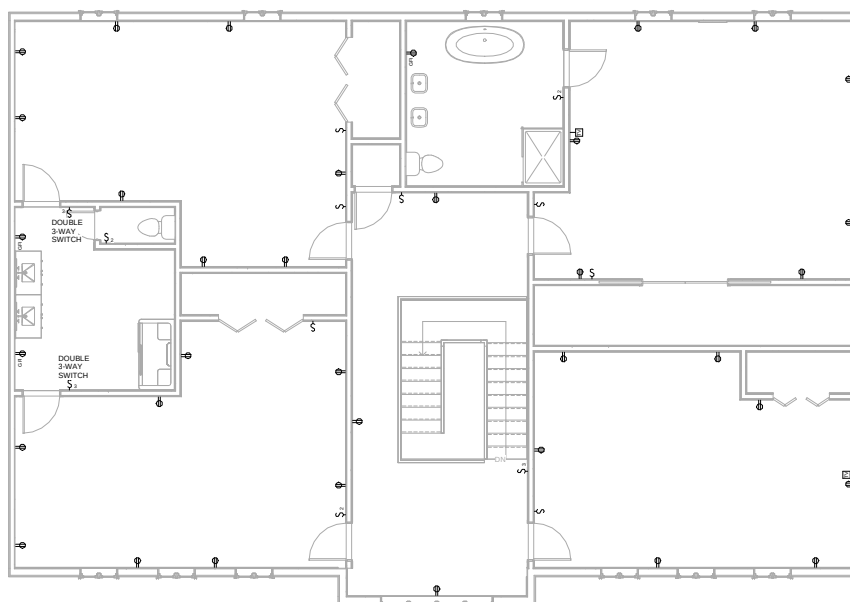

① Second Floor Electrical
1/4" = 1'-0"



Brown Residence Room Finish Schedule						
Room Number	Room Name	Floor	Base	Finish	Wall	Ceiling
1	FOYER	WOOD	WOOD	PAINT		PAINT
2	CL 1	WOOD	WOOD	PAINT		PAINT
3	POWDER BATH	TILE	WOOD	PAINT		PAINT
4	DINING	WOOD	WOOD	WALLPAPER		PAINT
5	BAR	WOOD	WOOD	WALLPAPER/PAINT		
6	PANTRY	WOOD	WOOD	PAINT		PAINT
7	LAUNDRY/MUD	TILE	WOOD	PAINT		PAINT
8	GARAGE	CONCRETE	WOOD			PAINT
9	KITCHEN	WOOD	WOOD	WALLPAPER/TILE		PAINT
10	LIVING ROOM	WOOD	WOOD	PAINT		PAINT
11	PARLOR	WOOD	WOOD	WALLPAPER		PAINT
12	HALLWAY	WOOD	WOOD	PAINT		PAINT
13	PLAYROOM	WOOD	WOOD	PAINT		PAINT
14	CL 2	WOOD	WOOD	PAINT		PAINT
15	BEDROOM 1	WOOD	WOOD	PAINT		PAINT
16	CL 4	WOOD	WOOD	PAINT		PAINT
17	SHARED BATH	TILE	WOOD	PAINT		PAINT
18	WC	WOOD	WOOD	PAINT		PAINT
19	CL 5	WOOD	WOOD	PAINT		PAINT
20	BEDROOM 2	WOOD	WOOD	PAINT		PAINT
21	CL 6	WOOD	WOOD	PAINT		PAINT
22	PRIMARY BEDROOM	WOOD	WOOD	WALLPAPER		PAINT
23	PRIMARY CLOSET	WOOD	WOOD	PAINT		PAINT
24	PRIMARY BATH	TILE	WOOD	PAINT		PAINT

Consultant	Address
Address	Phone
Phone	Fax
Fax	e-mail
Consultant	Address
Address	Phone
Phone	Fax
Fax	e-mail
Consultant	Address
Address	Phone
Phone	Fax
Fax	e-mail
Consultant	Address
Address	Phone
Phone	Fax
Fax	e-mail

[illegible]

John Brown
New Residence
First Floor Finish Plan

Project number	2025-3
Date	12.02.25
Drawn by	E. ACKERMAN
Checked by	Checker
A8	
Scale	1/4" = 1'-0"



① First Floor Finish Plan
1/4" = 1'-0"

Room Number	Room Name	Finish			
		Floor	Base	Wall	Ceiling
1	FOYER	WOOD	WOOD	PAINT	PAINT
2	CL 1	WOOD	WOOD	PAINT	PAINT
3	POWDER BATH	TILE	WOOD	PAINT	PAINT
4	DINING	WOOD	WOOD	WALLPAPER	PAINT
5	BAR	WOOD	WOOD	WALLPAPER/PAINT	PAINT
6	PANTRY	WOOD	WOOD	PAINT	PAINT
7	LAUNDRY/MUD	TILE	WOOD	PAINT	PAINT
8	GARAGE	CONCRETE	WOOD	PAINT	PAINT
9	KITCHEN	WOOD	WOOD	WALLPAPER/TILE	PAINT
10	LIVING ROOM	WOOD	WOOD	PAINT	PAINT
11	PARLOR	WOOD	WOOD	WALLPAPER	PAINT
12	HALLWAY	WOOD	WOOD	PAINT	PAINT
13	PLAYROOM	WOOD	PAINT	PAINT	PAINT
14	CL 2	WOOD	WOOD	PAINT	PAINT
15	BEDROOM 1	WOOD	WOOD	PAINT	PAINT
16	CL 4	WOOD	WOOD	PAINT	PAINT
17	SHARED BATH	TILE	WOOD	PAINT	PAINT
18	WC	WOOD	PAINT	PAINT	PAINT
19	CL 5	WOOD	WOOD	PAINT	PAINT
20	BEDROOM 2	WOOD	WOOD	PAINT	PAINT
21	CL 6	WOOD	WOOD	PAINT	PAINT
22	PRIMARY BEDROOM	WOOD	WOOD	WALLPAPER	PAINT
23	PRIMARY CLOSET	WOOD	PAINT	PAINT	PAINT
24	PRIMARY BATH	TILE	WOOD	PAINT	PAINT



① Second Floor Finish Plan
1/4" = 1'-0"



www.autodesk.com/revit

Consultant	
Address	
Address	
Phone	
Fax	
e-mail	

Consultant
Address
Address
Phone
Fax
e-mail

Consultant
Address
Address
Phone
Fax
e-mail

Consultant
Address
Address
Phone
Fax
e-mail

Consultant	
Address	
Address	
Phone	
Fax	
e-mail	


[illegible]

John Brown New Residence
Second Floor Finish Plan

Project number	2025-3
Date	12.02.25
Drawn by	E. ACKERMAN
Checked by	Checker
A9	
Scale	1/4" = 1'-0"

1/20/2026 5:47:14 PM

LIGHTING LEGEND	
	DOWNLIGHT RECESSED CAN
	MOOOI SERPENTINE CHANDELIER
	MOOOI STARFALL CHANDELIER
	VISUAL COMFORT LODY 20" CHANDELIER
	VISUAL COMFORT LINGER 18" CHANDELIER
	MARSET DISCOCO FLUSH MOUNT
	KRONLEUCHTER ZARAGONZA CHANDELIER
	KOHLER BELLERA SCONCE
	OKLAK GREEN SCONCE
	KOHLER GREENWICH SCONCE
	VISUAL COMFORT SPUR GRANDE CHANDELIER
	VISUAL COMFORT KAI FLUSH MOUNT
	KOHLER MCGEE SCONCE
	MOOOI MESHMATICS SMALL CHANDELIER
	KOHLER TERRET CHANDELIER
	MOOOI MESHMATICS STANDARD CHANDELIER
	VISUAL COMFORT LODY 18" CHANDELIER
	KOHLER HONESTY SCONCE
	BEVELO GOVERNOR GAS LANTERN
	VISUAL COMFORT PHOBOS SCONCE
	VISUAL COMFORT ACOVA PENDANT

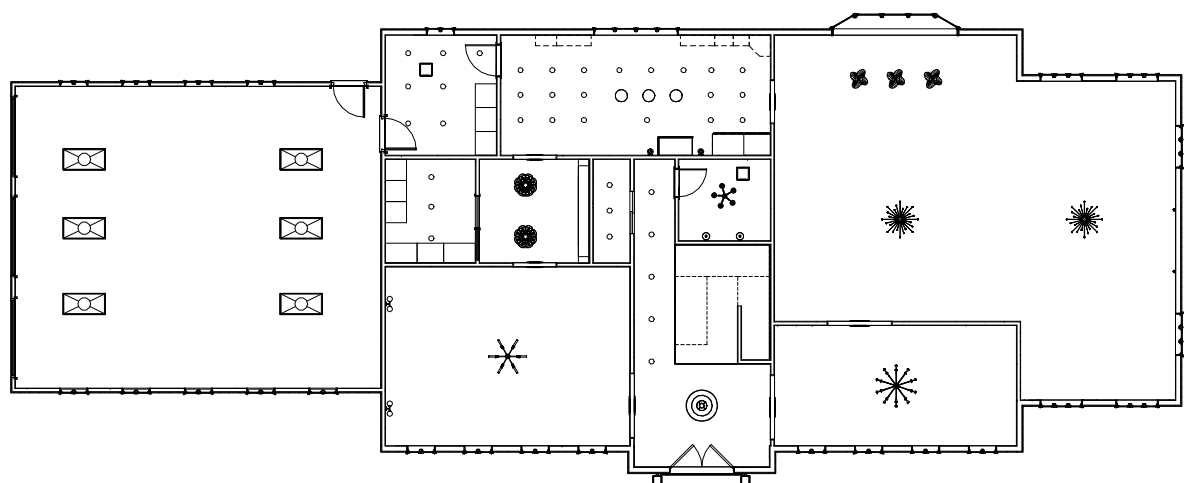

① First Floor Ceiling Plan
3/16" = 1'-0"



www.autodesk.com/revit

Consultant
Address
Address
Phone
Fax
e-mail

Consultant
Address
Address
Phone
Fax
e-mail

Consultant:
Address:
Address:
Phone:
Fax:
e-mail:

Consultant:
Address:
Address:
Phone:
Fax:
e-mail:


Consultant
Address
Address
Phone
Fax

[illegible]

John Brown
New Residence
First Floor Lighting
Plan

Project number	2025-3
Date	12.02.25
Drawn by	E. ACKERMAN
Checked by	Checker
A10	
Scale	As indicated

Brown Residence Lighting Fixture Schedule		
Family and Type		Count
Lighting-Flush Mount-Visual Comfort & Co-Kai 15: 700PMKA15W-LED930		1
Lighting-Pendant Mount-Visual Comfort & Co-Akova 13: Line Voltage: 700TDKAV13BR-LED927 2		3
Lighting-Suspended-Visual Comfort & Co-Longer 18: Chandelier: 700NLGB18B-LED930 2		3
Lighting-Suspended-Visual Comfort & Co-Loody 18: Chandeliers: 700LDY18R-LED930 2		1
Lighting-Suspended-Visual Comfort & Co-Loody 20: Chandeliers: 700LDY20L-LED930 3		1
Lighting-Suspended-Visual Comfort & Co-Spur Grande Chandeliers: 700SPGRG-LED927		1
Lighting-Wall Mount-Visual Comfort & Co-Phobos 2 Light: Source: 700WSPHB33NB-LED927		2
LR279 OKLAK GREEN - LIGHT FIXTURE ON WALL: LR279 OKLAK GREEN - LIGHT FIXTURE ON WALL		4
MARSET Interior-Lighting-Fixture-Ceiling, DiscoCo C68 US: A620-146		2
Mood Accessory Lighting, Meshmatics Chandelier: Small		1
Mood Accessory Lighting, Meshmatics Chandelier: Standard		2
Mood Accessory Lighting, Serpentine: White		3
Mood Accessory Lighting, Starfall Light Black 2		2
Table Lamp - Standard: 60W - 120V 2		1
TABLE LAMP 1, 20202: TABLE LAMP 1, 20202		2
Troffer Light - 2x4 Parabolic: 2'x4' (2 Lamp) - 120V		6
West Elm Modern Table Lamp, 15178: West Elm Modern Table Lamp, 15178		2

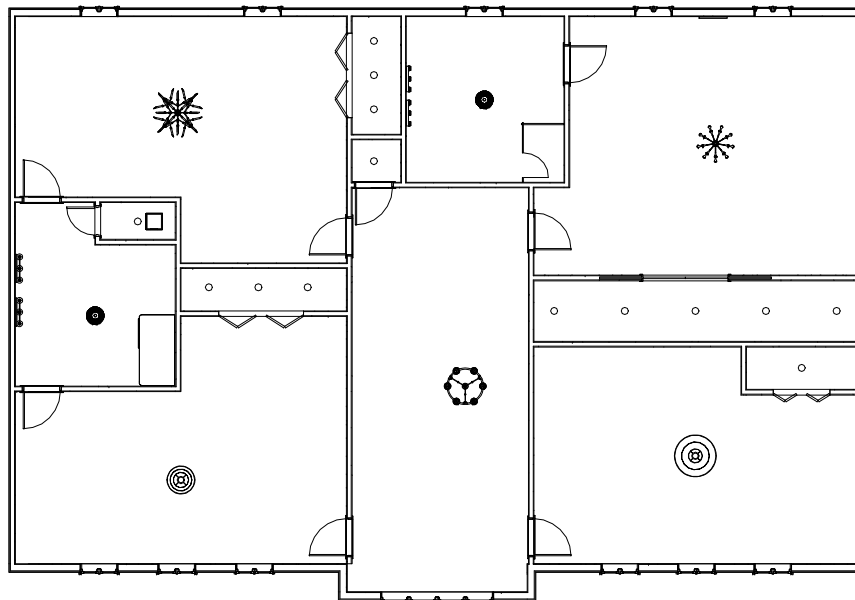

LIGHTING LEGEND	
	DOWNLIGHT RECESSED CAN
	MOOOI SERPENTINE CHANDELIER
	MOOOI STARFALL CHANDELIER
	VISUAL COMFORT LADY 20" CHANDELIER
	VISUAL COMFORT LINGER 18" CHANDELIER
	MARSET DISCOCO FLUSH MOUNT
	KRONLEUCHTER ZARAGONZA CHANDELIER
	KOHLER BELLERA SCONCE
	OKLAK GREEN SCONCE
	KOHLER GREENWICH SCONCE
	VISUAL COMFORT SPUR GRANDE CHANDELIER
	VISUAL COMFORT KAI FLUSH MOUNT
	KOHLER MCGEE SCONCE
	MOOOI MESHMATIC'S SMALL CHANDELIER
	KOHLER TERRET CHANDELIER
	MOOOI MESHMATIC'S STANDARD CHANDELIER
	VISUAL COMFORT LADY 18" CHANDELIER
	KOHLER HONESTY SCONCE
	BEVELO GOVERNOR GAS LANTERN
	VISUAL COMFORT PHOBOS SCONCE
	VISUAL COMFORT ACCOVA PENDANT

[illegible]

John Brown	
New Residence	
Second Floor Lighting Plan	
Project number	2025-3
Date	12.02.25
Drawn by	E. ACKERMAN
Checked by	Checker
A11	
Scale	1/4" = 1'-0"



Consultant
Address
Address
Phone
Fax
e-mail

Consultant
Address
Address
Phone
Fax
e-mail

Consultant
Address
Address
Phone
Fax
e-mail

Consultant
Address
Address
Phone
Fax
e-mail

Consultant
Address
Address
Phone
Fax
e-mail

[illegible]

John Brown
New Residence
Exterior Elevation


Project number	2025-3
Date	12.02.25
Drawn by	E. ACKERMAN
Checked by	Checker
A12	
Scale	3/16" = 1'-0"




① North
3/16" = 1'-0"




② South
3/16" = 1'-0"

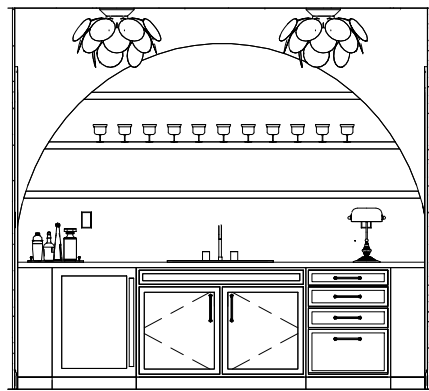


④ Wet Bar Elevation
3/4" = 1'-0"

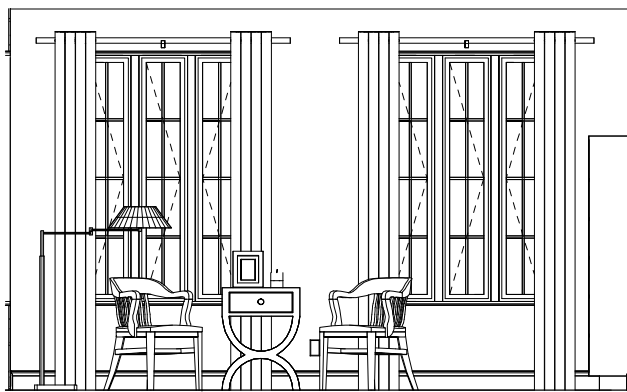

③ Reading Nook Elevation
3/4" = 1'-0"

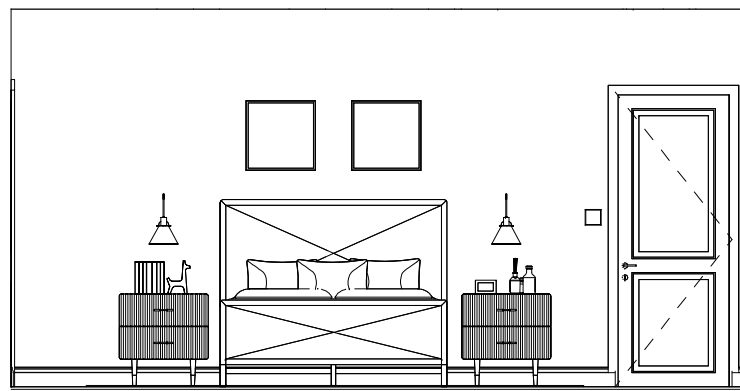

② Bedroom 1 Elevation
3/4" = 1'-0"

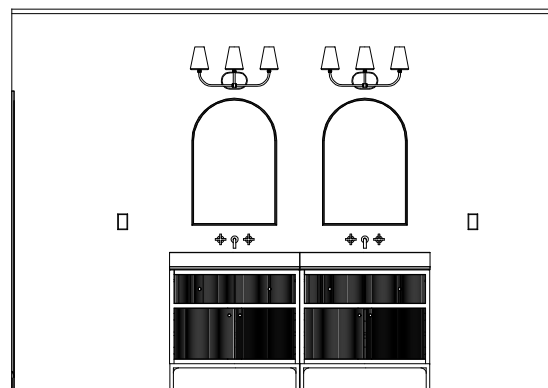

① Shared Bath Sink Elevation
3/4" = 1'-0"



www.autodesk.com/revit

Consultant
Address
Address
Phone
Fax
e-mail

Consultant
Address
Address
Phone
Fax
e-mail

Consultant
Address
Address
Phone
Fax
e-mail

Consultant
Address
Address
Phone
Fax
e-mail

Consultant
Address
Address
Phone
Fax
e-mail

[illegible]

John Brown
New Residence
Interior Elevations

Project number	2025-3
Date	12.02.25
Drawn by	E. ACKERMAN
Checked by	Checker
A13	
Scale	3/4" = 1'-0"



www.autodesk.com/revit

Consultant
Address
Address
Phone
Fax
e-mail

Consultant
Address
Address
Phone
Fax
e-mail

Consultant
Address
Address
Phone
Fax
e-mail

Consultant
Address
Address
Phone
Fax
e-mail

Consultant
Address
Address
Phone
Fax
e-mail


[illegible]

John Brown
New Residence
Renderings


Project number	2025-3
Date	12.02.25
Drawn by	E. ACKERMAN
Checked by	Checker
A14	
Scale	

BROWN RESIDENCE SUPPORT BOARD
ELIZABETH ACKERMAN
TXMI 5330 ADV COM AID RES DESIGN
RICH
FALL 2025

FORMAL LIVING ROOM

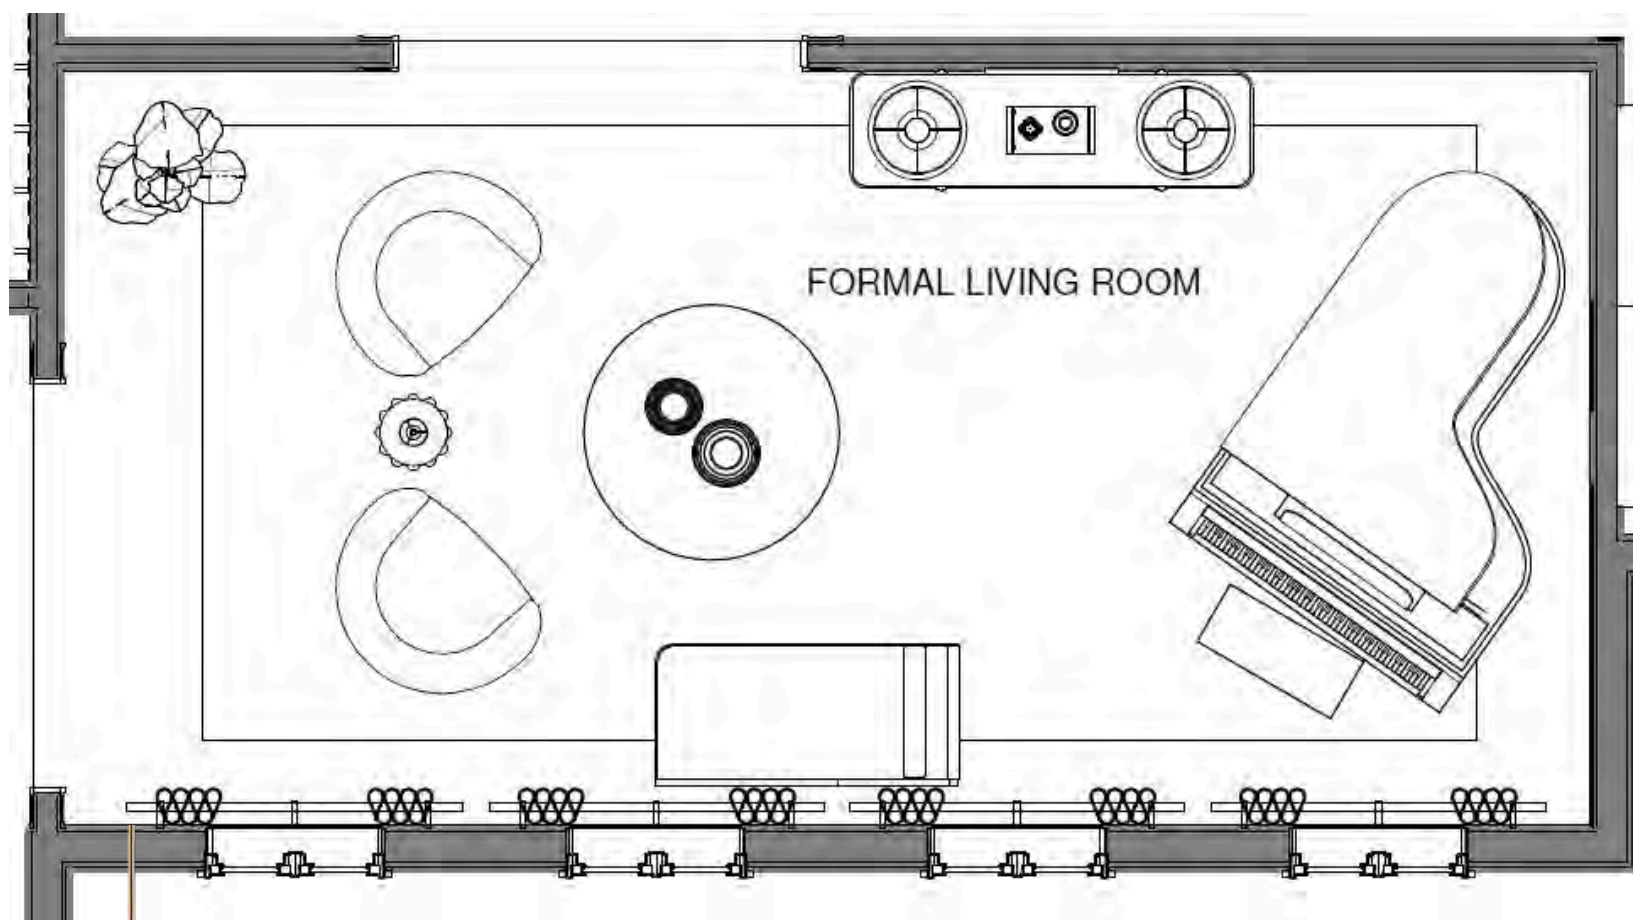


DINING ROOM

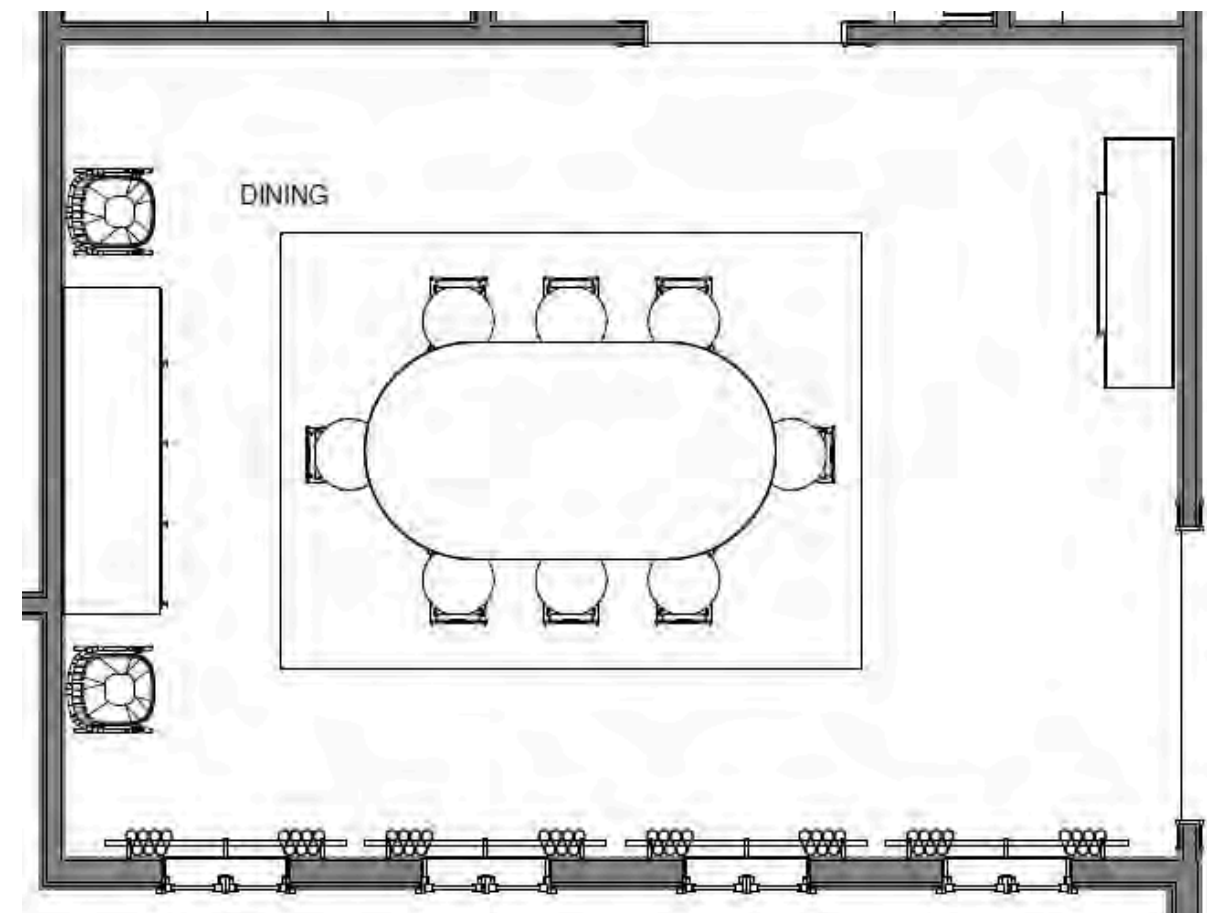

SW 6447
Evergreens



KITCHEN

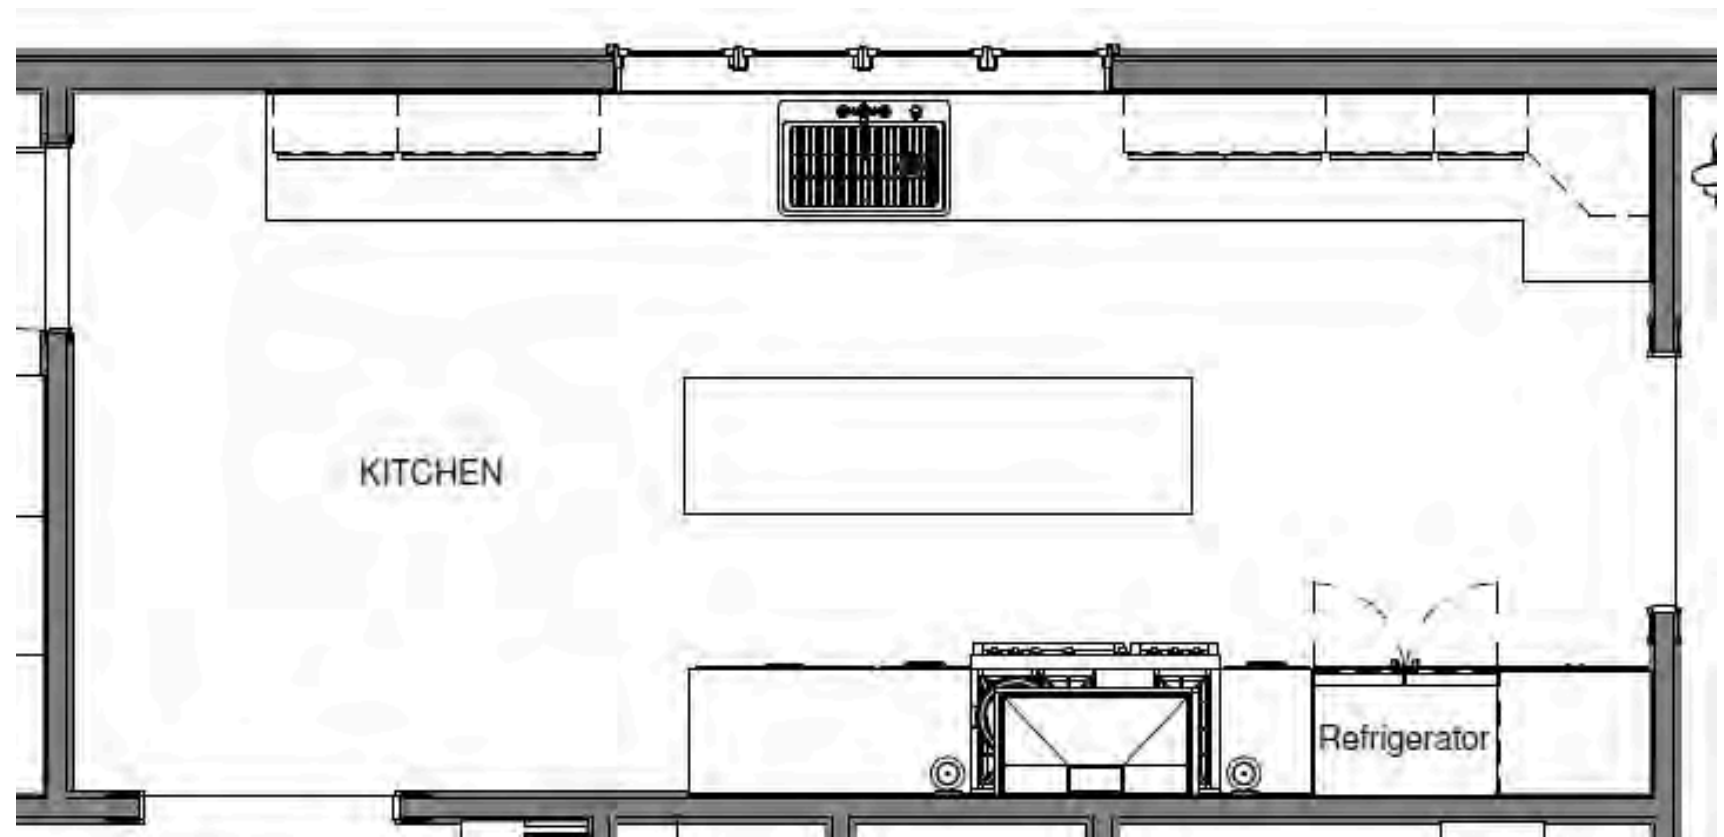

PRIMARY BEDROOM

